


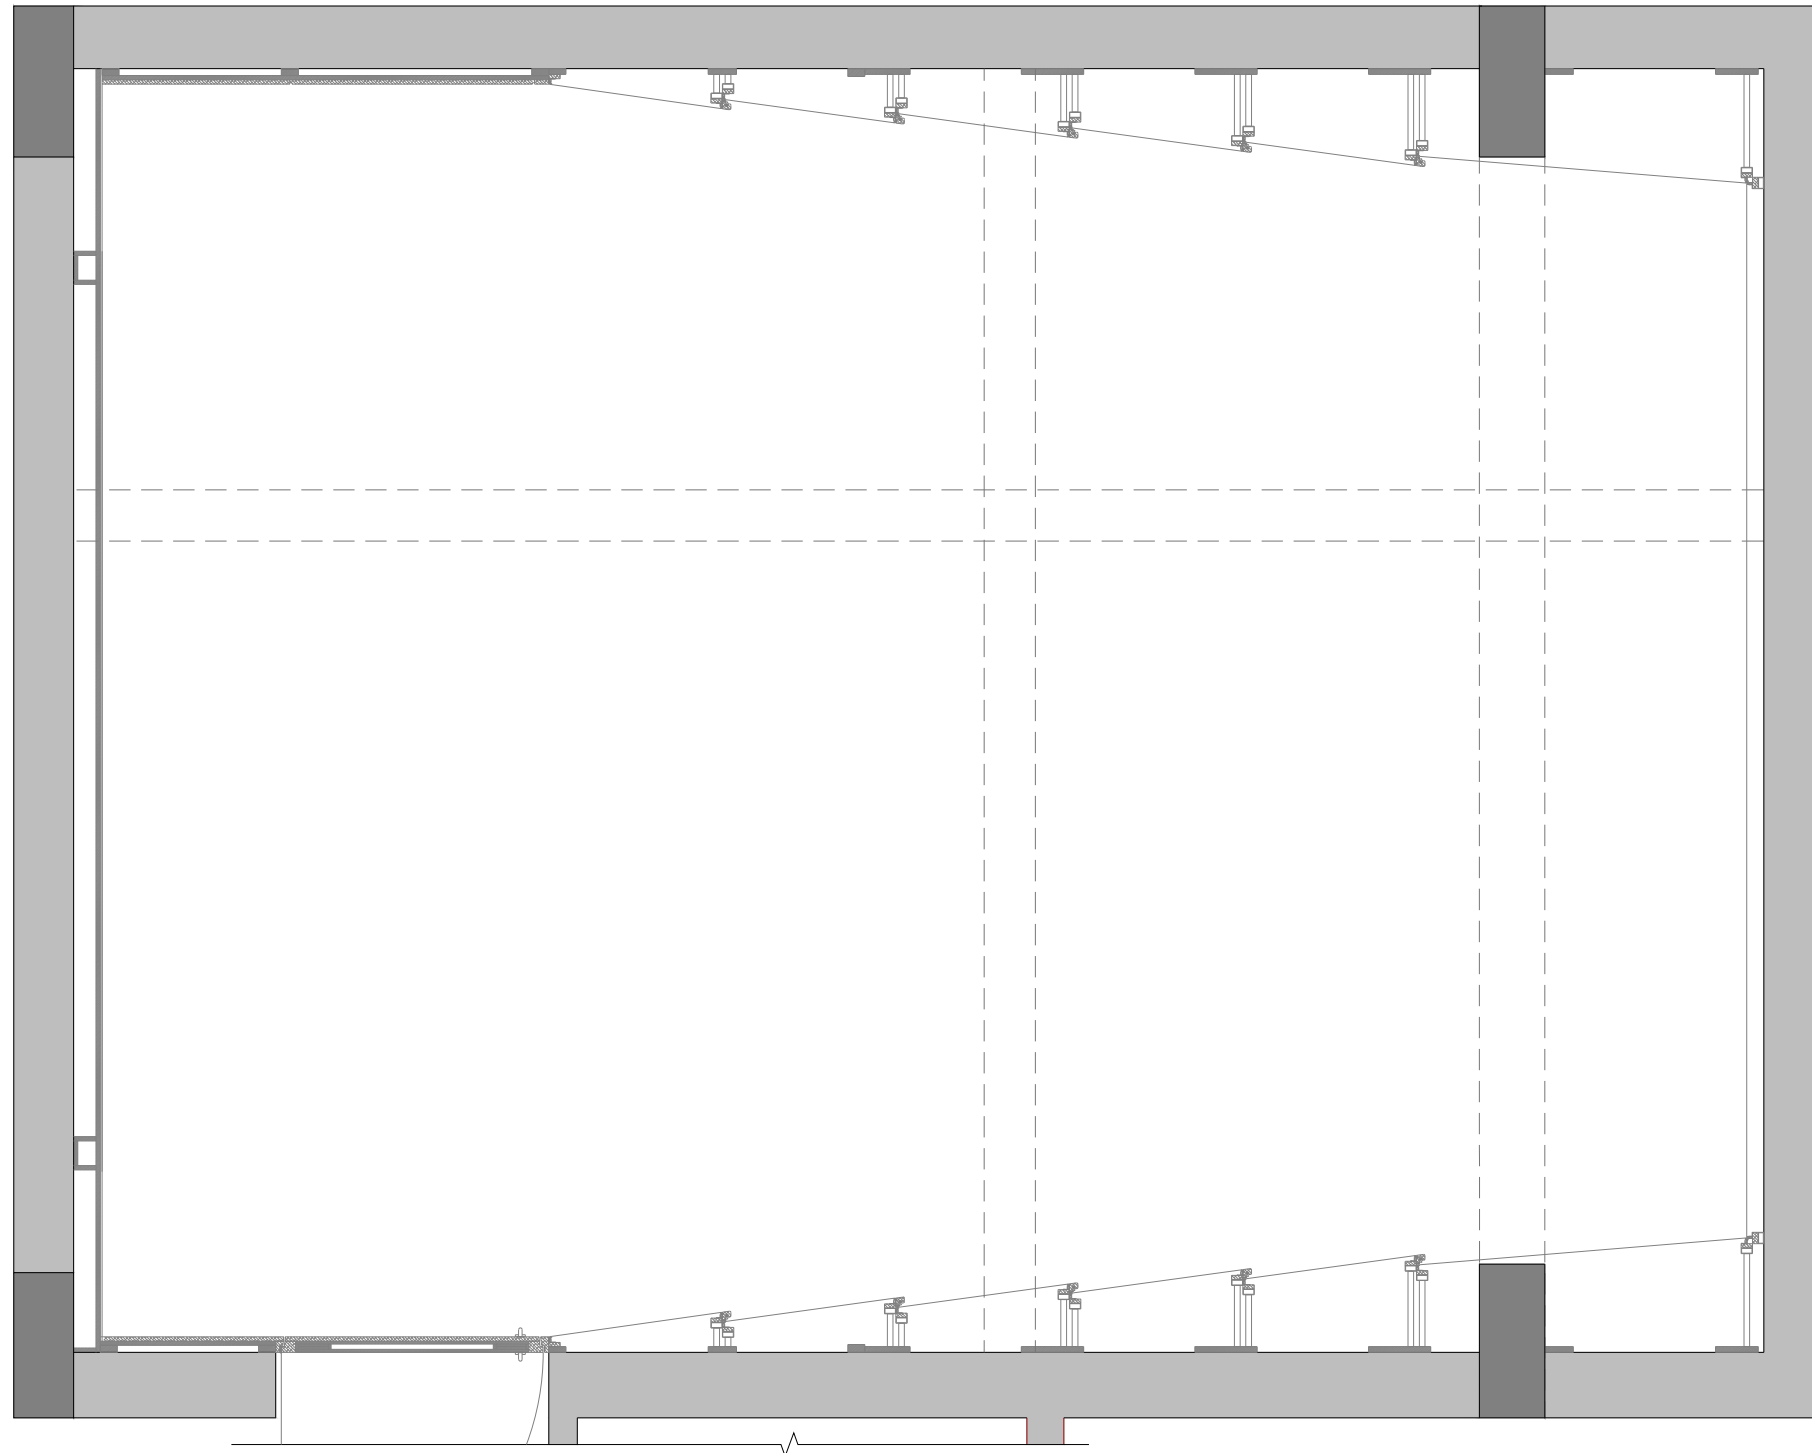

Clinical Retreat
HANDOVER PACK



AUDIO VIDEO SYMBOLS		
SYMBOL	NAME	DO=DEVICE OPTIONS
	SPEAKER	LCR-LCR BAR SU-SUBWOOFER ST-STEREO
	VIDEO PROJECTOR	LCD-LIQUID CRYSTAL DISPLAY DLP-DIGITAL LIGHT PROCESSOR SXRD-SILICON X-TEL REF. DISP.
	PROJECTON SCREEN	F-FIXED M-MOTORISED

COMMUNICATIONS SYMBOLS		
SYMBOL	NAME	DO=DEVICE OPTIONS
	PHONE AND DATA PORT	D-DATA F-FIBRE OPTIC P-PHONE
	INCOMING SERVICES	CTV-CABLE TV P-PHONE S-SATELLITE
	RF REPEATER ACCESS POINT	CR-CELLUAR PR-PHONE WAP-WIRELESSACCESS POINT

FURNISHINGS SYMBOLS		
SYMBOL	NAME	DO=DEVICE OPTIONS
	RACK OR HEAD END	AV-AUDIO/VIDEO C-CONTROL D-DATA SEC-SECURITY
	LIFT/MOUNT	A-ARTICULATED M-MOTORISED UB-UNDER BED

EXAMPLES: SYMBOL + MOUNTING OPTION		
SYMBOL	NAME	MOUNT TYPE
	SPEAKER	CEILING MOUNTED
	SPEAKER	WALL MOUNTED
	SPEAKER	FLOOR MOUNTED
	PRE-WIRE SPEAKER	CEILING MOUNTED PRE-WIRE ONLY NO CUTOUT

CABLING OPTIONS			
	SPKR	2CX2.5 mm²	SPEAKER CABLE
	COXL	COAXIAL	SUBWOOFER CABLE
	CAT6	CAT6	DATA CABLE
	HDMI	HDMI	VIDEO CABLE

Client : CLINICAL RETREAT

Location : ANAND

Created 06-06-2017
 Modified Not yet
 Printed Not yet

Drawing Name :
 AV FLOOR PLAN


Drawing Type :
 FLOOR PLAN

Drawing Scale : SCALE TO FIT

Designed by Ruchi

Checked by Ankur Bhatt

HC-052/1

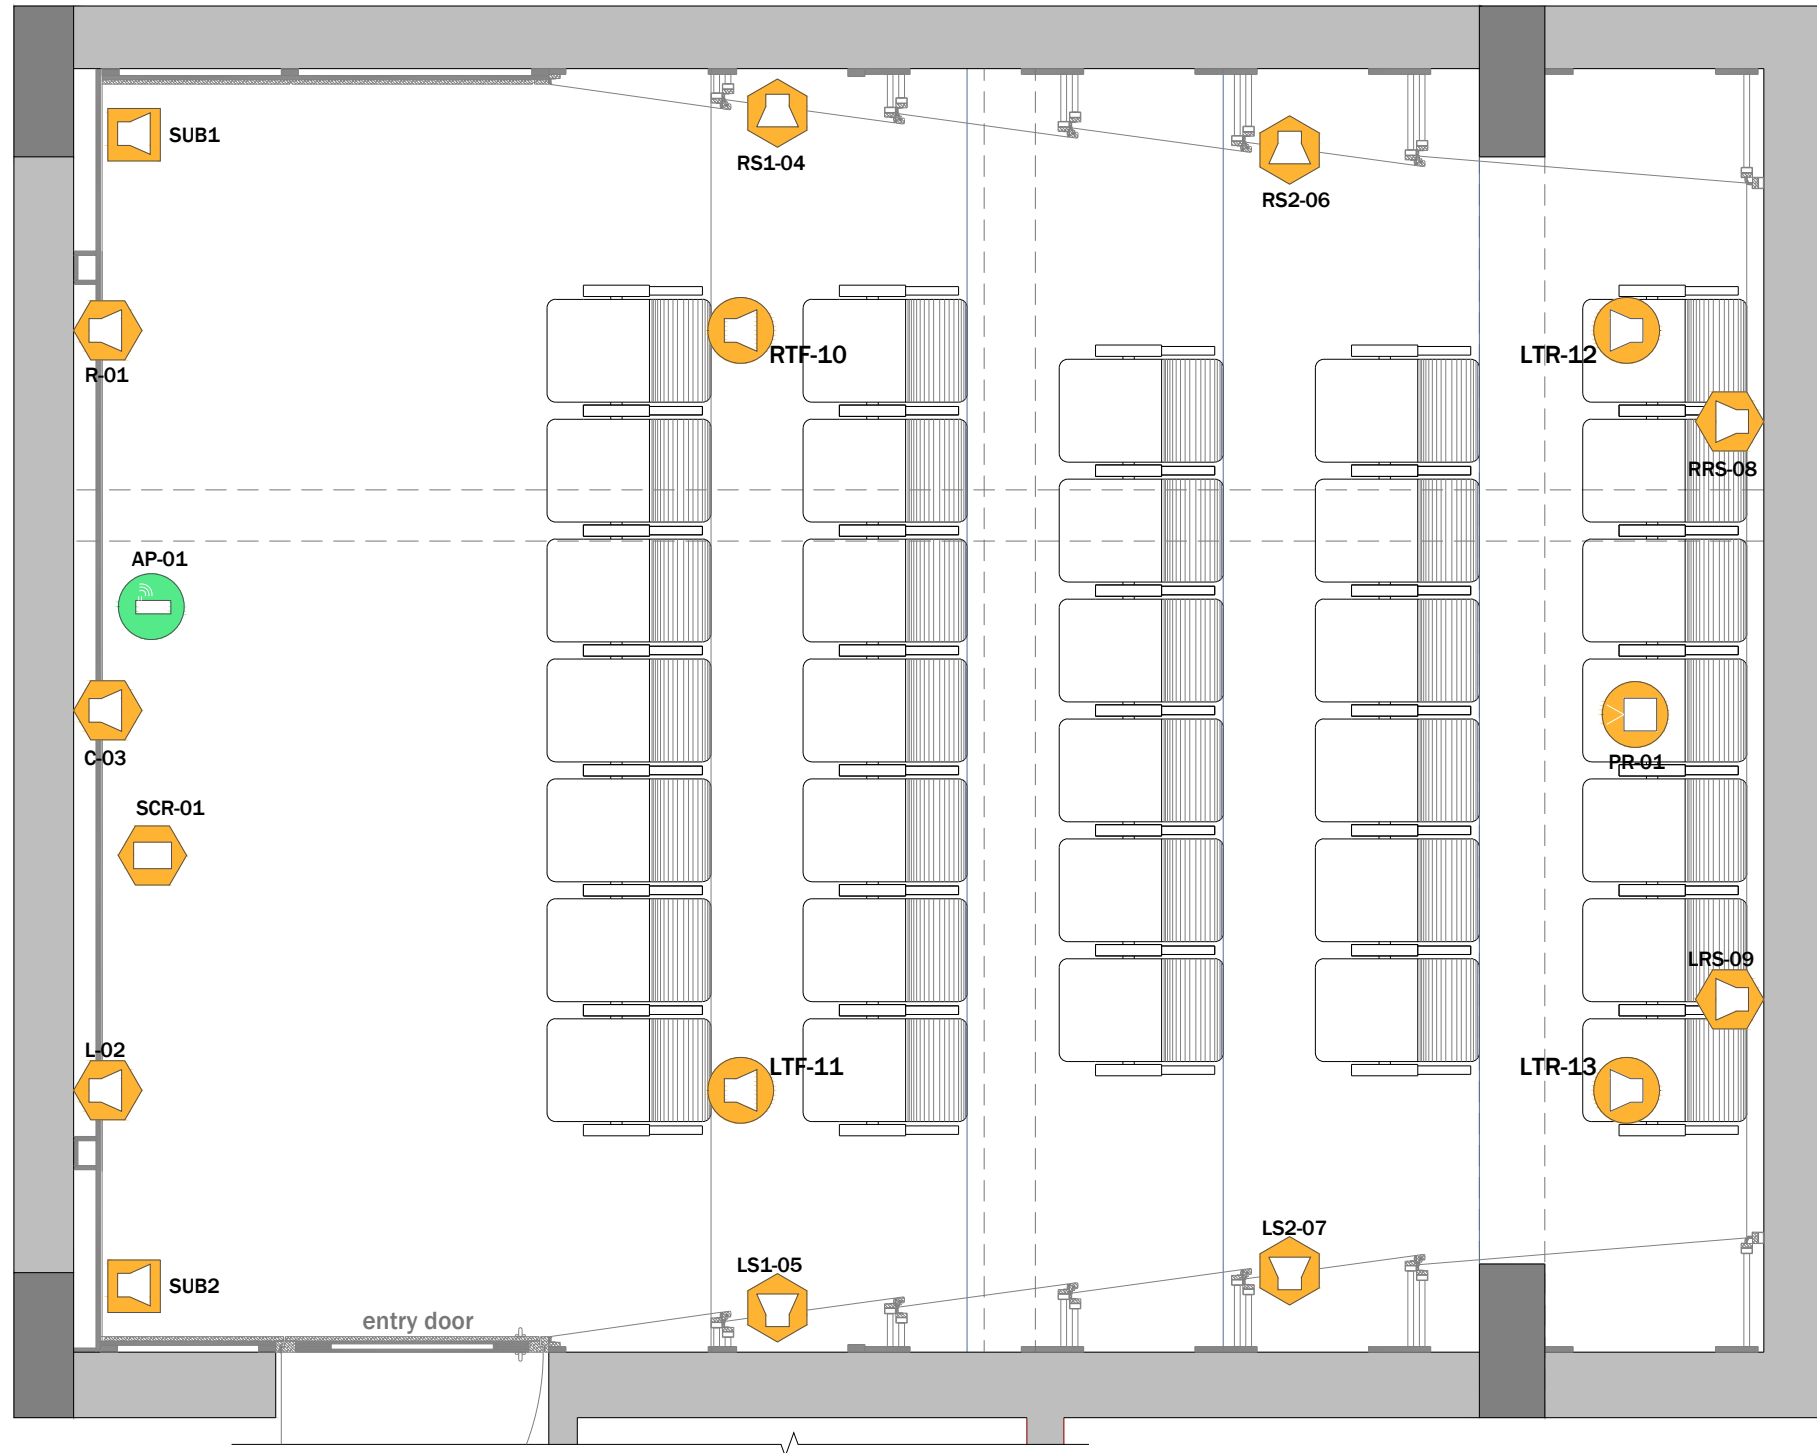

AUDIO VIDEO SYMBOLS		
SYMBOL	NAME	DO=DEVICE OPTIONS
	SPEAKER	LCR-LCR BAR SU-SUBWOOFER ST-STEREO
	VIDEO PROJECTOR	LCD-LIQUID CRYSTAL DISPLAY DLP-DIGITAL LIGHT PROCESSOR SXRD-SILICON X-TEL REF. DISP.
	PROJECTON SCREEN	F-FIXED M-MOTORISED

COMMUNICATIONS SYMBOLS		
SYMBOL	NAME	DO=DEVICE OPTIONS
	PHONE AND DATA PORT	D-DATA F-FIBRE OPTIC P-PHONE
	INCOMING SERVICES	CTV-CABLE TV P-PHONE S-SATELLITE
	RF REPEATER ACCESS POINT	CR-CELLUAR PR-PHONE WAP-WIRELESSACCESS POINT

FURNISHINGS SYMBOLS		
SYMBOL	NAME	DO=DEVICE OPTIONS
	RACK OR HEAD END	AV-AUDIO/VIDEO C-CONTROL D-DATA SEC-SECURITY
	LIFT/MOUNT	A-ARTICULATED M-MOTORISED UB-UNDER BED

EXAMPLES: SYMBOL + MOUNTING OPTION		
SYMBOL	NAME	MOUNT TYPE
	SPEAKER	CEILING MOUNTED
	SPEAKER	WALL MOUNTED
	SPEAKER	FLOOR MOUNTED
	PRE-WIRE SPEAKER	CEILING MOUNTED PRE-WIRE ONLY NO CUTOUT

CABLING OPTIONS			
	SPKR	2CX2.5 mm²	SPEAKER CABLE
	COXL	COAXIAL	SUBWOOFER CABLE
	CAT6	CAT6	DATA CABLE
	HDMI	HDMI	VIDEO CABLE

Client : CLINICAL RETREAT

Location : ANAND

Created 06-06-2017
 Modified Not yet
 Printed Not yet

Drawing Name :
 AV FLOOR PLAN


Drawing Type :
 AV FLOOR PLAN

Drawing Scale : SCALE TO FIT

Designed by Ruchi

Checked by Ankur Bhatt

HC-052/1.1

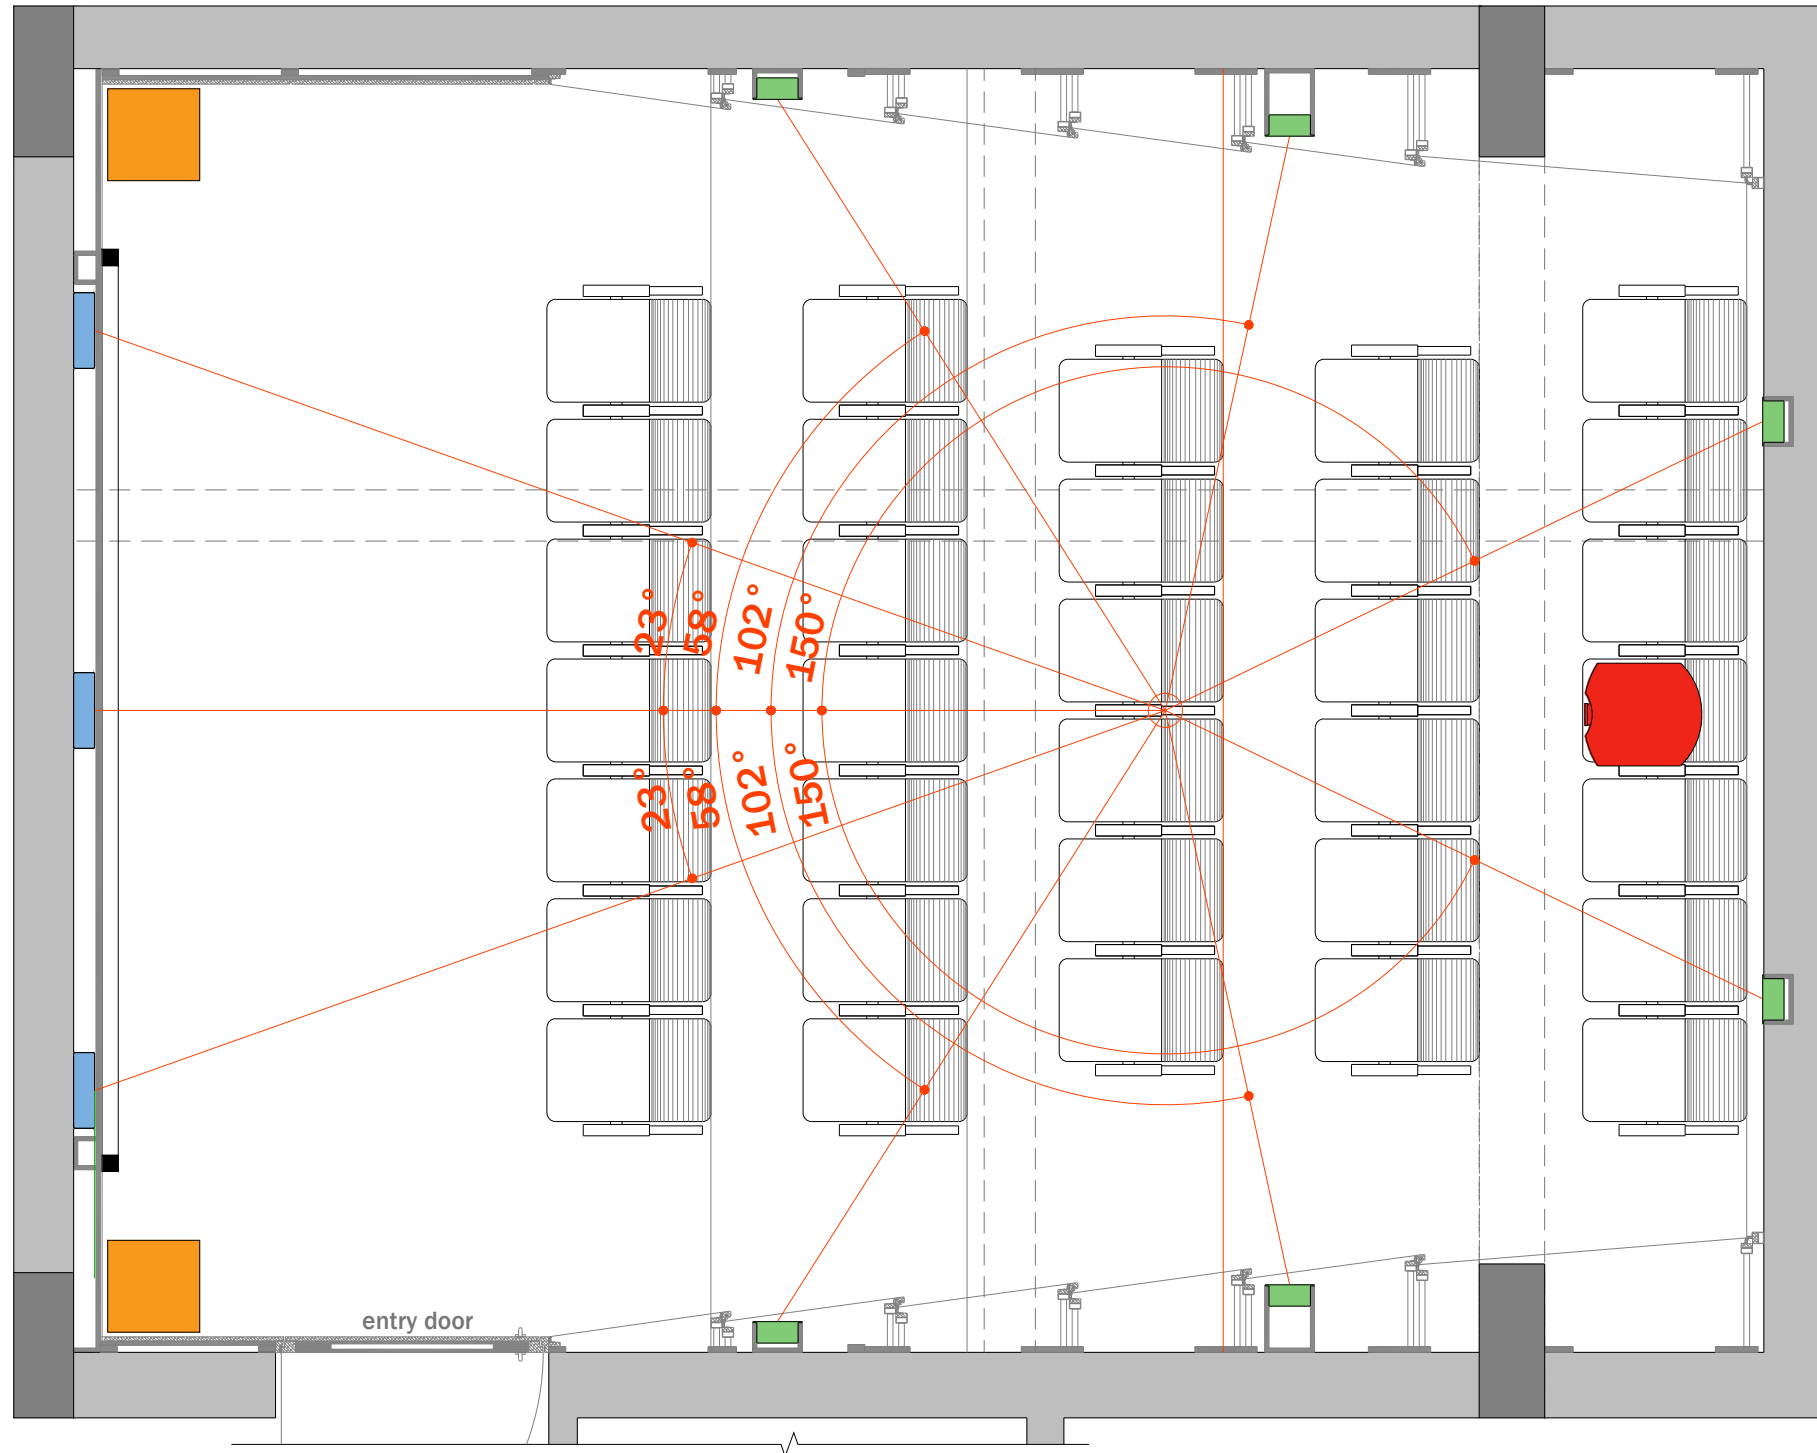

AUDIO VIDEO SYMBOLS		
SYMBOL	NAME	DO=DEVICE OPTIONS
	SPEAKER	LCR-LCR BAR SU-SUBWOOFER ST-STEREO
	VIDEO PROJECTOR	LCD-LIQUID CRYSTAL DISPLAY DLP-DIGITAL LIGHT PROCESSOR SXRD-SILICON X-TEL REF. DISP.
	PROJECTON SCREEN	F-FIXED M-MOTORISED

COMMUNICATIONS SYMBOLS		
SYMBOL	NAME	DO=DEVICE OPTIONS
	PHONE AND DATA PORT	D-DATA F-FIBRE OPTIC P-PHONE
	INCOMING SERVICES	CTV-CABLE TV P-PHONE S-SATELLITE
	RF REPEATER ACCESS POINT	CR-CELLUAR PR-PHONE WAP-WIRELESSACCESS POINT

FURNISHINGS SYMBOLS		
SYMBOL	NAME	DO=DEVICE OPTIONS
	RACK OR HEAD END	AV-AUDIO/VIDEO C-CONTROL D-DATA SEC-SECURITY
	LIFT/MOUNT	A-ARTICULATED M-MOTORISED UB-UNDER BED

EXAMPLES: SYMBOL + MOUNTING OPTION		
SYMBOL	NAME	MOUNT TYPE
	SPEAKER	CEILING MOUNTED
	SPEAKER	WALL MOUNTED
	SPEAKER	FLOOR MOUNTED
	PRE-WIRE SPEAKER	CEILING MOUNTED PRE-WIRE ONLY NO CUTOUT

CABLING OPTIONS			
	SPKR	2CX2.5 mm ²	SPEAKER CABLE
	COXL	COAXIAL	SUBWOOFER CABLE
	CAT6	CAT6	DATA CABLE
	HDMI	HDMI	VIDEO CABLE

Client : CLINICAL RETREAT

Location : ANAND

Created 06-06-2017
 Modified Not yet
 Printed Not yet

Drawing Name :
 AV FLOOR PLAN

Drawing Type :
 SPEAKER PLACEMENT

Drawing Scale : SCALE TO FIT

Designed by Ruchi

Checked by Ankur Bhatt

HC-052/1.2

1 SPEAKER PLACEMENT

SCALE: TO FIT

AUDIO VIDEO SYMBOLS			
SYMBOL	NAME	DO=DEVICE OPTIONS	
	SPEAKER	LCR-LCR BAR SU-SUBWOOFER ST-STEREO	
	VIDEO PROJECTOR	LCD-LIQUID CRYSTAL DISPLAY DLP-DIGITAL LIGHT PROCESSOR SXRD-SILICON X-TEL REF. DISP.	
	PROJECTON SCREEN	F-FIXED M-MOTORISED	
COMMUNICATIONS SYMBOLS			
SYMBOL	NAME	DO=DEVICE OPTIONS	
	PHONE AND DATA PORT	D-DATA F-FIBRE OPTIC P-PHONE	
	INCOMING SERVICES	CTV-CABLE TV P-PHONE S-SATELLITE	
	RF REPEATER ACCESS POINT	CR-CELLUAR PR-PHONE WAP-WIRELESSACCESS POINT	
FURNISHINGS SYMBOLS			
SYMBOL	NAME	DO=DEVICE OPTIONS	
	RACK OR HEAD END	AV-AUDIO/VIDEO C-CONTROL D-DATA SEC-SECURITY	
	LIFT/MOUNT	A-ARTICULATED M-MOTORISED UB-UNDER BED	
EXAMPLES: SYMBOL + MOUNTING OPTION			
SYMBOL	NAME	MOUNT TYPE	
	SPEAKER	CEILING MOUNTED	
	SPEAKER	WALL MOUNTED	
	SPEAKER	FLOOR MOUNTED	
	PRE-WIRE SPEAKER	CEILING MOUNTED PRE-WIRE ONLY NO CUTOUT	
CABLING OPTIONS			
	SPKR	2CX2.5 mm ²	SPEAKER CABLE
	COXL	COAXIAL	SUBWOOFER CABLE
	CAT6	CAT6	DATA CABLE
	HDMI	HDMI	VIDEO CABLE

Client : CLINICAL RETREAT

Location : ANAND

Created 06-06-2017
 Modified Not yet
 Printed Not yet

Drawing Name :
 AV FLOOR PLAN


Drawing Type :
 SPEAKER DIMENSIONS

Drawing Scale : SCALE TO FIT

Designed by Ruchi


Checked by Ankur Bhatt

HC-052/1.3

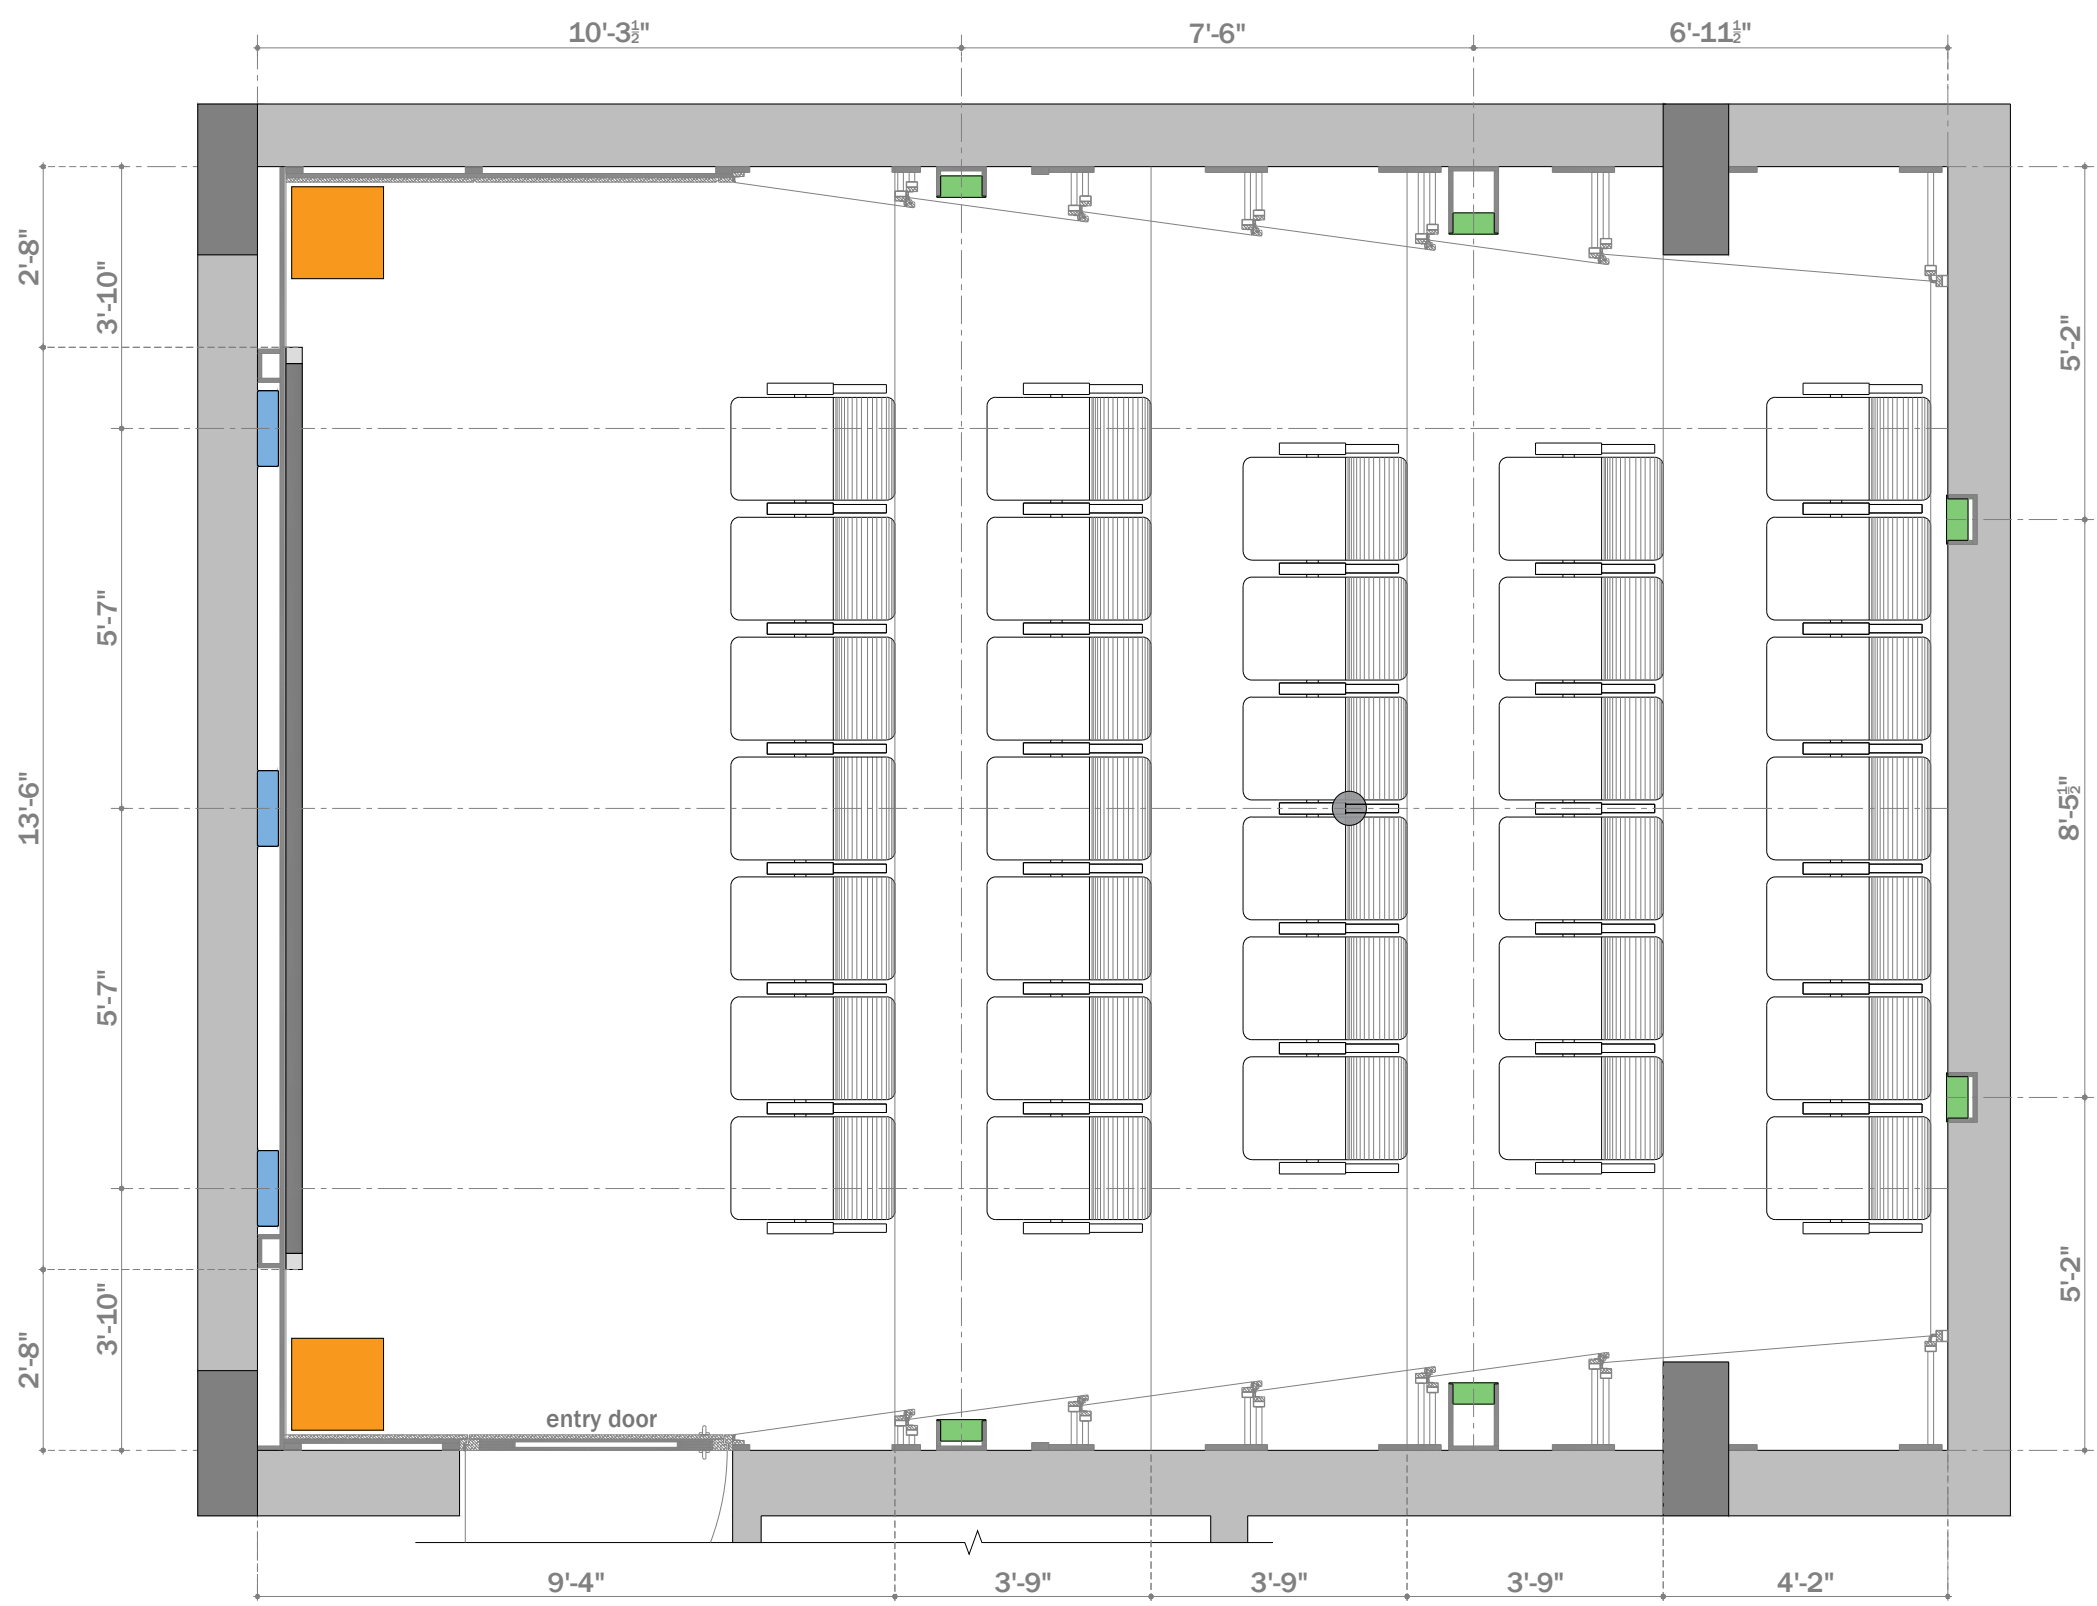

1 SPEAKER DIMENSIONS

SCALE: TO FIT

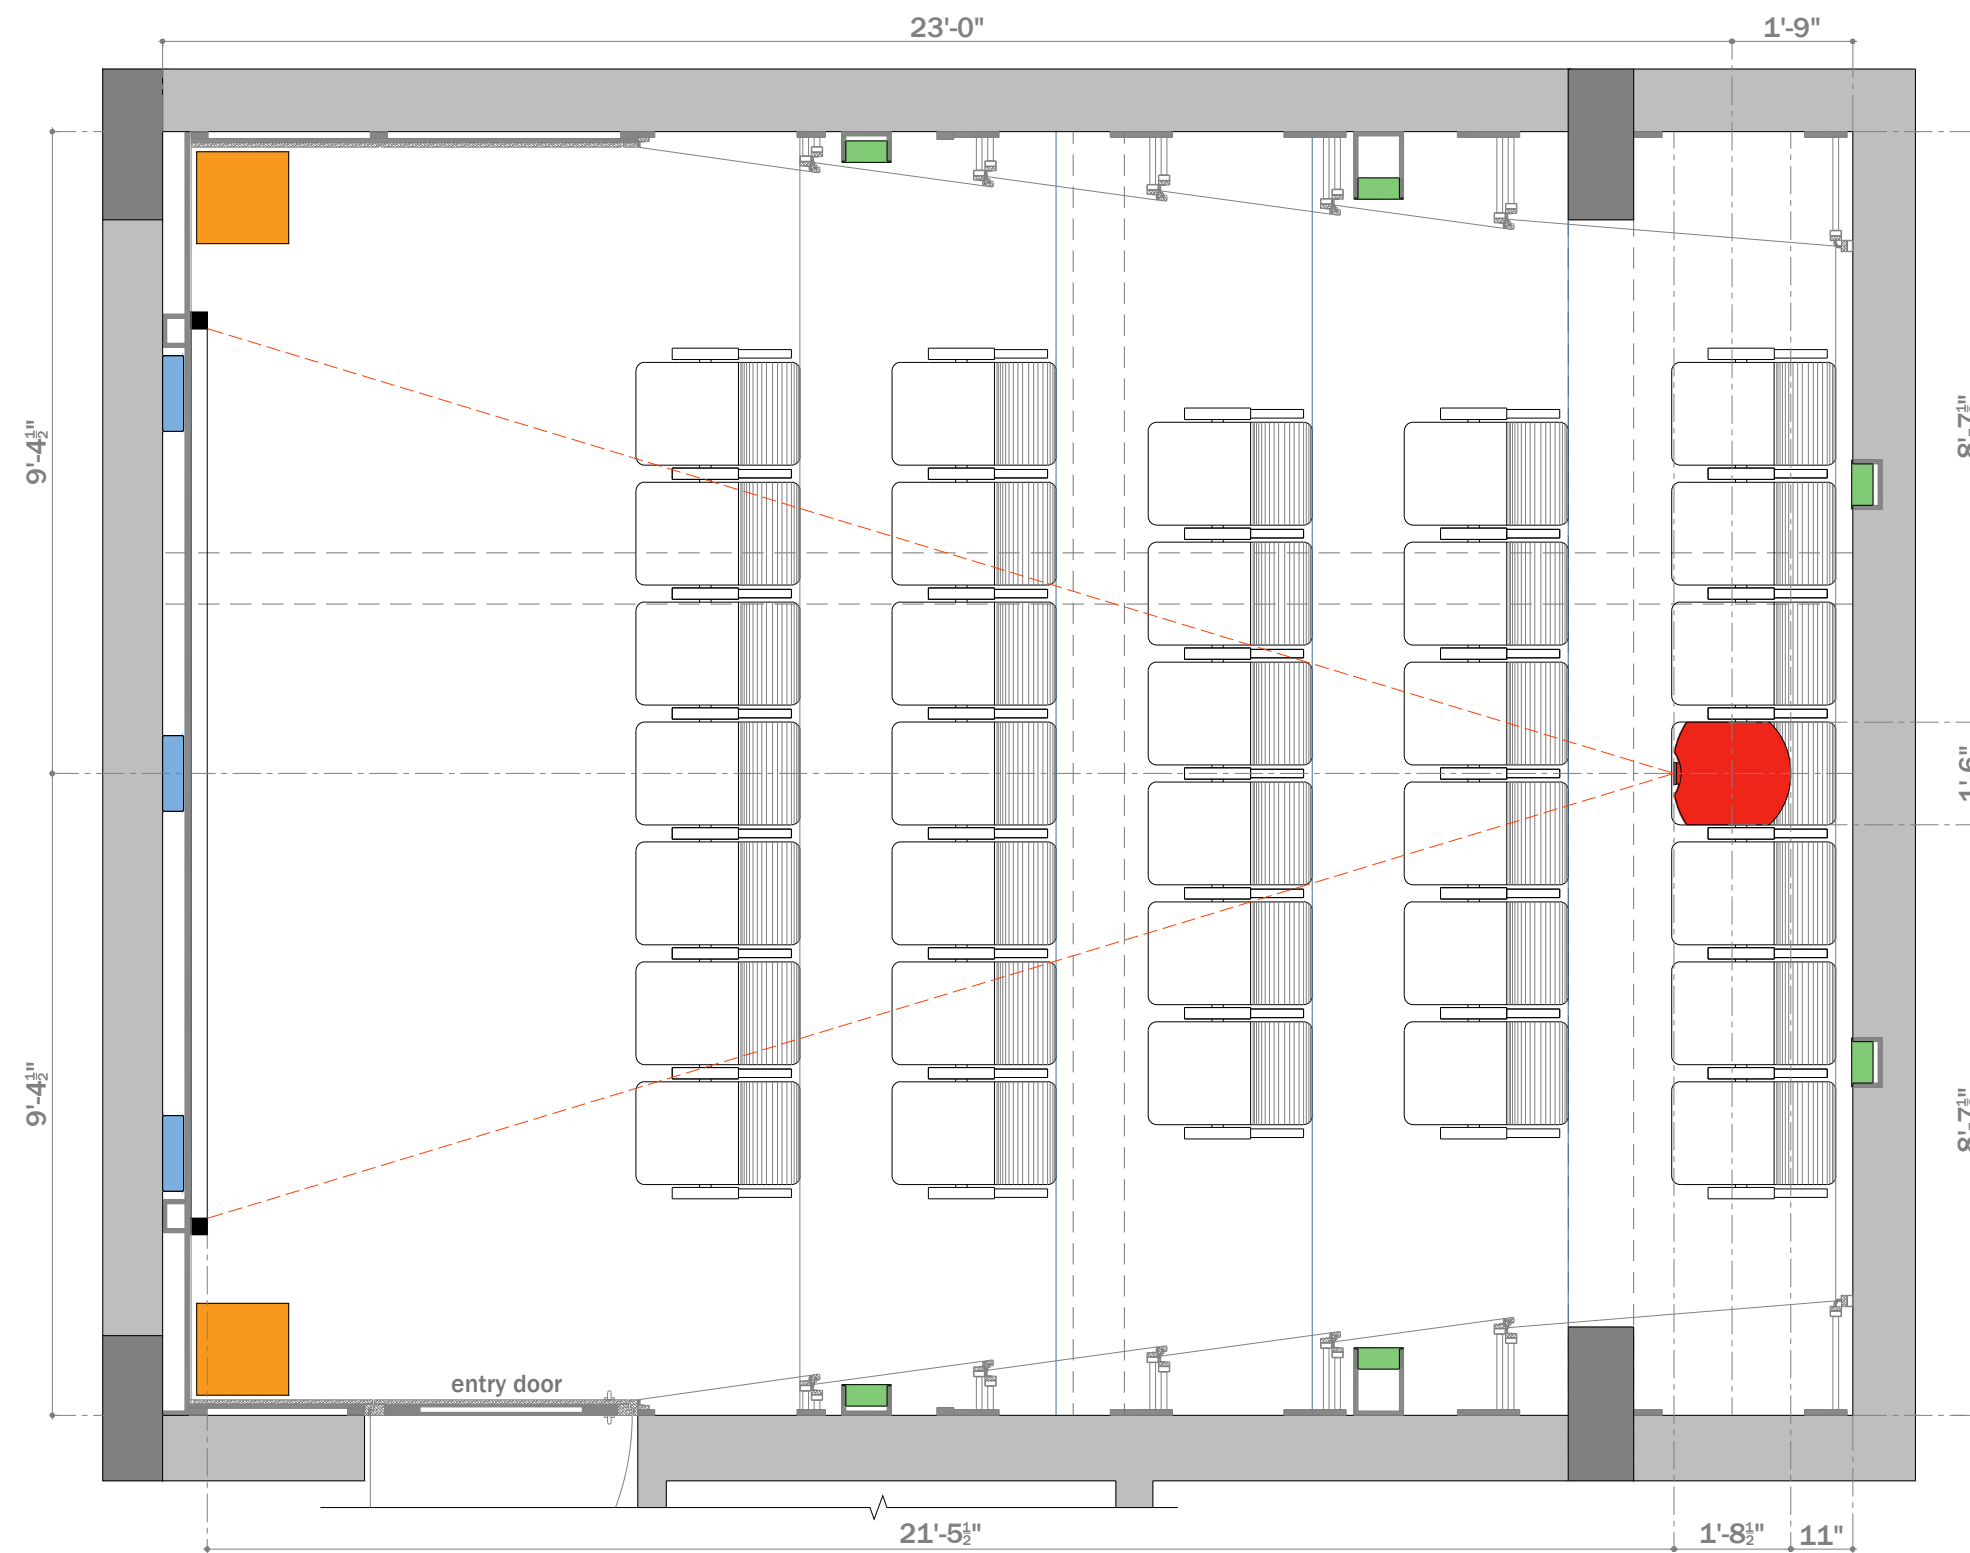

Floor Plan

AUDIO VIDEO SYMBOLS			
SYMBOL	NAME	DO=DEVICE OPTIONS	
	SPEAKER	LCR-LCR BAR SU-SUBWOOFER ST-STEREO	
	VIDEO PROJECTOR	LCD-LIQUID CRYSTAL DISPLAY DLP-DIGITAL LIGHT PROCESSOR SXRD-SILICON X-TEL REF. DISP.	
	PROJECTON SCREEN	F-FIXED M-MOTORISED	
COMMUNICATIONS SYMBOLS			
SYMBOL	NAME	DO=DEVICE OPTIONS	
	PHONE AND DATA PORT	D-DATA F-FIBRE OPTIC P-PHONE	
	INCOMING SERVICES	CTV-CABLE TV P-PHONE S-SATELLITE	
	RF REPEATER ACCESS POINT	CR-CELLUAR PR-PHONE WAP-WIRELESSACCESS POINT	
FURNISHINGS SYMBOLS			
SYMBOL	NAME	DO=DEVICE OPTIONS	
	RACK OR HEAD END	AV-AUDIO/VIDEO C-CONTROL D-DATA SEC-SECURITY	
	LIFT/MOUNT	A-ARTICULATED M-MOTORISED UB-UNDER BED	
EXAMPLES: SYMBOL + MOUNTING OPTION			
SYMBOL	NAME	MOUNT TYPE	
	SPEAKER	CEILING MOUNTED	
	SPEAKER	WALL MOUNTED	
	SPEAKER	FLOOR MOUNTED	
	PRE-WIRE SPEAKER	CEILING MOUNTED PRE-WIRE ONLY NO CUTOUT	
CABLING OPTIONS			
	SPKR	2CX2.5 mm ²	SPEAKER CABLE
	COXL	COAXIAL	SUBWOOFER CABLE
	CAT6	CAT6	DATA CABLE
	HDMI	HDMI	VIDEO CABLE

Client : CLINICAL RETREAT

Location : ANAND

Created 06-06-2017
 Modified Not yet
 Printed Not yet

Drawing Name :
 AV FLOOR PLAN


Drawing Type :
 PROJECTOR VIEWING

Drawing Scale : SCALE TO FIT

Designed by Ruchi

Checked by Ankur Bhatt

HC-052/1.4

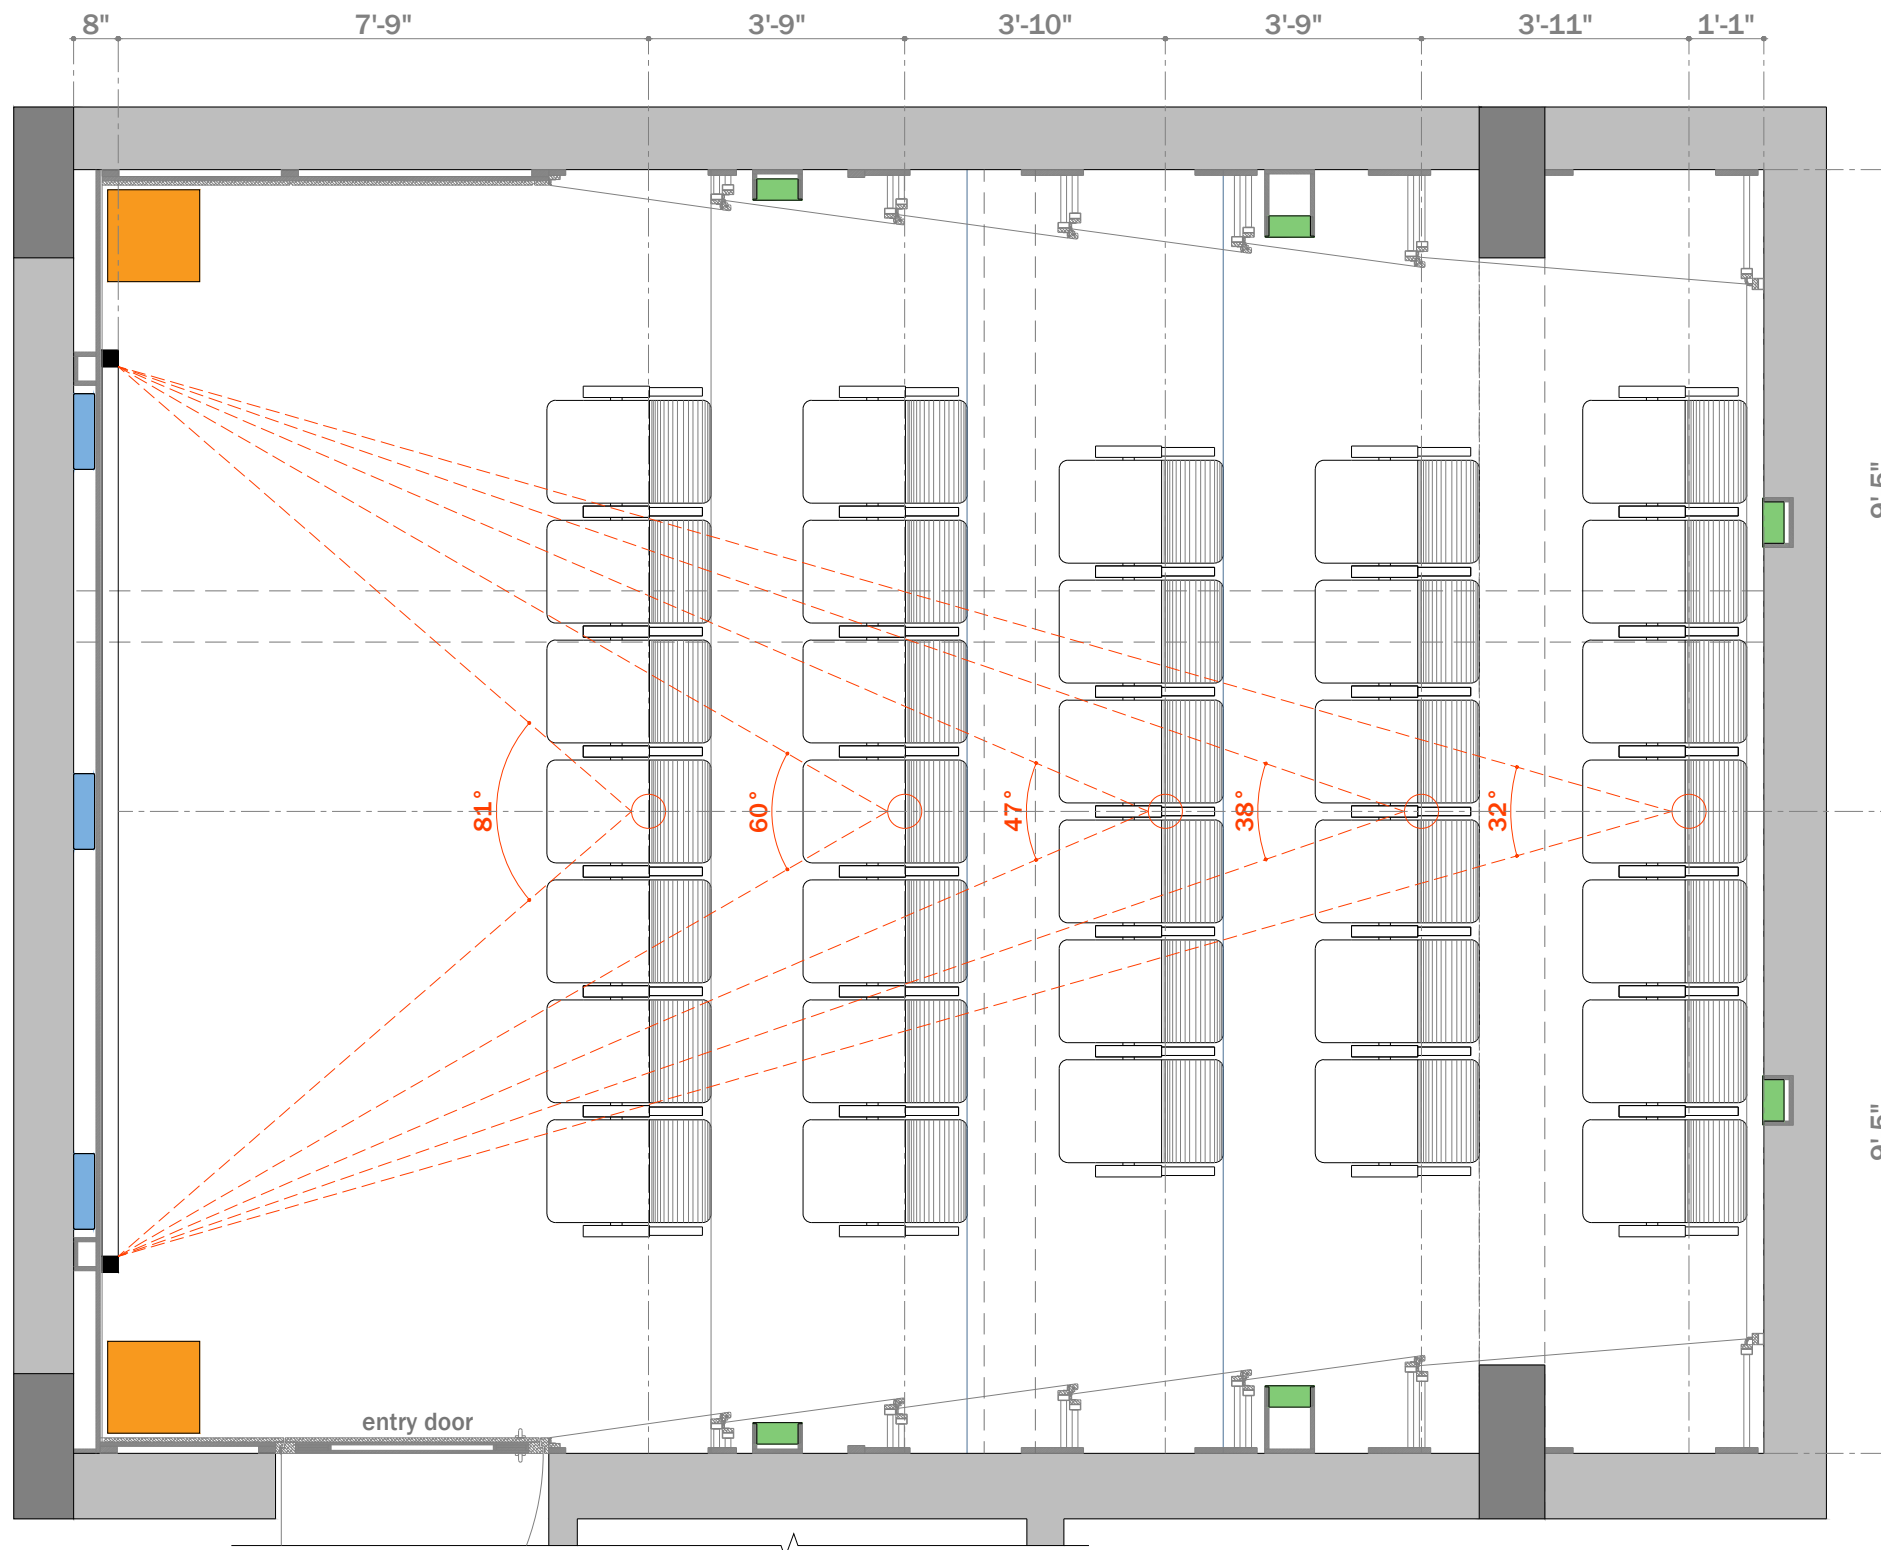

AUDIO VIDEO SYMBOLS		
SYMBOL	NAME	DO=DEVICE OPTIONS
	SPEAKER	LCR-LCR BAR SU-SUBWOOFER ST-STEREO
	VIDEO PROJECTOR	LCD-LIQUID CRYSTAL DISPLAY DLP-DIGITAL LIGHT PROCESSOR SXRD-SILICON X-TEL REF. DISP.
	PROJECTON SCREEN	F-FIXED M-MOTORISED

COMMUNICATIONS SYMBOLS		
SYMBOL	NAME	DO=DEVICE OPTIONS
	PHONE AND DATA PORT	D-DATA F-FIBRE OPTIC P-PHONE
	INCOMING SERVICES	CTV-CABLE TV P-PHONE S-SATELLITE
	RF REPEATER ACCESS POINT	CR-CELLUAR PR-PHONE WAP-WIRELESSACCESS POINT

FURNISHINGS SYMBOLS		
SYMBOL	NAME	DO=DEVICE OPTIONS
	RACK OR HEAD END	AV-AUDIO/VIDEO C-CONTROL D-DATA SEC-SECURITY
	LIFT/MOUNT	A-ARTICULATED M-MOTORISED UB-UNDER BED

EXAMPLES: SYMBOL + MOUNTING OPTION		
SYMBOL	NAME	MOUNT TYPE
	SPEAKER	CEILING MOUNTED
	SPEAKER	WALL MOUNTED
	SPEAKER	FLOOR MOUNTED
	PRE-WIRE SPEAKER	CEILING MOUNTED PRE-WIRE ONLY NO CUTOUT

CABLING OPTIONS			
	SPKR	2CX2.5 mm²	SPEAKER CABLE
	COXL	COAXIAL	SUBWOOFER CABLE
	CAT6	CAT6	DATA CABLE
	HDMI	HDMI	VIDEO CABLE

Client : CLINICAL RETREAT

Location : ANAND

Created 06-06-2017
 Modified Not yet
 Printed Not yet

Drawing Name : AV FLOOR PLAN

Drawing Type : VIEWING ANGLES

Drawing Scale : SCALE TO FIT

Designed by Ruchi

Checked by Ankur Bhatt

HC-052/1.5

1 VIEWING ANGLES

SCALE: TO FIT



AUDIO VIDEO SYMBOLS		
SYMBOL	NAME	DO=DEVICE OPTIONS
	SPEAKER	LCR-LCR BAR SU-SUBWOOFER ST-STEREO
	VIDEO PROJECTOR	LCD-LIQUID CRYSTAL DISPLAY DLP-DIGITAL LIGHT PROCESSOR SXRD-SILICON X-TEL REF. DISP.
	PROJECTON SCREEN	F-FIXED M-MOTORISED

COMMUNICATIONS SYMBOLS		
SYMBOL	NAME	DO=DEVICE OPTIONS
	PHONE AND DATA PORT	D-DATA F-FIBRE OPTIC P-PHONE
	INCOMING SERVICES	CTV-CABLE TV P-PHONE S-SATELLITE
	RF REPEATER ACCESS POINT	CR-CELLUAR PR-PHONE WAP-WIRELESSACCESS POINT

FURNISHINGS SYMBOLS		
SYMBOL	NAME	DO=DEVICE OPTIONS
	RACK OR HEAD END	AV-AUDIO/VIDEO C-CONTROL D-DATA SEC-SECURITY
	LIFT/MOUNT	A-ARTICULATED M-MOTORISED UB-UNDER BED

EXAMPLES: SYMBOL + MOUNTING OPTION		
SYMBOL	NAME	MOUNT TYPE
	SPEAKER	CEILING MOUNTED
	SPEAKER	WALL MOUNTED
	SPEAKER	FLOOR MOUNTED
	PRE-WIRE SPEAKER	CEILING MOUNTED PRE-WIRE ONLY NO CUTOUT

CABLING OPTIONS			
	SPKR	2CX2.5 mm ²	SPEAKER CABLE
	COXL	COAXIAL	SUBWOOFER CABLE
	CAT6	CAT6	DATA CABLE
	HDMI	HDMI	VIDEO CABLE

Client : CLINICAL RETREAT

Location : ANAND

Created 06-06-2017
 Modified Not yet
 Printed Not yet

Drawing Name :
 AV FLOOR PLAN

Drawing Type :
 SEATING PLACEMENT

Drawing Scale : SCALE TO FIT


Designed by Ruchi

Checked by Ankur Bhatt

HC-052/1.6

1 SEATING PLACEMENT

SCALE: TO FIT

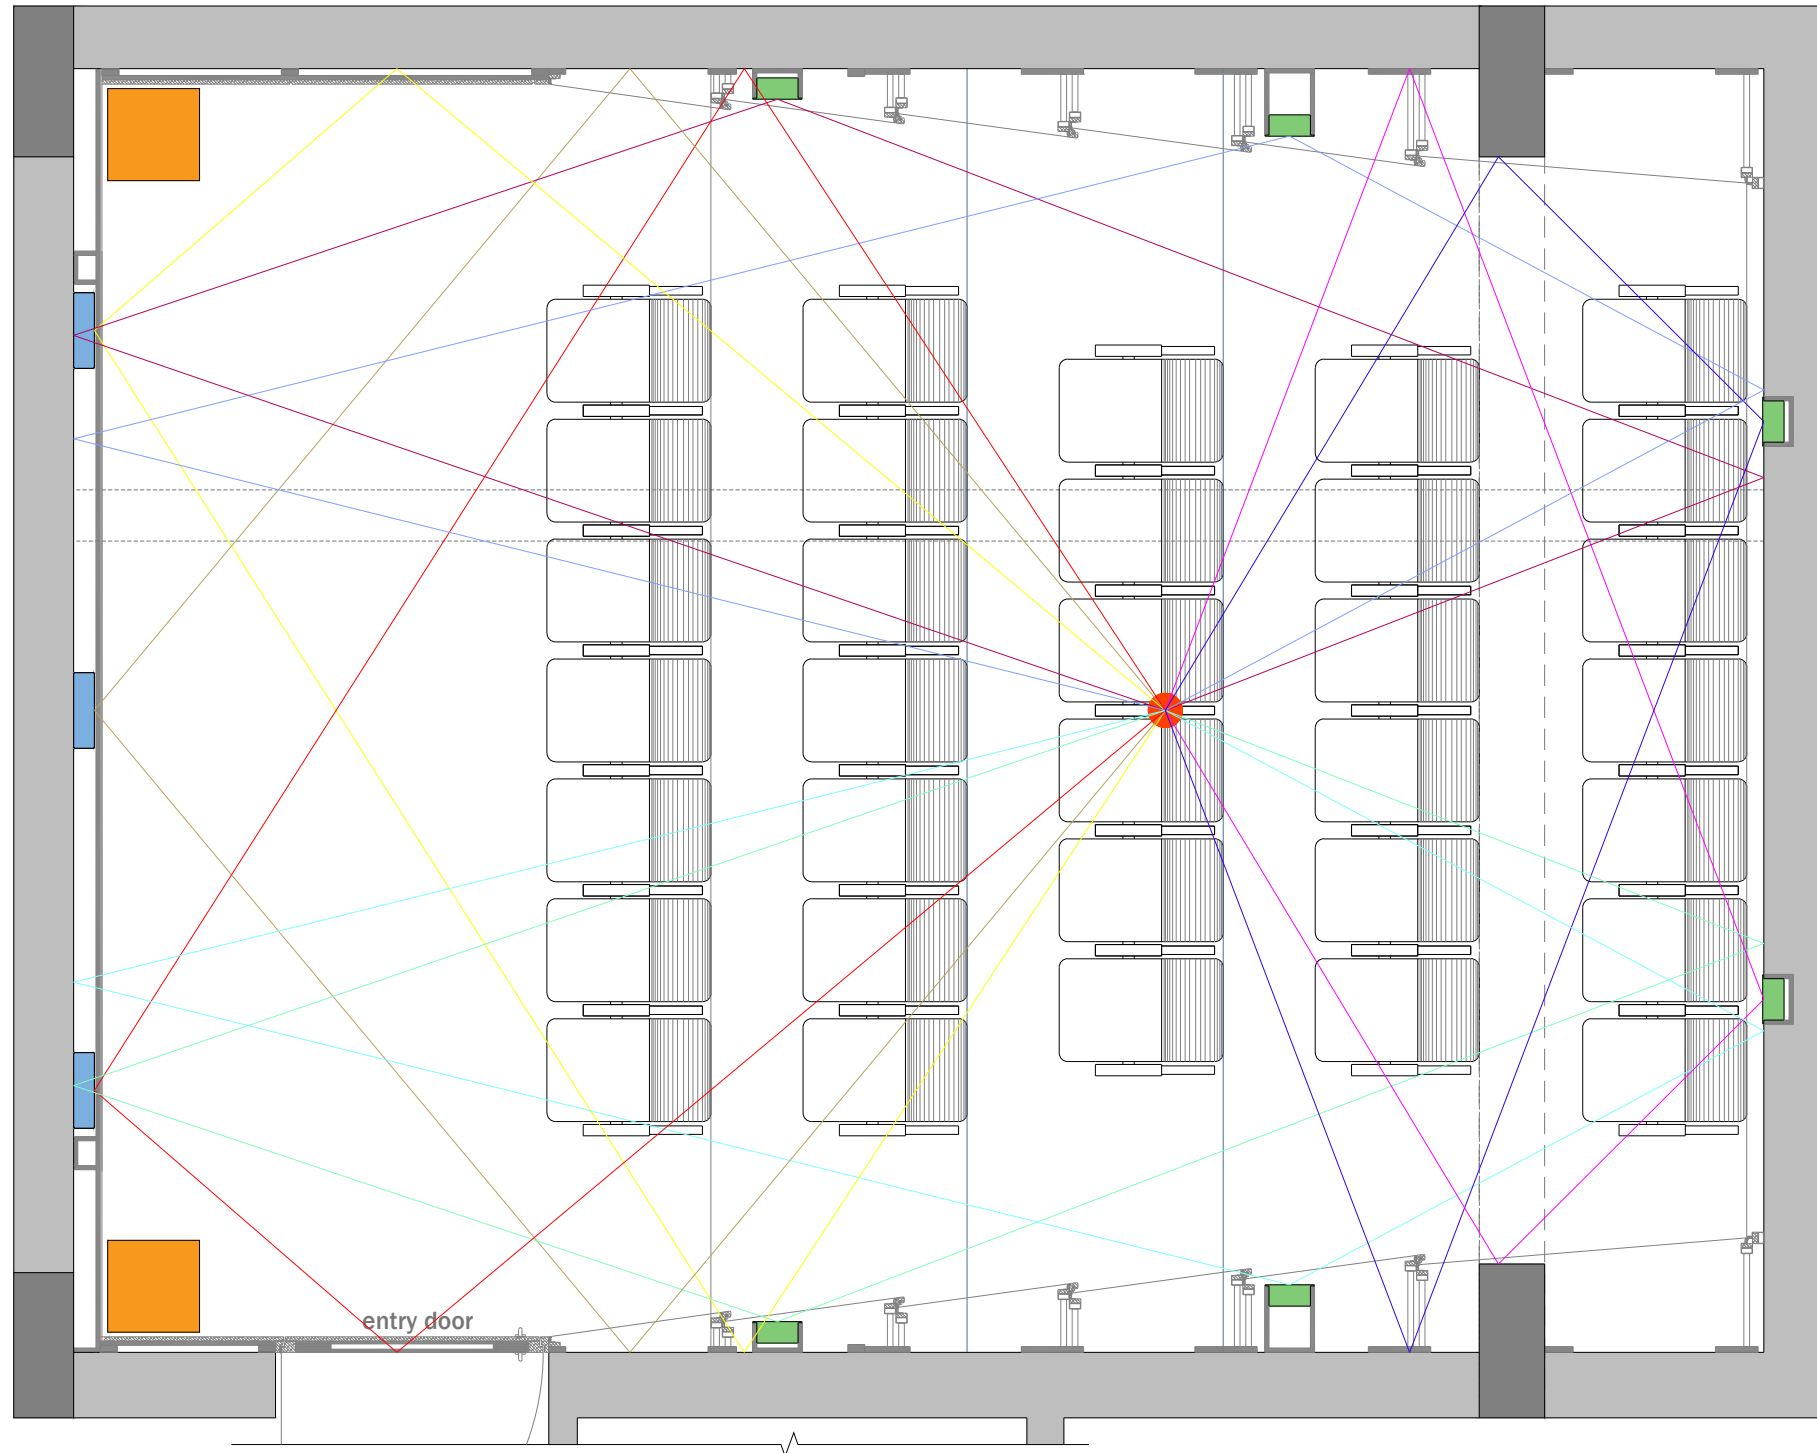

AUDIO VIDEO SYMBOLS		
SYMBOL	NAME	DO=DEVICE OPTIONS
	SPEAKER	LCR-LCR BAR SU-SUBWOOFER ST-STEREO
	VIDEO PROJECTOR	LCD-LIQUID CRYSTAL DISPLAY DLP-DIGITAL LIGHT PROCESSOR SXRD-SILICON X-TEL REF. DISP.
	PROJECTON SCREEN	F-FIXED M-MOTORISED

COMMUNICATIONS SYMBOLS		
SYMBOL	NAME	DO=DEVICE OPTIONS
	PHONE AND DATA PORT	D-DATA F-FIBRE OPTIC P-PHONE
	INCOMING SERVICES	CTV-CABLE TV P-PHONE S-SATELLITE
	RF REPEATER ACCESS POINT	CR-CELLUAR PR-PHONE WAP-WIRELESSACCESS POINT

FURNISHINGS SYMBOLS		
SYMBOL	NAME	DO=DEVICE OPTIONS
	RACK OR HEAD END	AV-AUDIO/VIDEO C-CONTROL D-DATA SEC-SECURITY
	LIFT/MOUNT	A-ARTICULATED M-MOTORISED UB-UNDER BED

EXAMPLES: SYMBOL + MOUNTING OPTION		
SYMBOL	NAME	MOUNT TYPE
	SPEAKER	CEILING MOUNTED
	SPEAKER	WALL MOUNTED
	SPEAKER	FLOOR MOUNTED
	PRE-WIRE SPEAKER	CEILING MOUNTED PRE-WIRE ONLY NO CUTOUT

CABLING OPTIONS			
	SPKR	2CX2.5 mm ²	SPEAKER CABLE
	COXL	COAXIAL	SUBWOOFER CABLE
	CAT6	CAT6	DATA CABLE
	HDMI	HDMI	VIDEO CABLE

Client : CLINICAL RETREAT

Location : ANAND

Created 06-06-2017
 Modified Not yet
 Printed Not yet

Drawing Name :
 AV FLOOR PLAN

Drawing Type :
 SPEAKER REFLECTIONS

Drawing Scale : SCALE TO FIT


Designed by Ruchi

Checked by Ankur Bhatt

HC-052/1.7

1 SPEAKER REFLECTIONS

SCALE: TO FIT

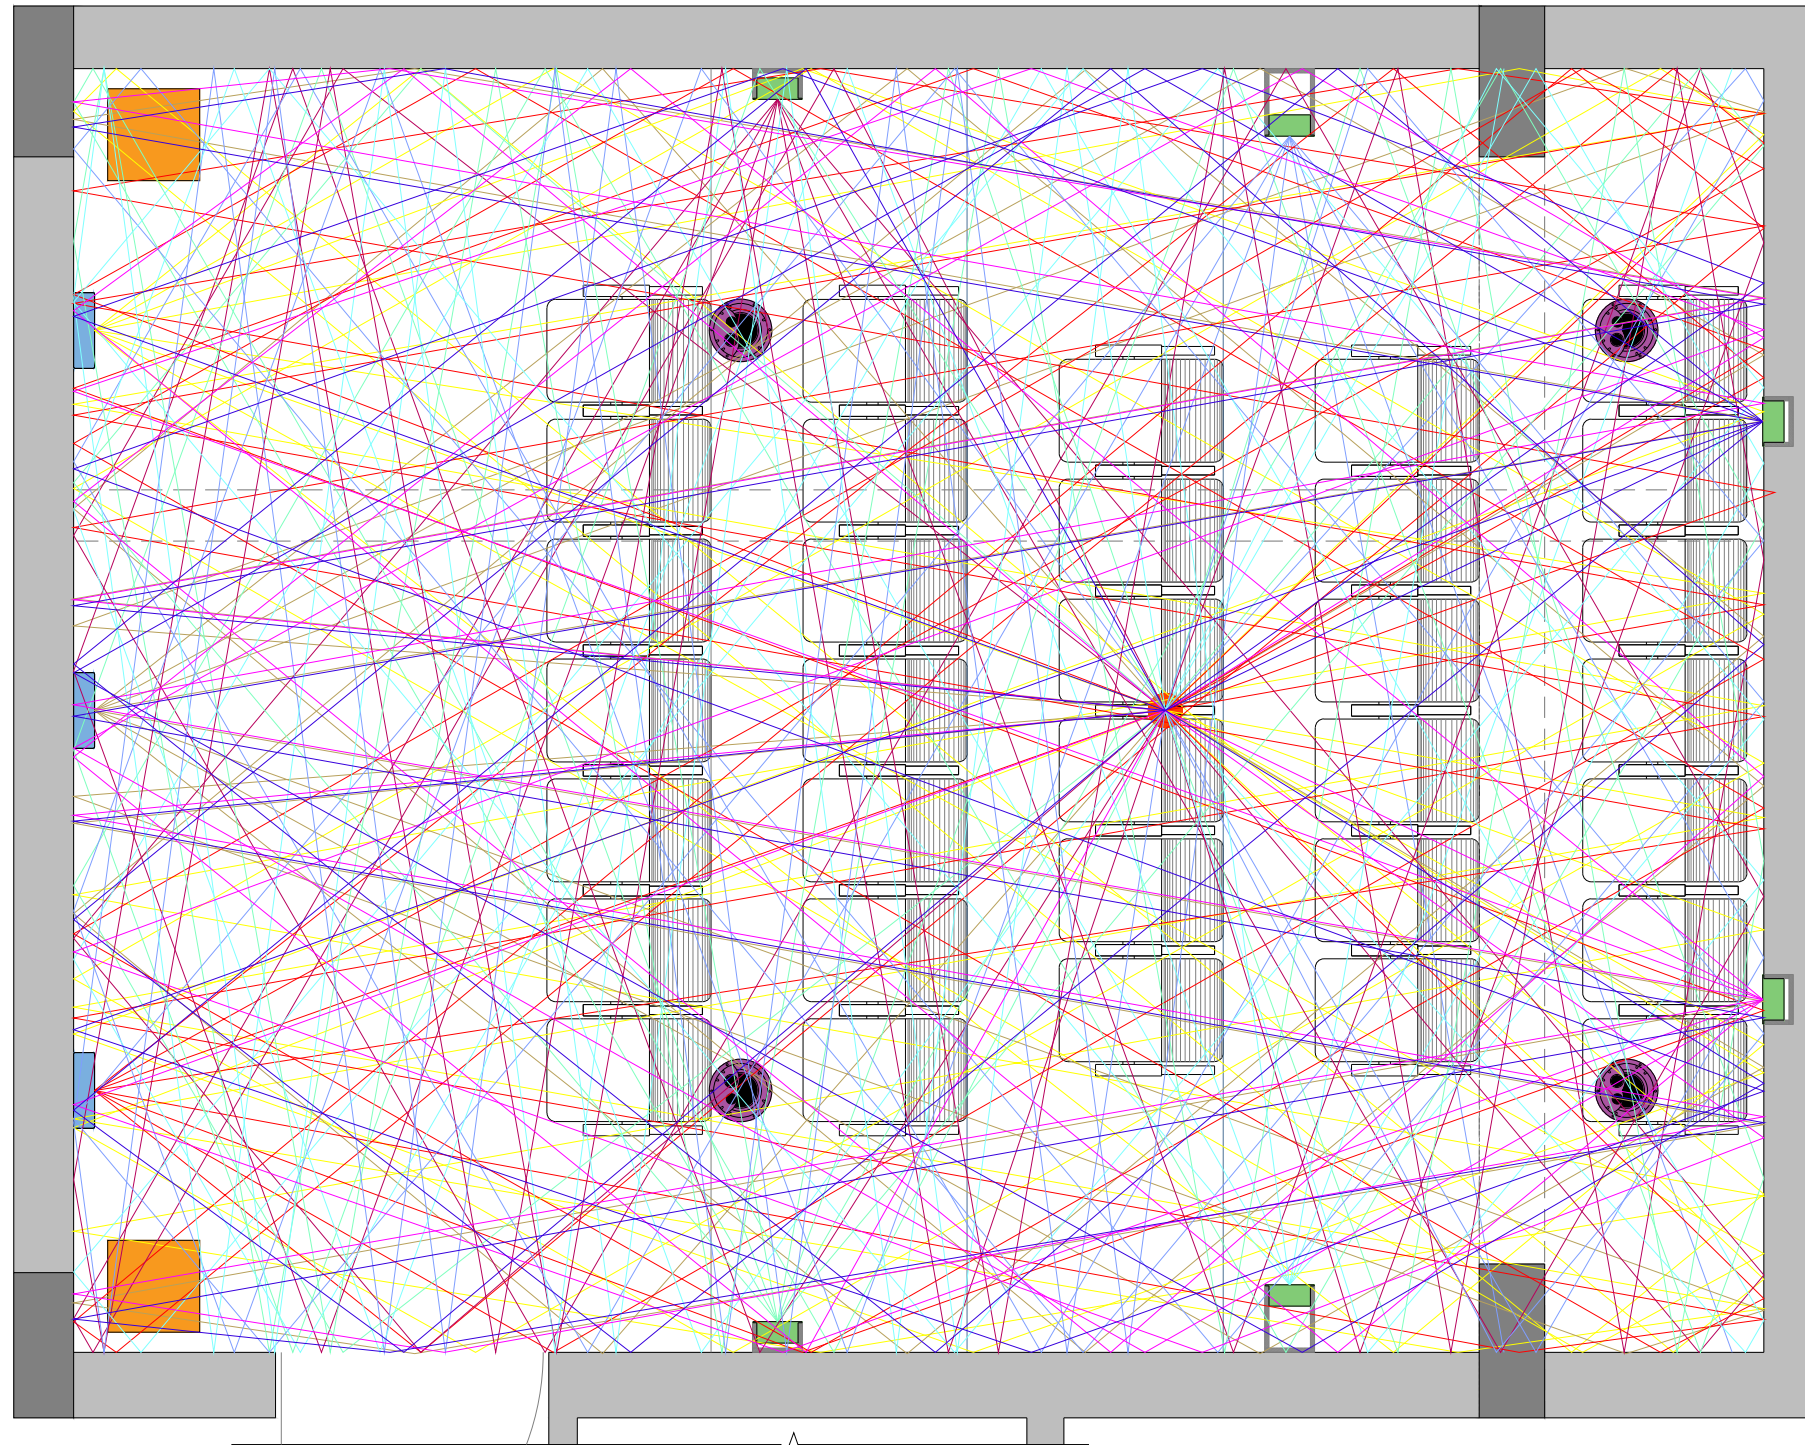

AUDIO VIDEO SYMBOLS		
SYMBOL	NAME	DO=DEVICE OPTIONS
	SPEAKER	LCR-LCR BAR SU-SUBWOOFER ST-STEREO
	VIDEO PROJECTOR	LCD-LIQUID CRYSTAL DISPLAY DLP-DIGITAL LIGHT PROCESSOR SXRD-SILICON X-TEL REF. DISP.
	PROJECTON SCREEN	F-FIXED M-MOTORISED

COMMUNICATIONS SYMBOLS		
SYMBOL	NAME	DO=DEVICE OPTIONS
	PHONE AND DATA PORT	D-DATA F-FIBRE OPTIC P-PHONE
	INCOMING SERVICES	CTV-CABLE TV P-PHONE S-SATELLITE
	RF REPEATER ACCESS POINT	CR-CELLUAR PR-PHONE WAP-WIRELESSACCESS POINT

FURNISHINGS SYMBOLS		
SYMBOL	NAME	DO=DEVICE OPTIONS
	RACK OR HEAD END	AV-AUDIO/VIDEO C-CONTROL D-DATA SEC-SECURITY
	LIFT/MOUNT	A-ARTICULATED M-MOTORISED UB-UNDER BED

EXAMPLES: SYMBOL + MOUNTING OPTION		
SYMBOL	NAME	MOUNT TYPE
	SPEAKER	CEILING MOUNTED
	SPEAKER	WALL MOUNTED
	SPEAKER	FLOOR MOUNTED
	PRE-WIRE SPEAKER	CEILING MOUNTED PRE-WIRE ONLY NO CUTOUT

CABLING OPTIONS			
	SPKR	2CX2.5 mm ²	SPEAKER CABLE
	COXL	COAXIAL	SUBWOOFER CABLE
	CAT6	CAT6	DATA CABLE
	HDMI	HDMI	VIDEO CABLE

Client : CLINICAL RETREAT

Location : ANAND

Created 06-06-2017
 Modified Not yet
 Printed Not yet

Drawing Name :
 AV FLOOR PLAN

Drawing Type :
 SPEAKER REFLECTIONS

Drawing Scale : SCALE TO FIT


Designed by Ruchi

Checked by Ankur Bhatt


HC-052/1.8

1 SPEAKER REFLECTIONS


SCALE: TO FIT

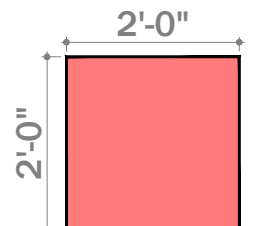

96 kg Density
4" fiber glass

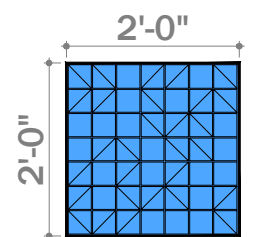

Diffusion

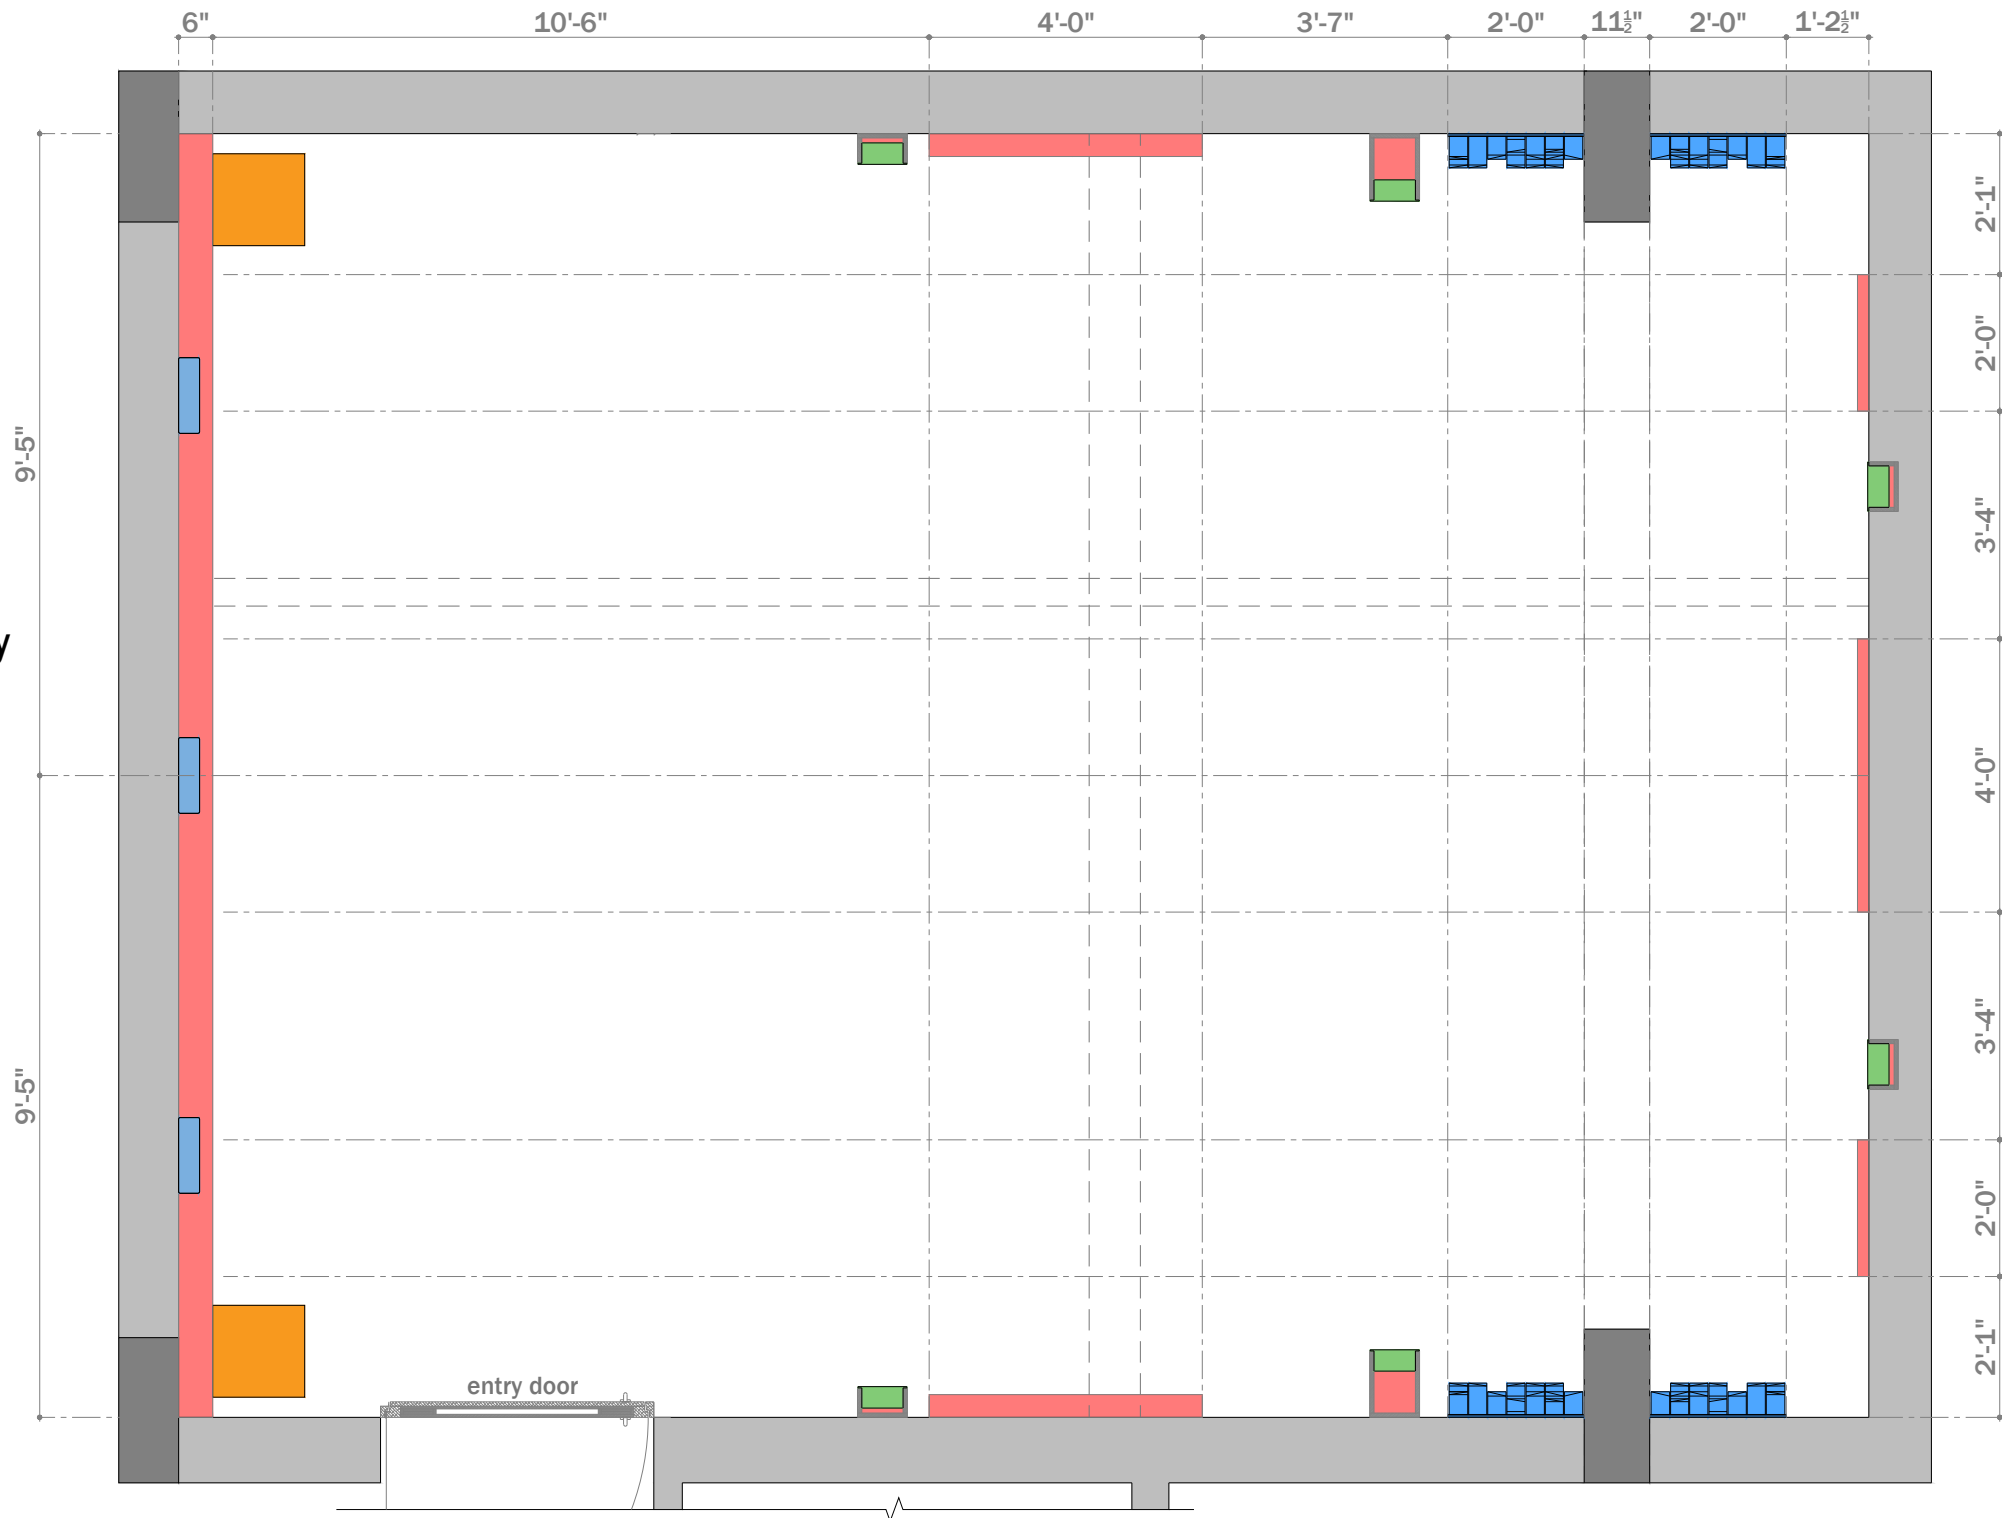

AUDIO VIDEO SYMBOLS		
SYMBOL	NAME	DO=DEVICE OPTIONS
	SPEAKER	LCR-LCR BAR SU-SUBWOOFER ST-STEREO
	VIDEO PROJECTOR	LCD-LIQUID CRYSTAL DISPLAY DLP-DIGITAL LIGHT PROCESSOR SXRD-SILICON X-TEL REF. DISP.
	PROJECTON SCREEN	F-FIXED M-MOTORISED

COMMUNICATIONS SYMBOLS		
SYMBOL	NAME	DO=DEVICE OPTIONS
	PHONE AND DATA PORT	D-DATA F-FIBRE OPTIC P-PHONE
	INCOMING SERVICES	CTV-CABLE TV P-PHONE S-SATELLITE
	RF REPEATER ACCESS POINT	CR-CELLUAR PR-PHONE WAP-WIRELESSACCESS POINT

FURNISHINGS SYMBOLS		
SYMBOL	NAME	DO=DEVICE OPTIONS
	RACK OR HEAD END	AV-AUDIO/VIDEO C-CONTROL D-DATA SEC-SECURITY
	LIFT/MOUNT	A-ARTICULATED M-MOTORISED UB-UNDER BED

EXAMPLES: SYMBOL + MOUNTING OPTION		
SYMBOL	NAME	MOUNT TYPE
	SPEAKER	CEILING MOUNTED
	SPEAKER	WALL MOUNTED
	SPEAKER	FLOOR MOUNTED
	PRE-WIRE SPEAKER	CEILING MOUNTED PRE-WIRE ONLY NO CUTOUT

CABLING OPTIONS			
	SPKR	2CX2.5 mm ²	SPEAKER CABLE
	COXL	COAXIAL	SUBWOOFER CABLE
	CAT6	CAT6	DATA CABLE
	HDMI	HDMI	VIDEO CABLE

Client : CLINICAL RETREAT

Location : ANAND

Created 06-06-2017
Modified Not yet
Printed Not yet

Drawing Name :
AV ROOM LAYOUT


Drawing Type :
ACOUSTICS

Drawing Scale : SCALE TO FIT

Designed by Ruchi

Checked by Ankur Bhatt

HC-052/1.9

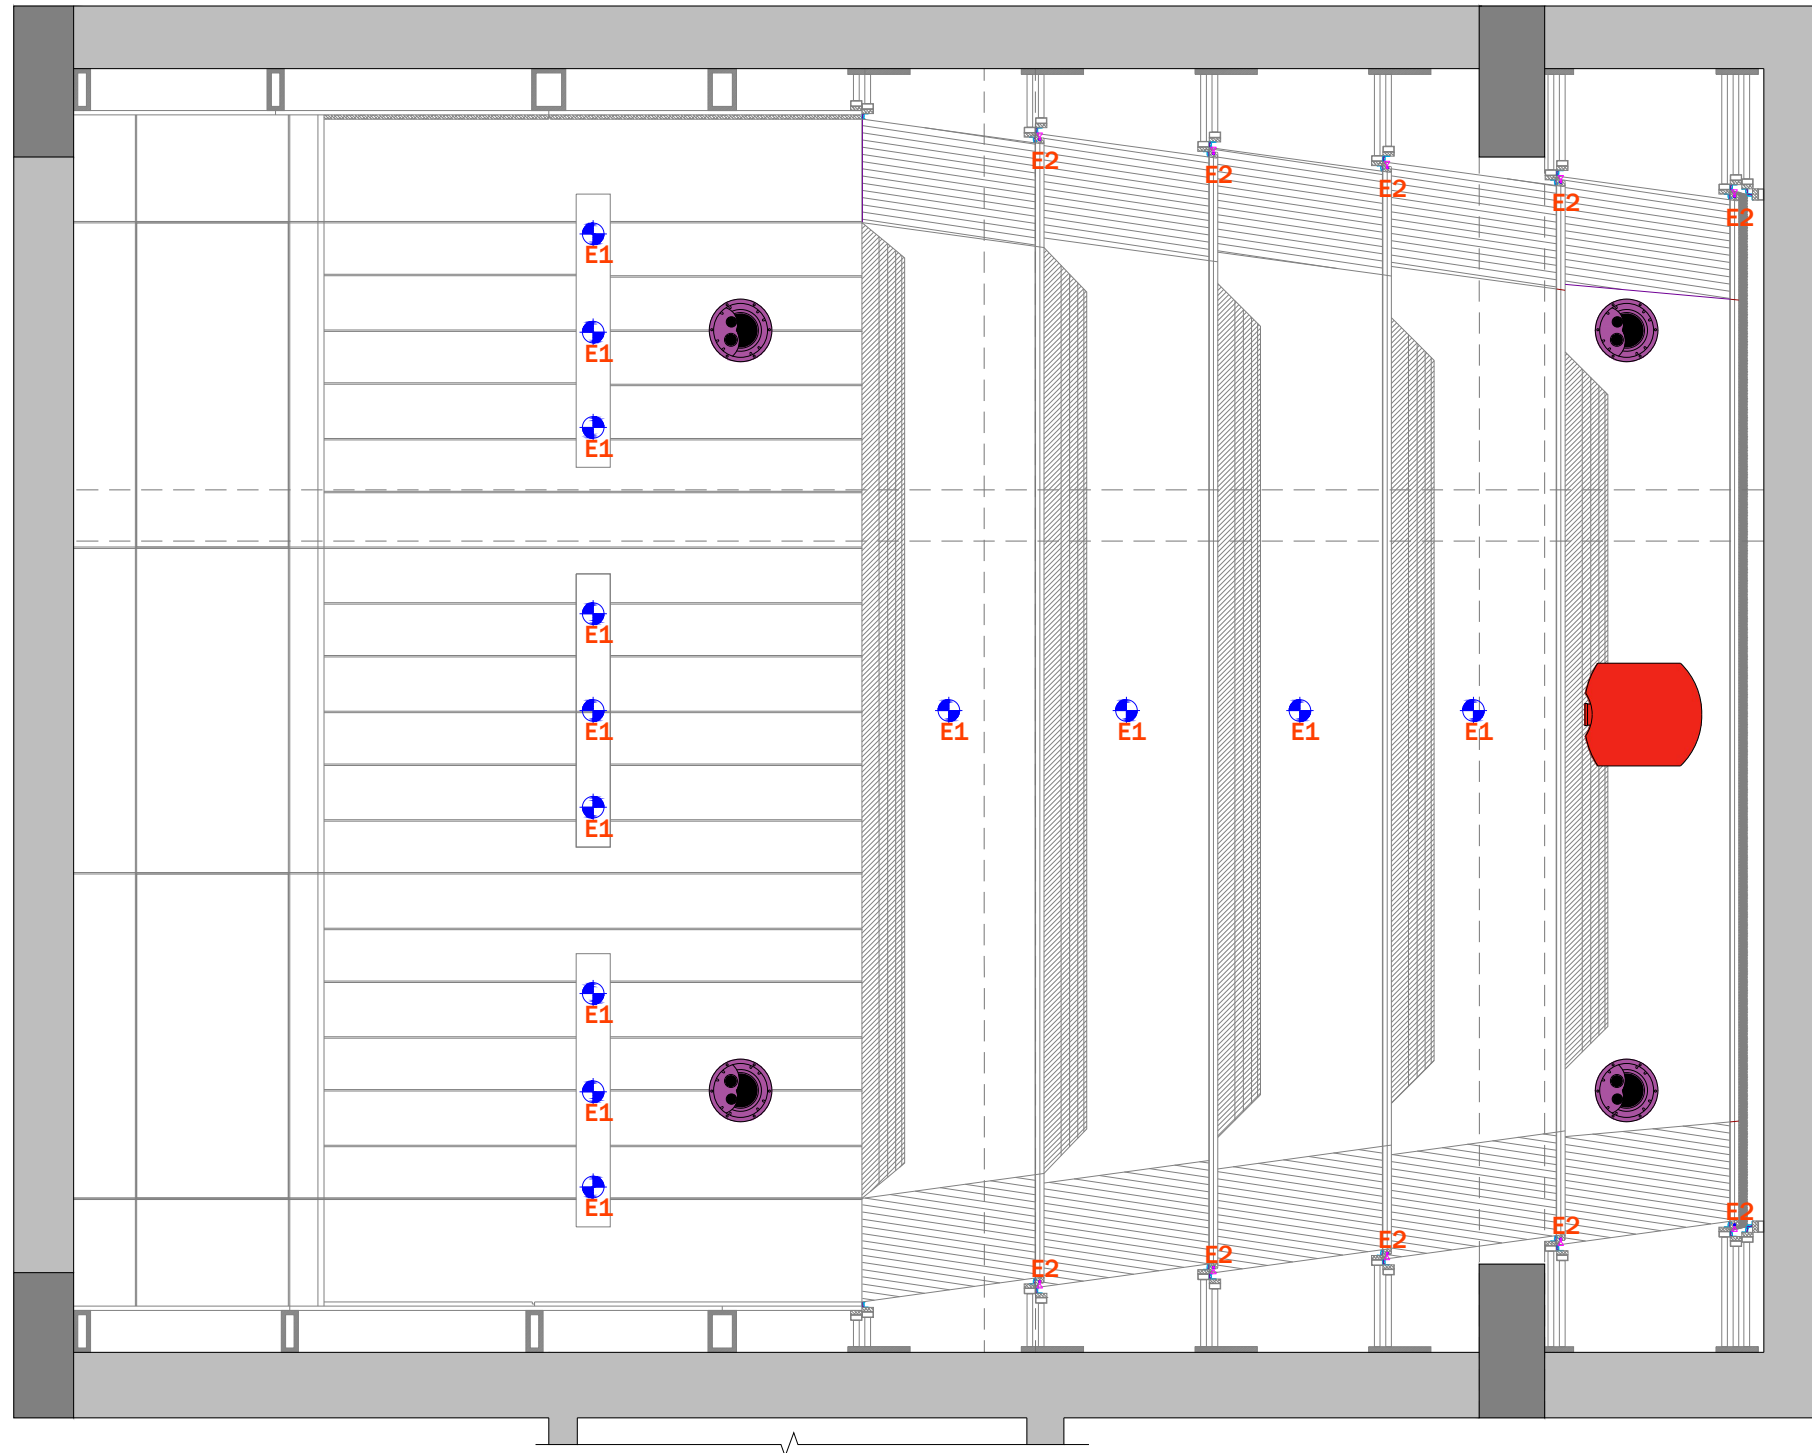

AUDIO VIDEO SYMBOLS		
SYMBOL	NAME	DO=DEVICE OPTIONS
	SPEAKER	LCR-LCR BAR SU-SUBWOOFER ST-STEREO
	VIDEO PROJECTOR	LCD-LIQUID CRYSTAL DISPLAY DLP-DIGITAL LIGHT PROCESSOR SXRD-SILICON X-TEL REF. DISP.
	PROJECTON SCREEN	F-FIXED M-MOTORISED

COMMUNICATIONS SYMBOLS		
SYMBOL	NAME	DO=DEVICE OPTIONS
	PHONE AND DATA PORT	D-DATA F-FIBRE OPTIC P-PHONE
	INCOMING SERVICES	CTV-CABLE TV P-PHONE S-SATELLITE
	RF REPEATER ACCESS POINT	CR-CELLUAR PR-PHONE WAP-WIRELESSACCESS POINT

FURNISHINGS SYMBOLS		
SYMBOL	NAME	DO=DEVICE OPTIONS
	RACK OR HEAD END	AV-AUDIO/VIDEO C-CONTROL D-DATA SEC-SECURITY
	LIFT/MOUNT	A-ARTICULATED M-MOTORISED UB-UNDER BED

EXAMPLES: SYMBOL + MOUNTING OPTION		
SYMBOL	NAME	MOUNT TYPE
	SPEAKER	CEILING MOUNTED
	SPEAKER	WALL MOUNTED
	SPEAKER	FLOOR MOUNTED
	PRE-WIRE SPEAKER	CEILING MOUNTED PRE-WIRE ONLY NO CUTOUT

CABLING OPTIONS			
	SPKR	2CX2.5 mm²	SPEAKER CABLE
	COXL	COAXIAL	SUBWOOFER CABLE
	CAT6	CAT6	DATA CABLE
	HDMI	HDMI	VIDEO CABLE

Client : CLINICAL RETREAT

Location : ANAND

Created 06-06-2017
 Modified Not yet
 Printed Not yet

Drawing Name :
 CEILING PLAN


Drawing Type :
 LIGHTING POSITION

Drawing Scale : SCALE TO FIT

Designed by Ruchi

Checked by Ankur Bhatt

HC-052/2

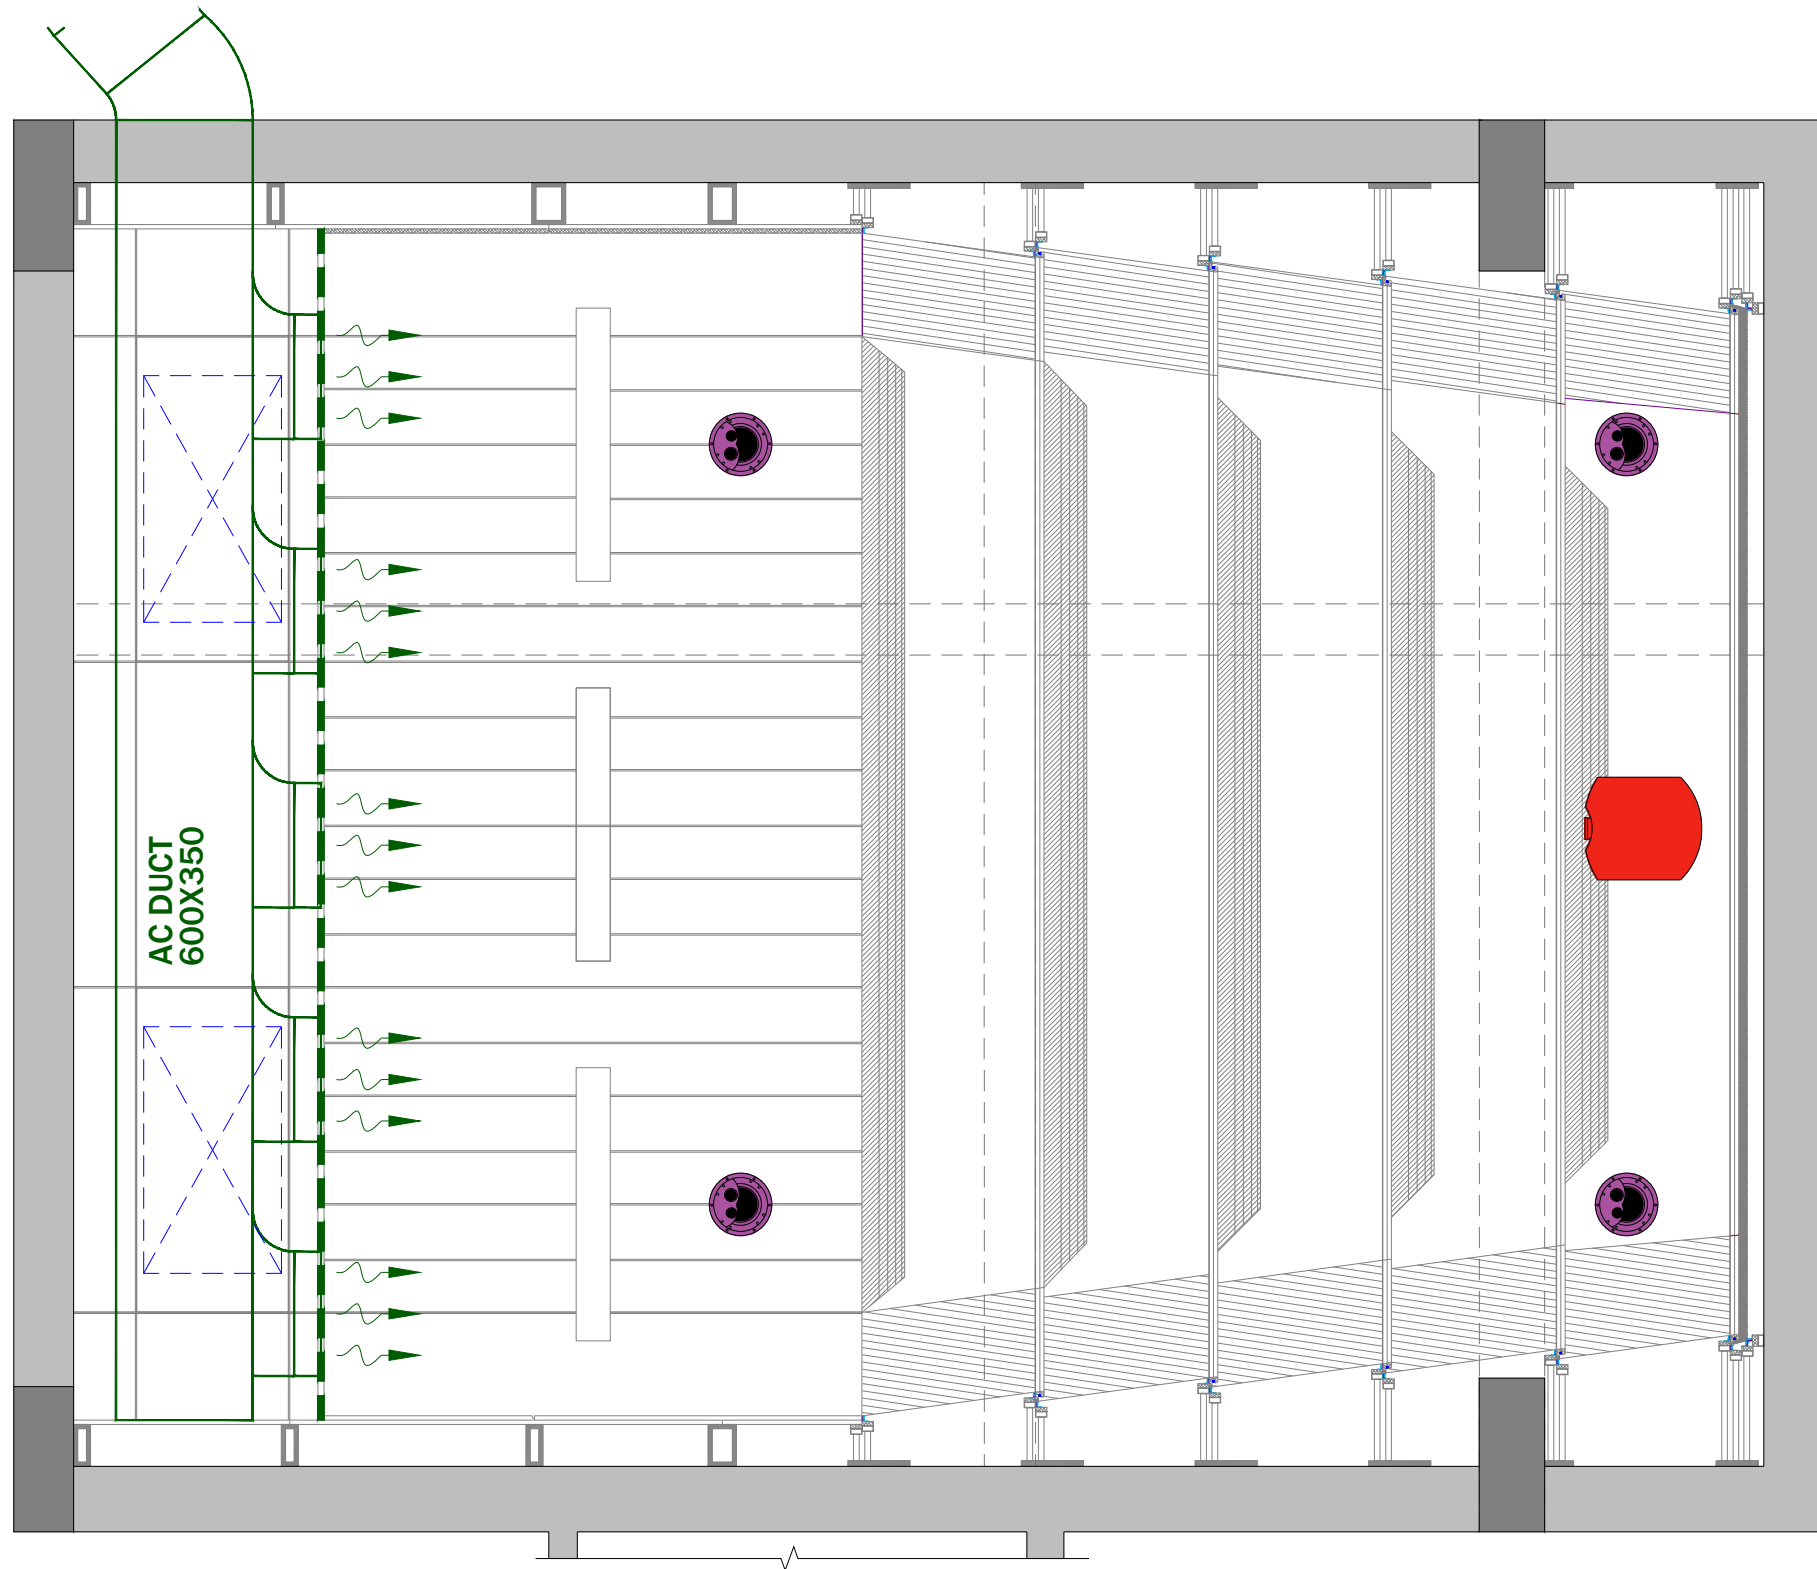

AUDIO VIDEO SYMBOLS		
SYMBOL	NAME	DO=DEVICE OPTIONS
	SPEAKER	LCR-LCR BAR SU-SUBWOOFER ST-STEREO
	VIDEO PROJECTOR	LCD-LIQUID CRYSTAL DISPLAY DLP-DIGITAL LIGHT PROCESSOR SXRD-SILICON X-TEL REF. DISP.
	PROJECTON SCREEN	F-FIXED M-MOTORISED

COMMUNICATIONS SYMBOLS		
SYMBOL	NAME	DO=DEVICE OPTIONS
	PHONE AND DATA PORT	D-DATA F-FIBRE OPTIC P-PHONE
	INCOMING SERVICES	CTV-CABLE TV P-PHONE S-SATELLITE
	RF REPEATER ACCESS POINT	CR-CELLUAR PR-PHONE WAP-WIRELESSACCESS POINT

FURNISHINGS SYMBOLS		
SYMBOL	NAME	DO=DEVICE OPTIONS
	RACK OR HEAD END	AV-AUDIO/VIDEO C-CONTROL D-DATA SEC-SECURITY
	LIFT/MOUNT	A-ARTICULATED M-MOTORISED UB-UNDER BED

EXAMPLES: SYMBOL + MOUNTING OPTION		
SYMBOL	NAME	MOUNT TYPE
	SPEAKER	CEILING MOUNTED
	SPEAKER	WALL MOUNTED
	SPEAKER	FLOOR MOUNTED
	PRE-WIRE SPEAKER	CEILING MOUNTED PRE-WIRE ONLY NO CUTOUT

CABLING OPTIONS			
	SPKR	2CX2.5 mm ²	SPEAKER CABLE
	COXL	COAXIAL	SUBWOOFER CABLE
	CAT6	CAT6	DATA CABLE
	HDMI	HDMI	VIDEO CABLE

Client : CLINICAL RETREAT

Location : ANAND

Created 06-06-2017
 Modified Not yet
 Printed Not yet

Drawing Name :
 CEILING PLAN


Drawing Type :
 HVAC POSITION

Drawing Scale : SCALE TO FIT

Designed by Ruchi

Checked by Ankur Bhatt

HC-052/2.1

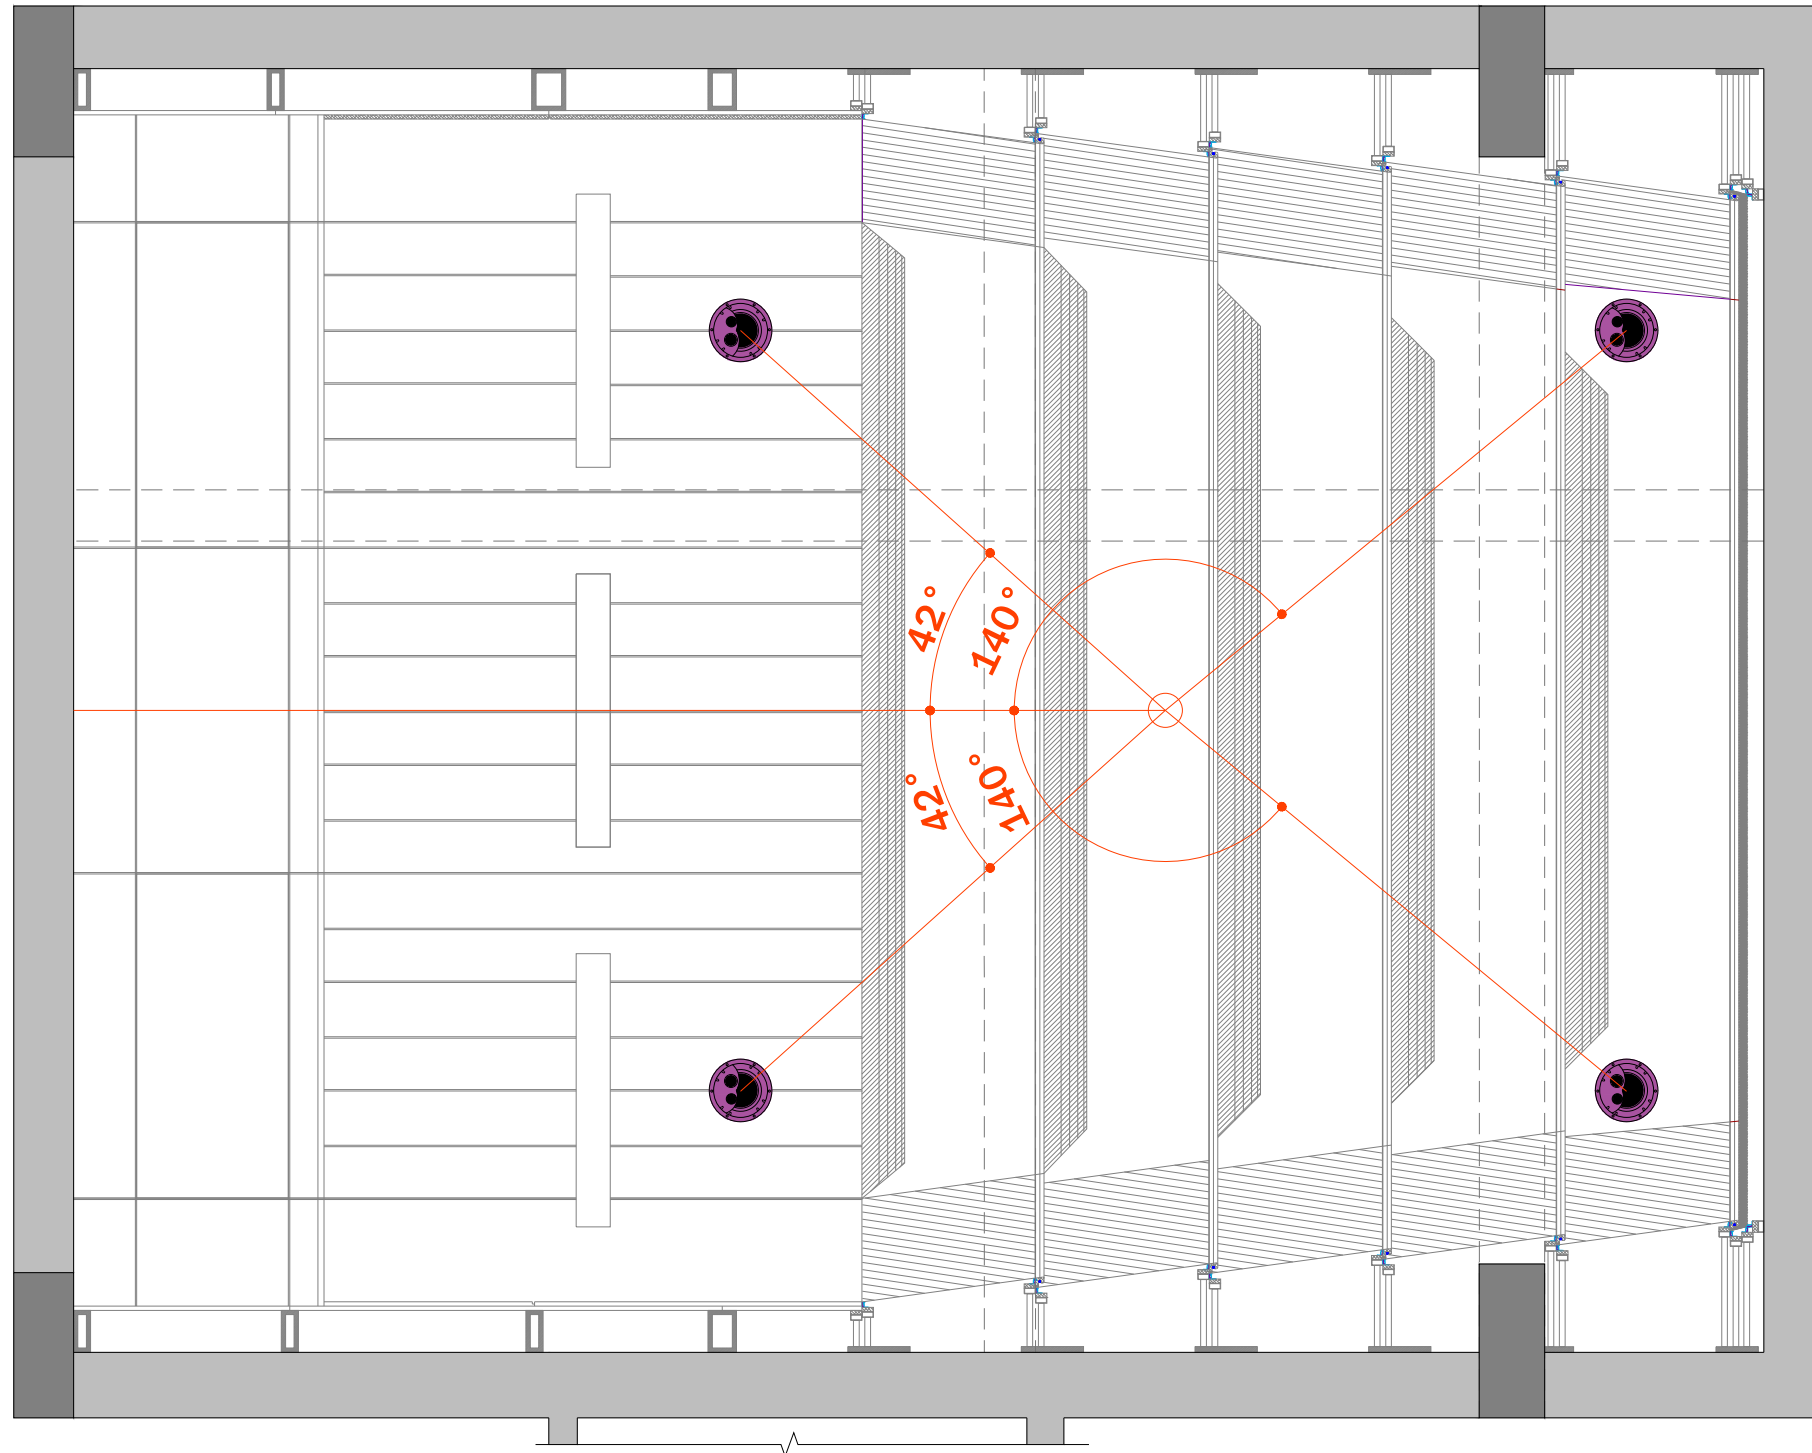

AUDIO VIDEO SYMBOLS		
SYMBOL	NAME	DO=DEVICE OPTIONS
	SPEAKER	LCR-LCR BAR SU-SUBWOOFER ST-STEREO
	VIDEO PROJECTOR	LCD-LIQUID CRYSTAL DISPLAY DLP-DIGITAL LIGHT PROCESSOR SXRD-SILICON X-TEL REF. DISP.
	PROJECTON SCREEN	F-FIXED M-MOTORISED

COMMUNICATIONS SYMBOLS		
SYMBOL	NAME	DO=DEVICE OPTIONS
	PHONE AND DATA PORT	D-DATA F-FIBRE OPTIC P-PHONE
	INCOMING SERVICES	CTV-CABLE TV P-PHONE S-SATELLITE
	RF REPEATER ACCESS POINT	CR-CELLUAR PR-PHONE WAP-WIRELESSACCESS POINT

FURNISHINGS SYMBOLS		
SYMBOL	NAME	DO=DEVICE OPTIONS
	RACK OR HEAD END	AV-AUDIO/VIDEO C-CONTROL D-DATA SEC-SECURITY
	LIFT/MOUNT	A-ARTICULATED M-MOTORISED UB-UNDER BED

EXAMPLES: SYMBOL + MOUNTING OPTION		
SYMBOL	NAME	MOUNT TYPE
	SPEAKER	CEILING MOUNTED
	SPEAKER	WALL MOUNTED
	SPEAKER	FLOOR MOUNTED
	PRE-WIRE SPEAKER	CEILING MOUNTED PRE-WIRE ONLY NO CUTOUT

CABLING OPTIONS			
	SPKR	2CX2.5 mm ²	SPEAKER CABLE
	COXL	COAXIAL	SUBWOOFER CABLE
	CAT6	CAT6	DATA CABLE
	HDMI	HDMI	VIDEO CABLE

Client : CLINICAL RETREAT

Location : ANAND

Created 06-06-2017
 Modified Not yet
 Printed Not yet

Drawing Name :
 CEILING PLAN

Drawing Type :
 SPEAKER PLACEMENT

Drawing Scale : SCALE TO FIT


Designed by Ruchi

Checked by Ankur Bhatt

HC-052/2.2

2 SPEAKER PLACEMENT

SCALE: TO FIT

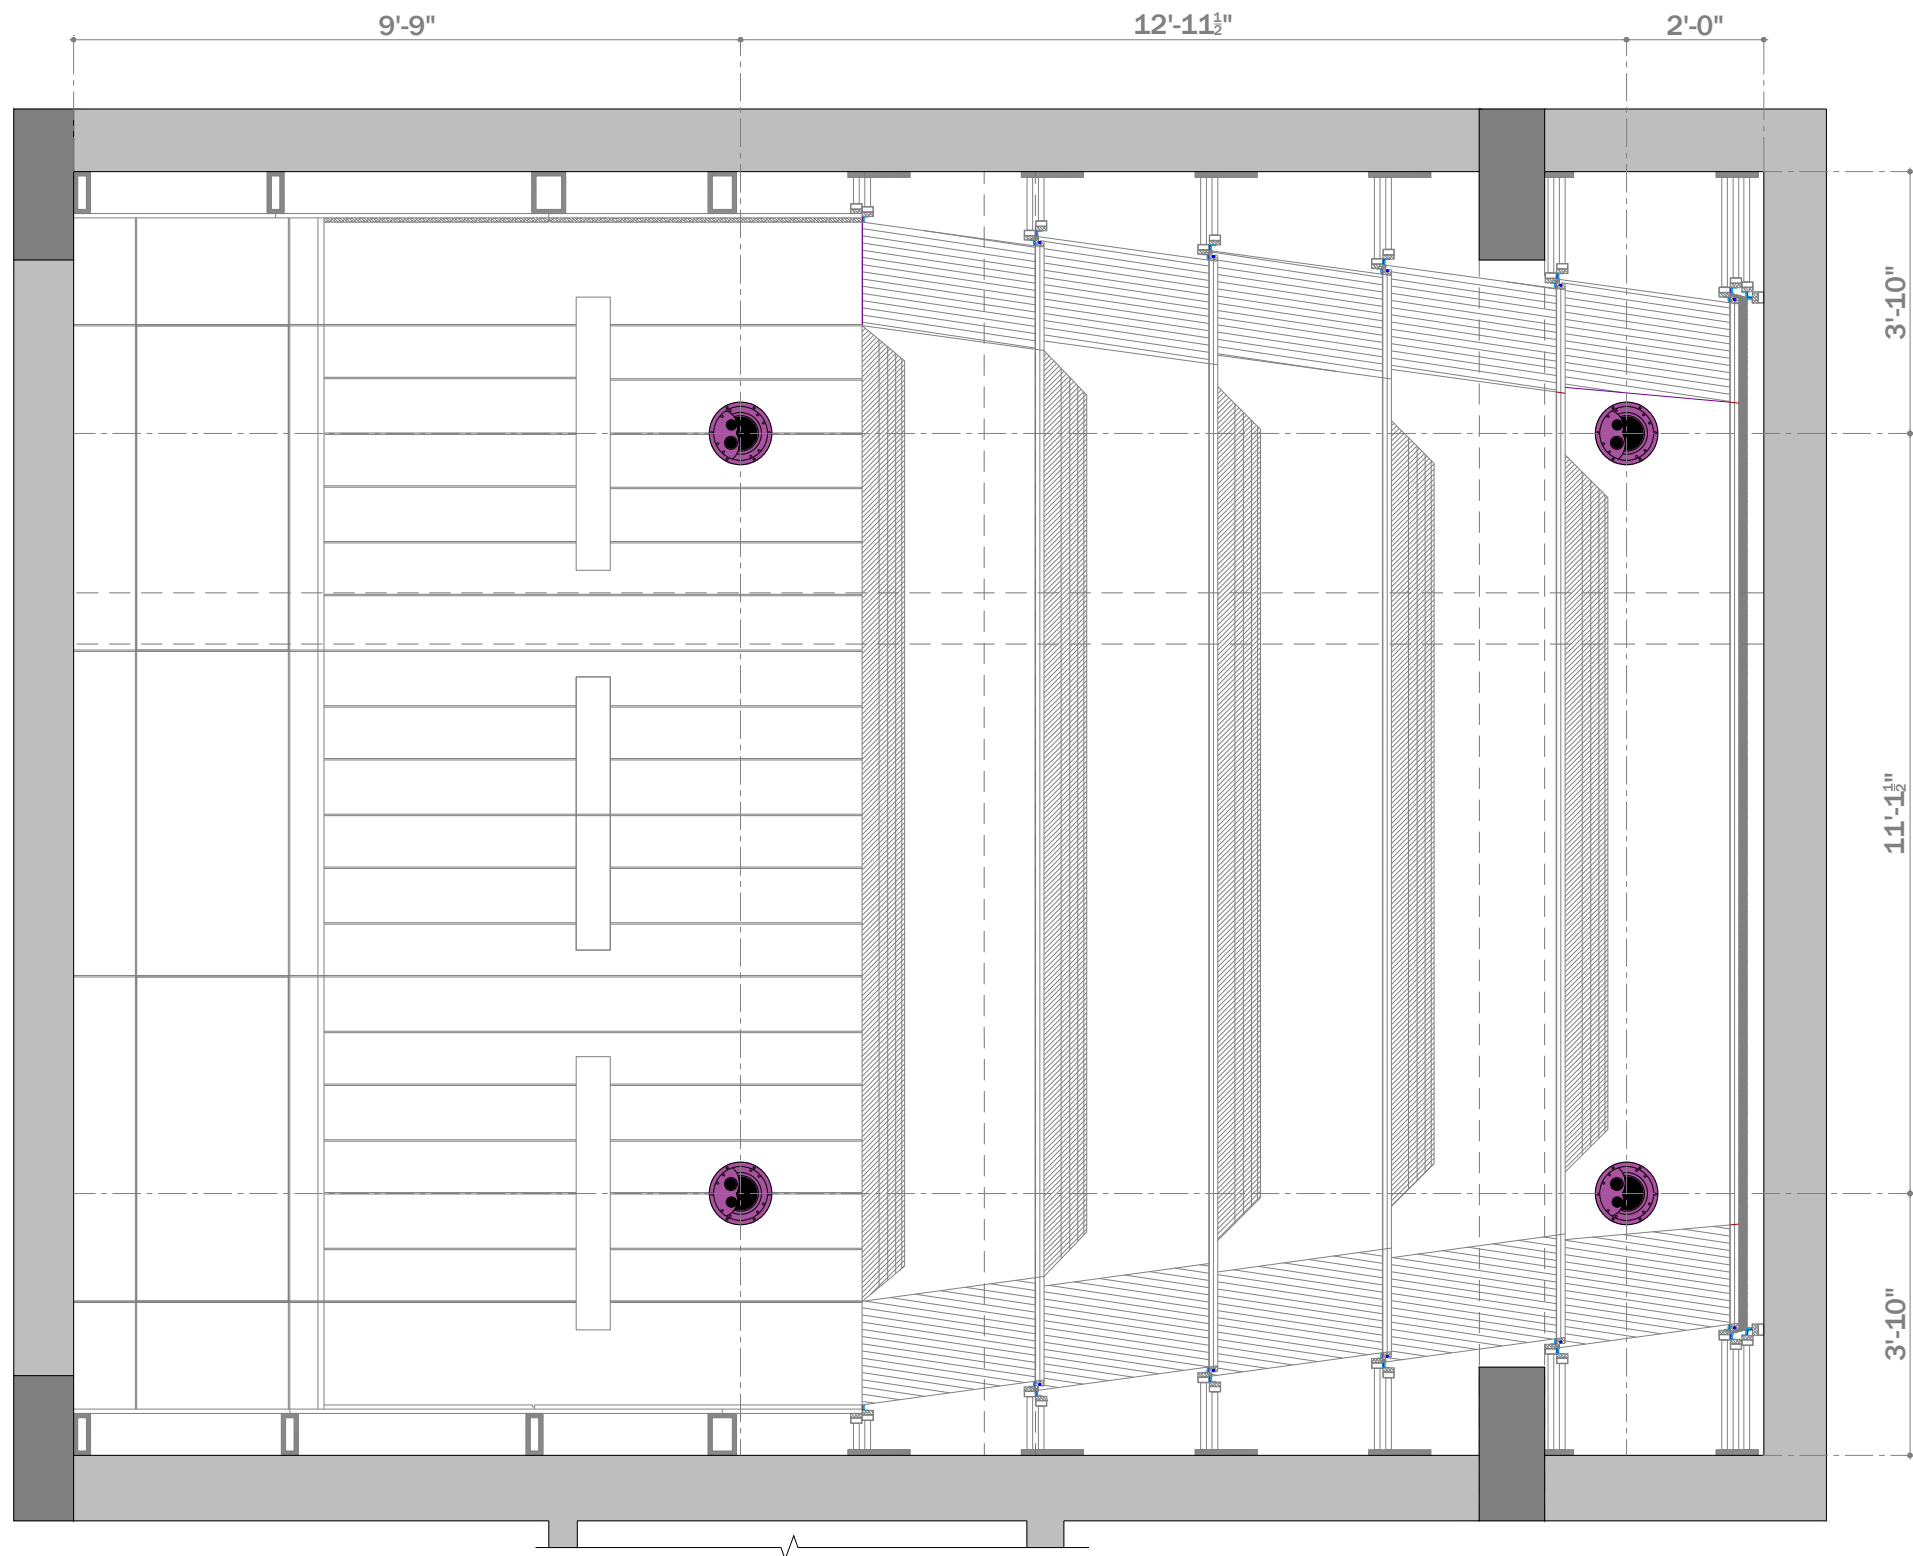

AUDIO VIDEO SYMBOLS		
SYMBOL	NAME	DO=DEVICE OPTIONS
	SPEAKER	LCR-LCR BAR SU-SUBWOOFER ST-STEREO
	VIDEO PROJECTOR	LCD-LIQUID CRYSTAL DISPLAY DLP-DIGITAL LIGHT PROCESSOR SXRD-SILICON X-TEL REF. DISP.
	PROJECTON SCREEN	F-FIXED M-MOTORISED

COMMUNICATIONS SYMBOLS		
SYMBOL	NAME	DO=DEVICE OPTIONS
	PHONE AND DATA PORT	D-DATA F-FIBRE OPTIC P-PHONE
	INCOMING SERVICES	CTV-CABLE TV P-PHONE S-SATELLITE
	RF REPEATER ACCESS POINT	CR-CELLUAR PR-PHONE WAP-WIRELESSACCESS POINT

FURNISHINGS SYMBOLS		
SYMBOL	NAME	DO=DEVICE OPTIONS
	RACK OR HEAD END	AV-AUDIO/VIDEO C-CONTROL D-DATA SEC-SECURITY
	LIFT/MOUNT	A-ARTICULATED M-MOTORISED UB-UNDER BED

EXAMPLES: SYMBOL + MOUNTING OPTION		
SYMBOL	NAME	MOUNT TYPE
	SPEAKER	CEILING MOUNTED
	SPEAKER	WALL MOUNTED
	SPEAKER	FLOOR MOUNTED
	PRE-WIRE SPEAKER	CEILING MOUNTED PRE-WIRE ONLY NO CUTOUT

CABLING OPTIONS			
	SPKR	2CX2.5 mm ²	SPEAKER CABLE
	COXL	COAXIAL	SUBWOOFER CABLE
	CAT6	CAT6	DATA CABLE
	HDMI	HDMI	VIDEO CABLE

Client : CLINICAL RETREAT

Location : ANAND

Created 06-06-2017
 Modified Not yet
 Printed Not yet

Drawing Name :
 CEILING PLAN


Drawing Type :
 SPEAKER DIMENSIONS

Drawing Scale : SCALE TO FIT

Designed by Ruchi

Checked by Ankur Bhatt

HC-052/2.3

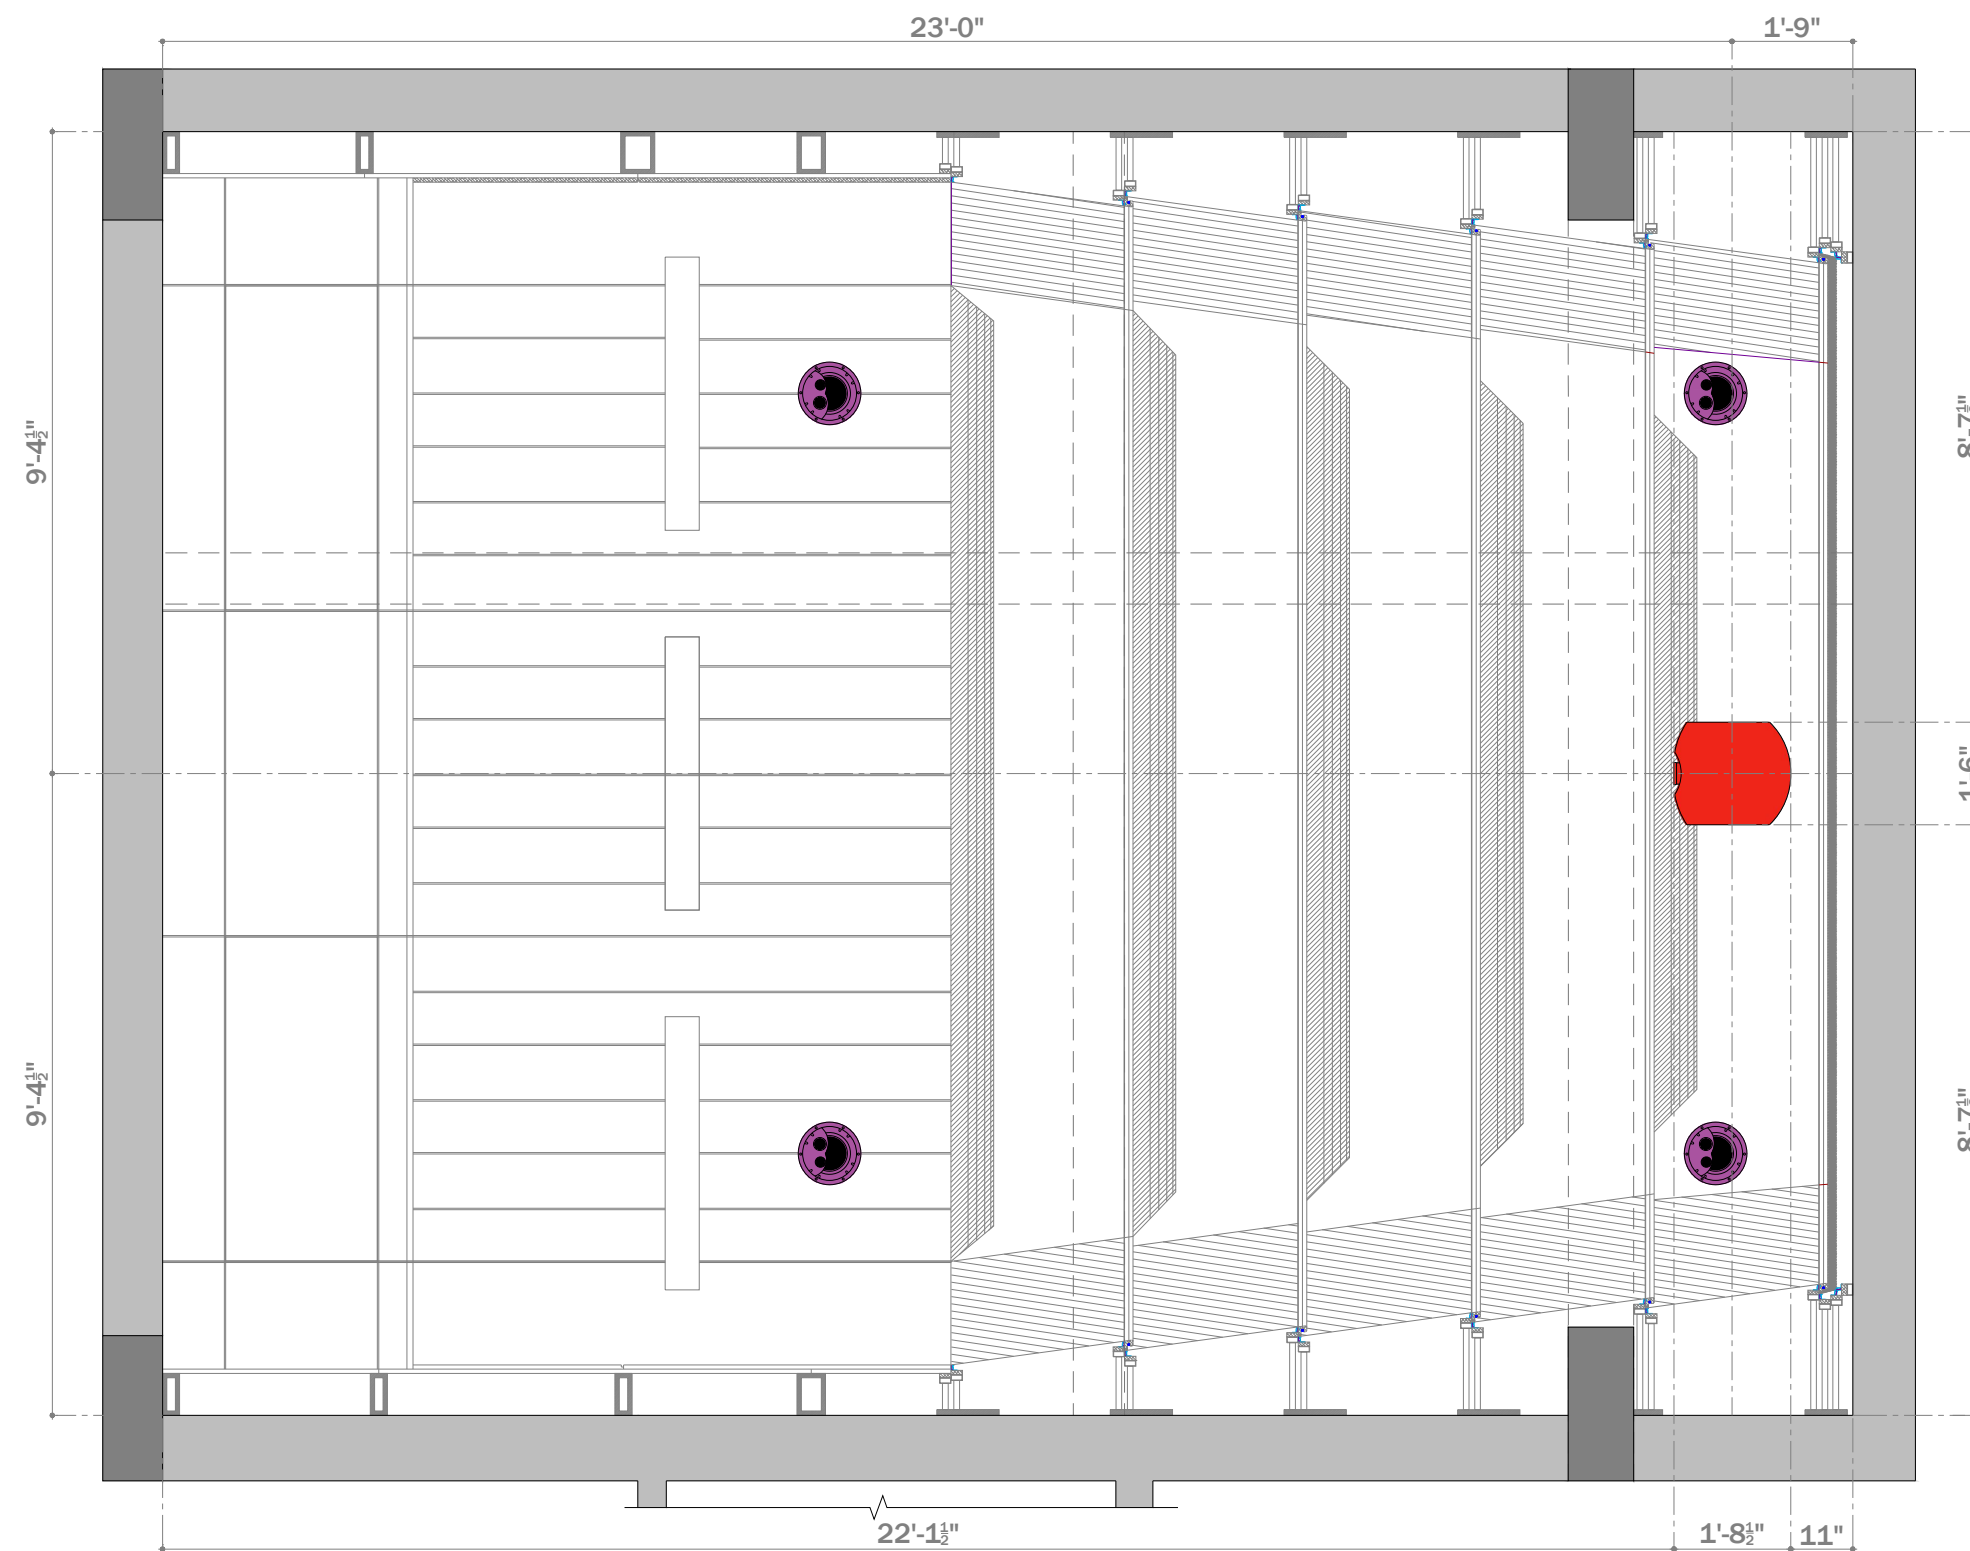

AUDIO VIDEO SYMBOLS		
SYMBOL	NAME	DO=DEVICE OPTIONS
	SPEAKER	LCR-LCR BAR SU-SUBWOOFER ST-STEREO
	VIDEO PROJECTOR	LCD-LIQUID CRYSTAL DISPLAY DLP-DIGITAL LIGHT PROCESSOR SXRD-SILICON X-TEL REF. DISP.
	PROJECTON SCREEN	F-FIXED M-MOTORISED

COMMUNICATIONS SYMBOLS		
SYMBOL	NAME	DO=DEVICE OPTIONS
	PHONE AND DATA PORT	D-DATA F-FIBRE OPTIC P-PHONE
	INCOMING SERVICES	CTV-CABLE TV P-PHONE S-SATELLITE
	RF REPEATER ACCESS POINT	CR-CELLUAR PR-PHONE WAP-WIRELESSACCESS POINT

FURNISHINGS SYMBOLS		
SYMBOL	NAME	DO=DEVICE OPTIONS
	RACK OR HEAD END	AV-AUDIO/VIDEO C-CONTROL D-DATA SEC-SECURITY
	LIFT/MOUNT	A-ARTICULATED M-MOTORISED UB-UNDER BED

EXAMPLES: SYMBOL + MOUNTING OPTION		
SYMBOL	NAME	MOUNT TYPE
	SPEAKER	CEILING MOUNTED
	SPEAKER	WALL MOUNTED
	SPEAKER	FLOOR MOUNTED
	PRE-WIRE SPEAKER	CEILING MOUNTED PRE-WIRE ONLY NO CUTOUT

CABLING OPTIONS			
	SPKR	2CX2.5 mm ²	SPEAKER CABLE
	COXL	COAXIAL	SUBWOOFER CABLE
	CAT6	CAT6	DATA CABLE
	HDMI	HDMI	VIDEO CABLE

Client : CLINICAL RETREAT

Location : ANAND

Created 06-06-2017
 Modified Not yet
 Printed Not yet

Drawing Name :
 CEILING PLAN

Drawing Type :
 PROJECTOR VIEWING

Drawing Scale : SCALE TO FIT


Designed by Ruchi

Checked by Ankur Bhatt

HC-052/2.4

2 PROJECTOR VIEWING

SCALE: TO FIT

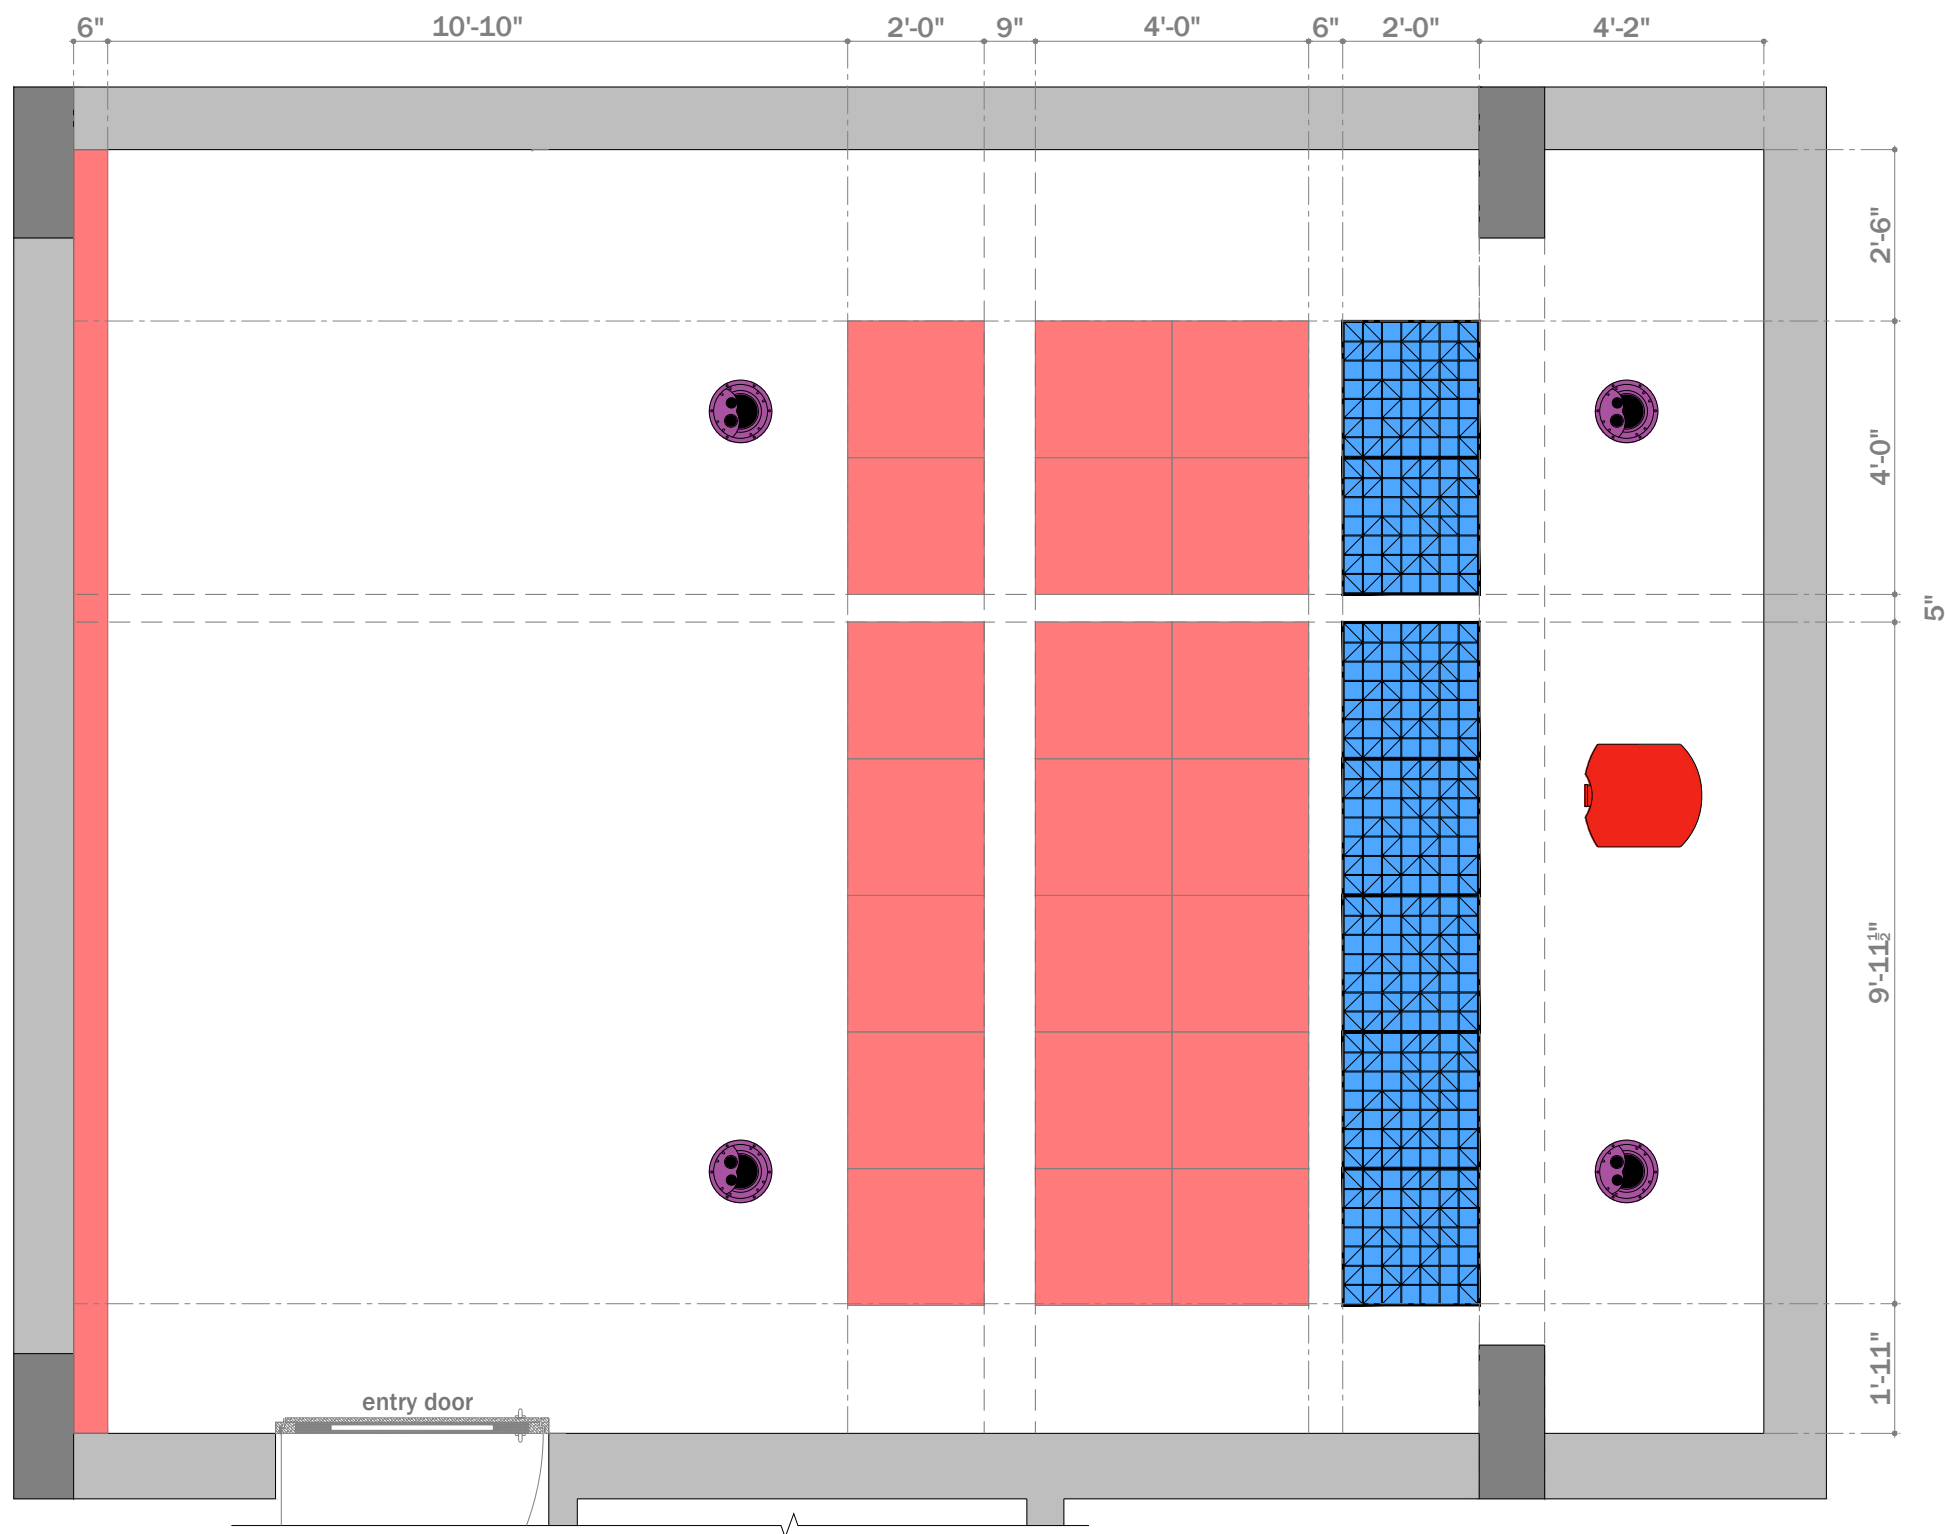

AUDIO VIDEO SYMBOLS		
SYMBOL	NAME	DO=DEVICE OPTIONS
	SPEAKER	LCR-LCR BAR SU-SUBWOOFER ST-STEREO
	VIDEO PROJECTOR	LCD-LIQUID CRYSTAL DISPLAY DLP-DIGITAL LIGHT PROCESSOR SXRD-SILICON X-TEL REF. DISP.
	PROJECTON SCREEN	F-FIXED M-MOTORISED

COMMUNICATIONS SYMBOLS		
SYMBOL	NAME	DO=DEVICE OPTIONS
	PHONE AND DATA PORT	D-DATA F-FIBRE OPTIC P-PHONE
	INCOMING SERVICES	CTV-CABLE TV P-PHONE S-SATELLITE
	RF REPEATER ACCESS POINT	CR-CELLUAR PR-PHONE WAP-WIRELESSACCESS POINT

FURNISHINGS SYMBOLS		
SYMBOL	NAME	DO=DEVICE OPTIONS
	RACK OR HEAD END	AV-AUDIO/VIDEO C-CONTROL D-DATA SEC-SECURITY
	LIFT/MOUNT	A-ARTICULATED M-MOTORISED UB-UNDER BED

EXAMPLES: SYMBOL + MOUNTING OPTION		
SYMBOL	NAME	MOUNT TYPE
	SPEAKER	CEILING MOUNTED
	SPEAKER	WALL MOUNTED
	SPEAKER	FLOOR MOUNTED
	PRE-WIRE SPEAKER	CEILING MOUNTED PRE-WIRE ONLY NO CUTOUT

CABLING OPTIONS			
	SPKR	2CX2.5 mm ²	SPEAKER CABLE
	COXL	COAXIAL	SUBWOOFER CABLE
	CAT6	CAT6	DATA CABLE
	HDMI	HDMI	VIDEO CABLE

Client : CLINICAL RETREAT

Location : ANAND

Created 06-06-2017
 Modified Not yet
 Printed Not yet

Drawing Name :
 CEILING PLAN


Drawing Type :
 ACOUSTICS

Drawing Scale : SCALE TO FIT

Designed by Ruchi

Checked by Ankur Bhatt

HC-052/2.5

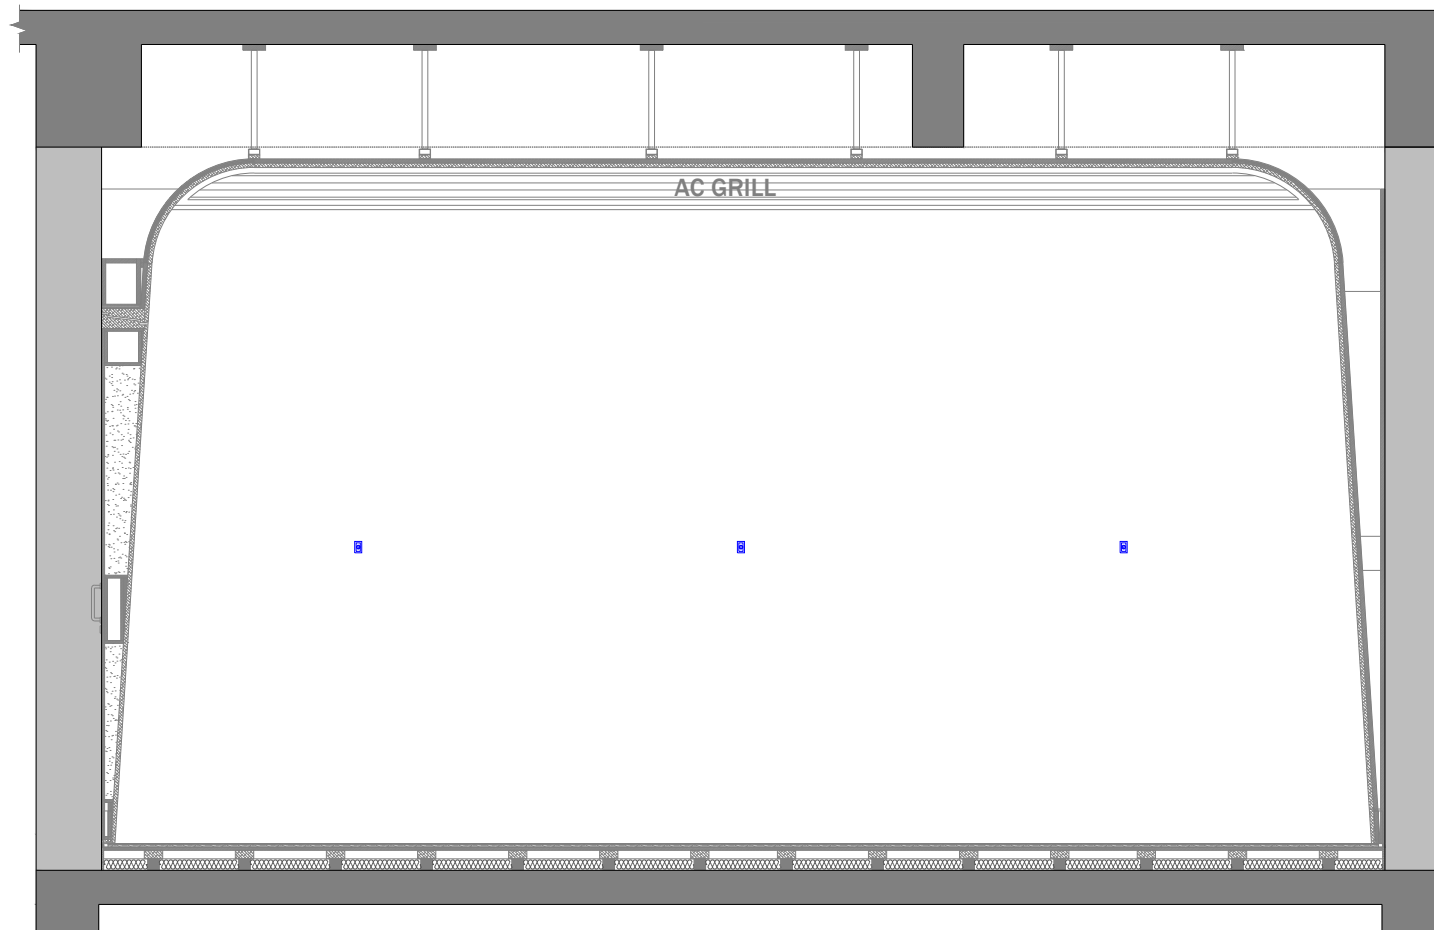

Front Side View

AUDIO VIDEO SYMBOLS		
SYMBOL	NAME	DO=DEVICE OPTIONS
	SPEAKER	LCR-LCR BAR SU-SUBWOOFER ST-STEREO
	VIDEO PROJECTOR	LCD-LIQUID CRYSTAL DISPLAY DLP-DIGITAL LIGHT PROCESSOR SXRD-SILICON X-TEL REF. DISP.
	PROJECTOR SCREEN	F-FIXED M-MOTORISED

COMMUNICATIONS SYMBOLS		
SYMBOL	NAME	DO=DEVICE OPTIONS
	PHONE AND DATA PORT	D-DATA F-FIBRE OPTIC P-PHONE
	INCOMING SERVICES	CTV-CABLE TV P-PHONE S-SATELLITE
	RF REPEATER ACCESS POINT	CR-CELLUAR PR-PHONE WAP-WIRELESSACCESS POINT

FURNISHINGS SYMBOLS		
SYMBOL	NAME	DO=DEVICE OPTIONS
	RACK OR HEAD END	AV-AUDIO/VIDEO C-CONTROL D-DATA SEC-SECURITY
	LIFT/MOUNT	A-ARTICULATED M-MOTORISED UB-UNDER BED

EXAMPLES: SYMBOL + MOUNTING OPTION		
SYMBOL	NAME	MOUNT TYPE
	SPEAKER	CEILING MOUNTED
	SPEAKER	WALL MOUNTED
	SPEAKER	FLOOR MOUNTED
	PRE-WIRE SPEAKER	CEILING MOUNTED PRE-WIRE ONLY NO CUTOUT

CABLING OPTIONS			
	SPKR	2CX2.5 mm²	SPEAKER CABLE
	COXL	COAXIAL	SUBWOOFER CABLE
	CAT6	CAT6	DATA CABLE
	HDMI	HDMI	VIDEO CABLE

Client : CLINICAL RETREAT

Location : ANAND

Created 06-06-2017
Modified Not yet
Printed Not yet

Drawing Name :
ELEVATION


Drawing Type :
ELEVATION

Drawing Scale : SCALE TO FIT

Designed by Ruchi

Checked by Ankur Bhatt

HC-052/3

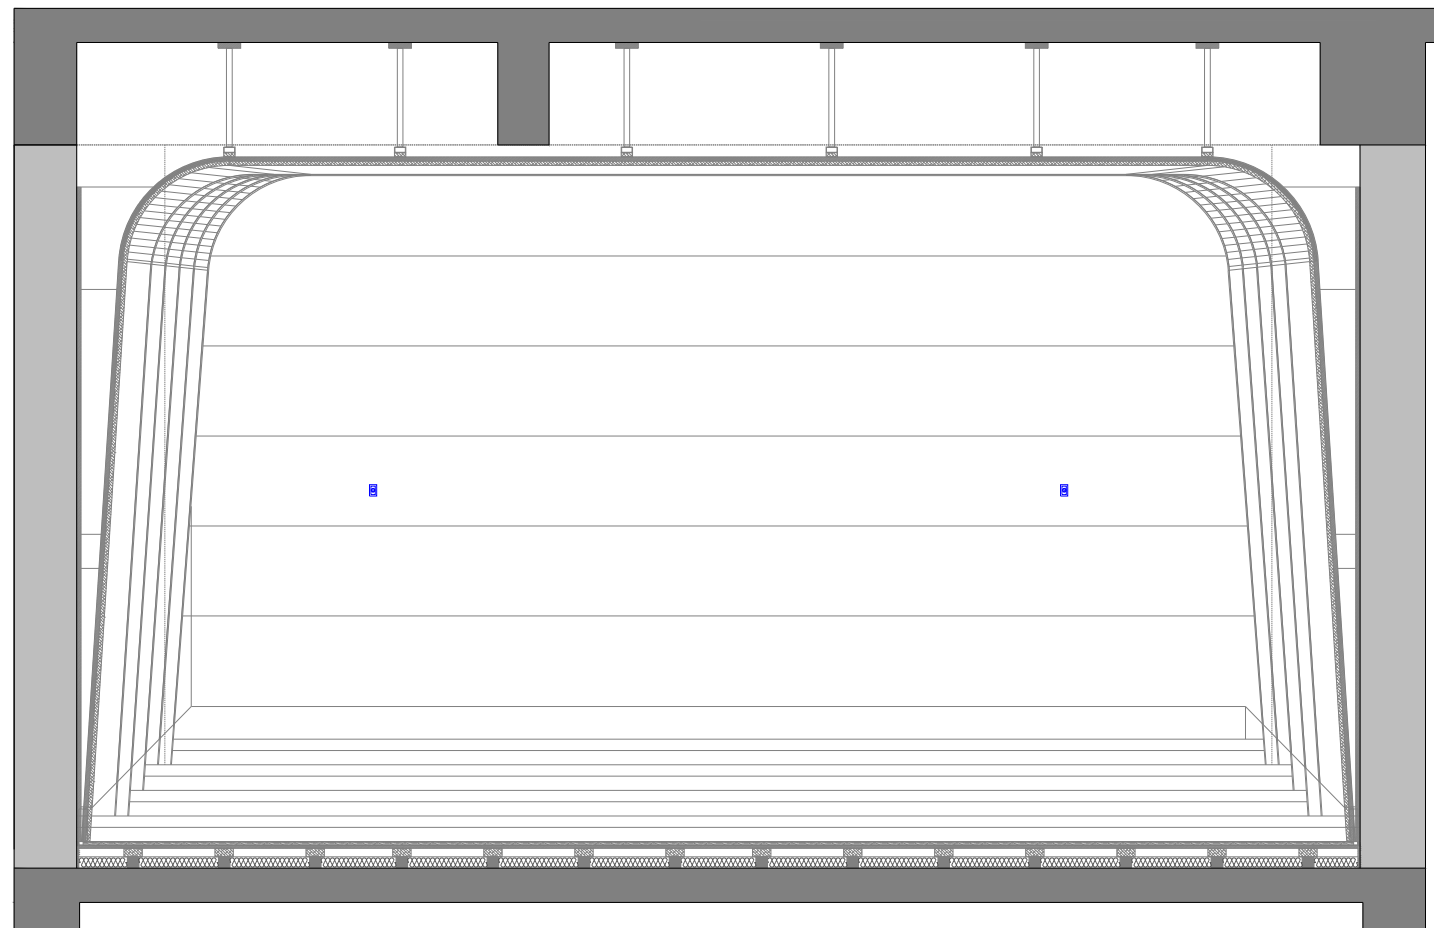

Rear Side View

AUDIO VIDEO SYMBOLS		
SYMBOL	NAME	DO=DEVICE OPTIONS
	SPEAKER	LCR-LCR BAR SU-SUBWOOFER ST-STEREO
	VIDEO PROJECTOR	LCD-LIQUID CRYSTAL DISPLAY DLP-DIGITAL LIGHT PROCESSOR SXRD-SILICON X-TEL REF. DISP.
	PROJECTON SCREEN	F-FIXED M-MOTORISED

COMMUNICATIONS SYMBOLS		
SYMBOL	NAME	DO=DEVICE OPTIONS
	PHONE AND DATA PORT	D-DATA F-FIBRE OPTIC P-PHONE
	INCOMING SERVICES	CTV-CABLE TV P-PHONE S-SATELLITE
	RF REPEATER ACCESS POINT	CR-CELLUAR PR-PHONE WAP-WIRELESSACCESS POINT

FURNISHINGS SYMBOLS		
SYMBOL	NAME	DO=DEVICE OPTIONS
	RACK OR HEAD END	AV-AUDIO/VIDEO C-CONTROL D-DATA SEC-SECURITY
	LIFT/MOUNT	A-ARTICULATED M-MOTORISED UB-UNDER BED

EXAMPLES: SYMBOL + MOUNTING OPTION		
SYMBOL	NAME	MOUNT TYPE
	SPEAKER	CEILING MOUNTED
	SPEAKER	WALL MOUNTED
	SPEAKER	FLOOR MOUNTED
	PRE-WIRE SPEAKER	CEILING MOUNTED PRE-WIRE ONLY NO CUTOUT

CABLING OPTIONS			
	SPKR	2CX2.5 mm²	SPEAKER CABLE
	COXL	COAXIAL	SUBWOOFER CABLE
	CAT6	CAT6	DATA CABLE
	HDMI	HDMI	VIDEO CABLE

Client : CLINICAL RETREAT

Location : ANAND

Created 06-06-2017
 Modified Not yet
 Printed Not yet

Drawing Name :
 ELEVATION


Drawing Type :
 ELEVATION

Drawing Scale : SCALE TO FIT

Designed by Ruchi

Checked by Ankur Bhatt

HC-052/3.1

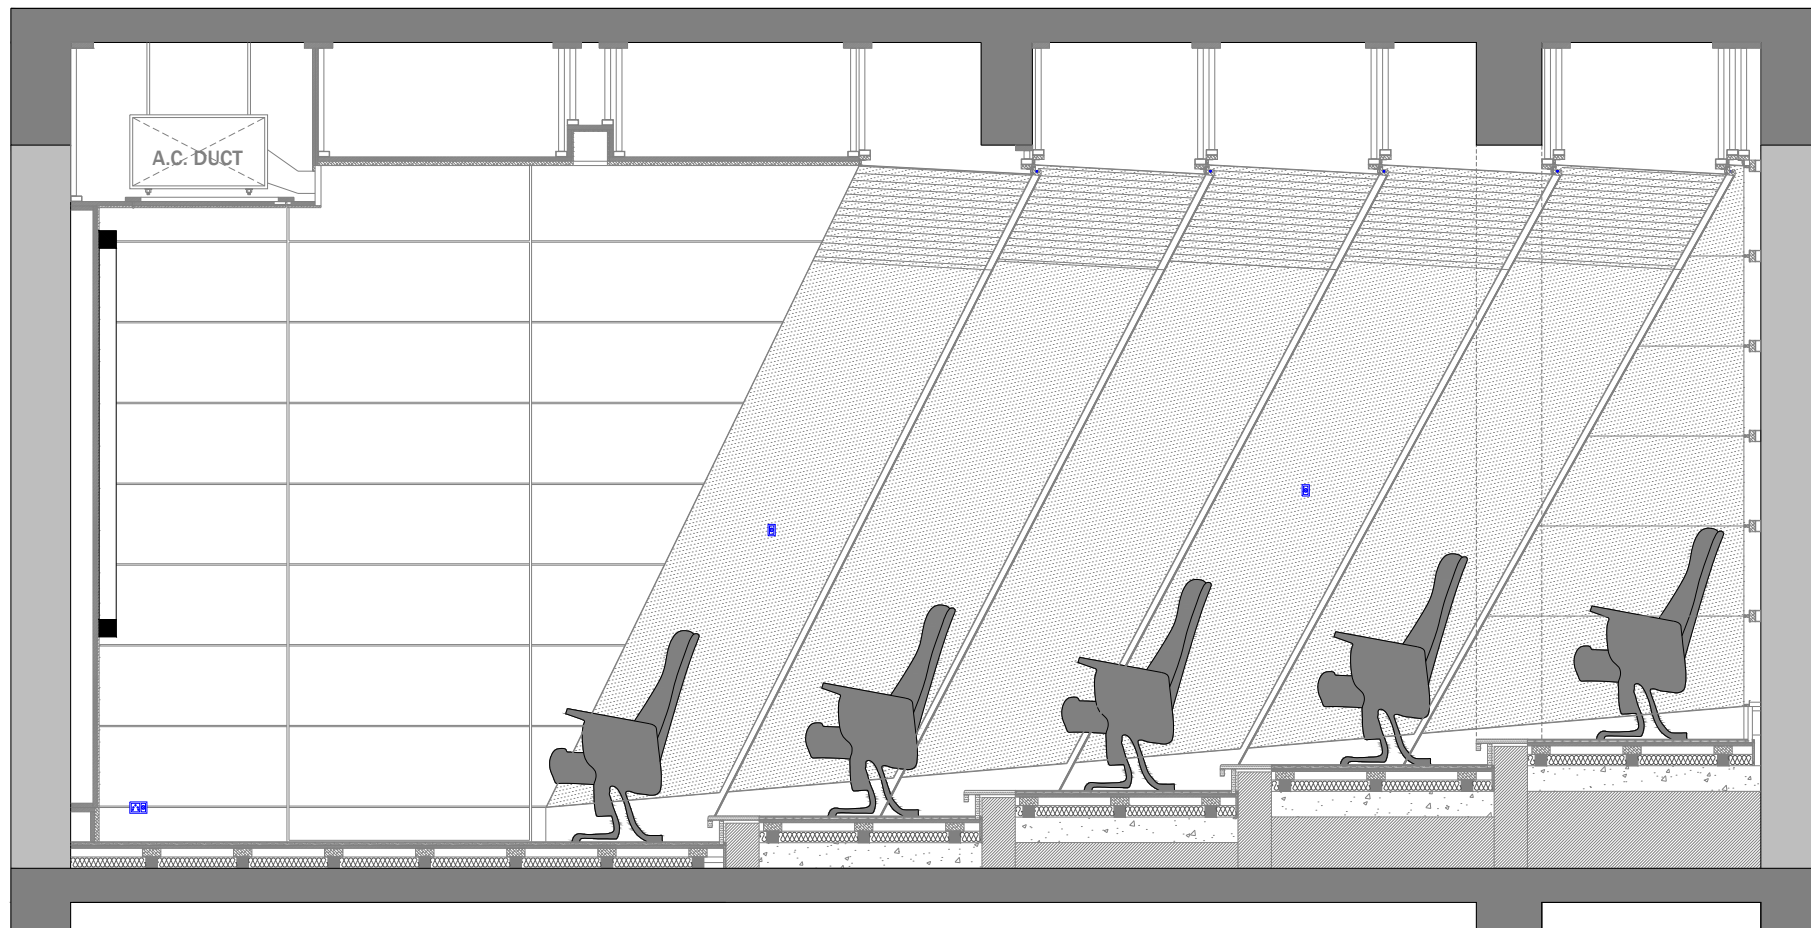

Right Side View

AUDIO VIDEO SYMBOLS		
SYMBOL	NAME	DO=DEVICE OPTIONS
	SPEAKER	LCR-LCR BAR SU-SUBWOOFER ST-STEREO
	VIDEO PROJECTOR	LCD-LIQUID CRYSTAL DISPLAY DLP-DIGITAL LIGHT PROCESSOR SXRD-SILICON X-TEL REF. DISP.
	PROJECTON SCREEN	F-FIXED M-MOTORISED

COMMUNICATIONS SYMBOLS		
SYMBOL	NAME	DO=DEVICE OPTIONS
	PHONE AND DATA PORT	D-DATA F-FIBRE OPTIC P-PHONE
	INCOMING SERVICES	CTV-CABLE TV P-PHONE S-SATELLITE
	RF REPEATER ACCESS POINT	CR-CELLUAR PR-PHONE WAP-WIRELESSACCESS POINT

FURNISHINGS SYMBOLS		
SYMBOL	NAME	DO=DEVICE OPTIONS
	RACK OR HEAD END	AV-AUDIO/VIDEO C-CONTROL D-DATA SEC-SECURITY
	LIFT/MOUNT	A-ARTICULATED M-MOTORISED UB-UNDER BED

EXAMPLES: SYMBOL + MOUNTING OPTION		
SYMBOL	NAME	MOUNT TYPE
	SPEAKER	CEILING MOUNTED
	SPEAKER	WALL MOUNTED
	SPEAKER	FLOOR MOUNTED
	PRE-WIRE SPEAKER	CEILING MOUNTED PRE-WIRE ONLY NO CUTOUT

CABLING OPTIONS			
	SPKR	2CX2.5 mm ²	SPEAKER CABLE
	COXL	COAXIAL	SUBWOOFER CABLE
	CAT6	CAT6	DATA CABLE
	HDMI	HDMI	VIDEO CABLE

Client : CLINICAL RETREAT

Location : ANAND

Created 06-06-2017
 Modified Not yet
 Printed Not yet

Drawing Name :
 ELEVATION


Drawing Type :
 ELEVATION

Drawing Scale : SCALE TO FIT

Designed by Ruchi

Checked by Ankur Bhatt

HC-052/3.2

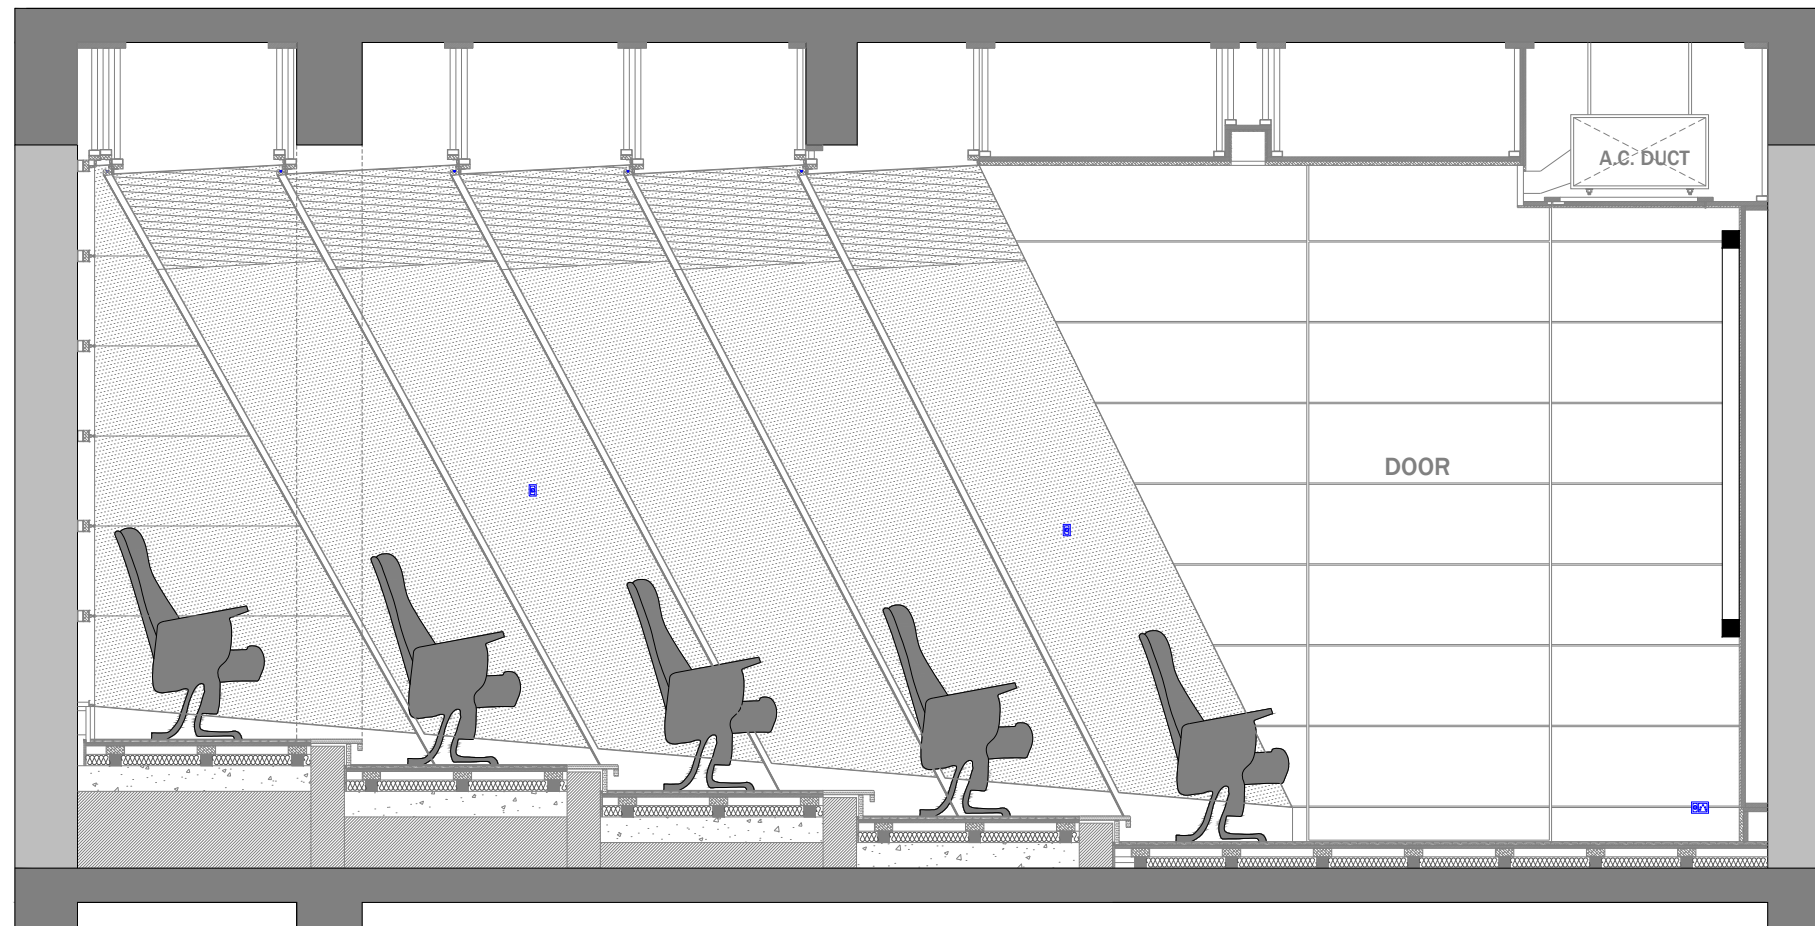

Left Side View

AUDIO VIDEO SYMBOLS		
SYMBOL	NAME	DO=DEVICE OPTIONS
	SPEAKER	LCR-LCR BAR SU-SUBWOOFER ST-STEREO
	VIDEO PROJECTOR	LCD-LIQUID CRYSTAL DISPLAY DLP-DIGITAL LIGHT PROCESSOR SXRD-SILICON X-TEL REF. DISP.
	PROJECTON SCREEN	F-FIXED M-MOTORISED

COMMUNICATIONS SYMBOLS		
SYMBOL	NAME	DO=DEVICE OPTIONS
	PHONE AND DATA PORT	D-DATA F-FIBRE OPTIC P-PHONE
	INCOMING SERVICES	CTV-CABLE TV P-PHONE S-SATELLITE
	RF REPEATER ACCESS POINT	CR-CELLUAR PR-PHONE WAP-WIRELESSACCESS POINT

FURNISHINGS SYMBOLS		
SYMBOL	NAME	DO=DEVICE OPTIONS
	RACK OR HEAD END	AV-AUDIO/VIDEO C-CONTROL D-DATA SEC-SECURITY
	LIFT/MOUNT	A-ARTICULATED M-MOTORISED UB-UNDER BED

EXAMPLES: SYMBOL + MOUNTING OPTION		
SYMBOL	NAME	MOUNT TYPE
	SPEAKER	CEILING MOUNTED
	SPEAKER	WALL MOUNTED
	SPEAKER	FLOOR MOUNTED
	PRE-WIRE SPEAKER	CEILING MOUNTED PRE-WIRE ONLY NO CUTOUT

CABLING OPTIONS			
	SPKR	2CX2.5 mm ²	SPEAKER CABLE
	COXL	COAXIAL	SUBWOOFER CABLE
	CAT6	CAT6	DATA CABLE
	HDMI	HDMI	VIDEO CABLE

Client : CLINICAL RETREAT

Location : ANAND

Created 06-06-2017
 Modified Not yet
 Printed Not yet

Drawing Name :
 ELEVATION


Drawing Type :
 ELEVATION

Drawing Scale : SCALE TO FIT

Designed by Ruchi

Checked by Ankur Bhatt

HC-052/3.4

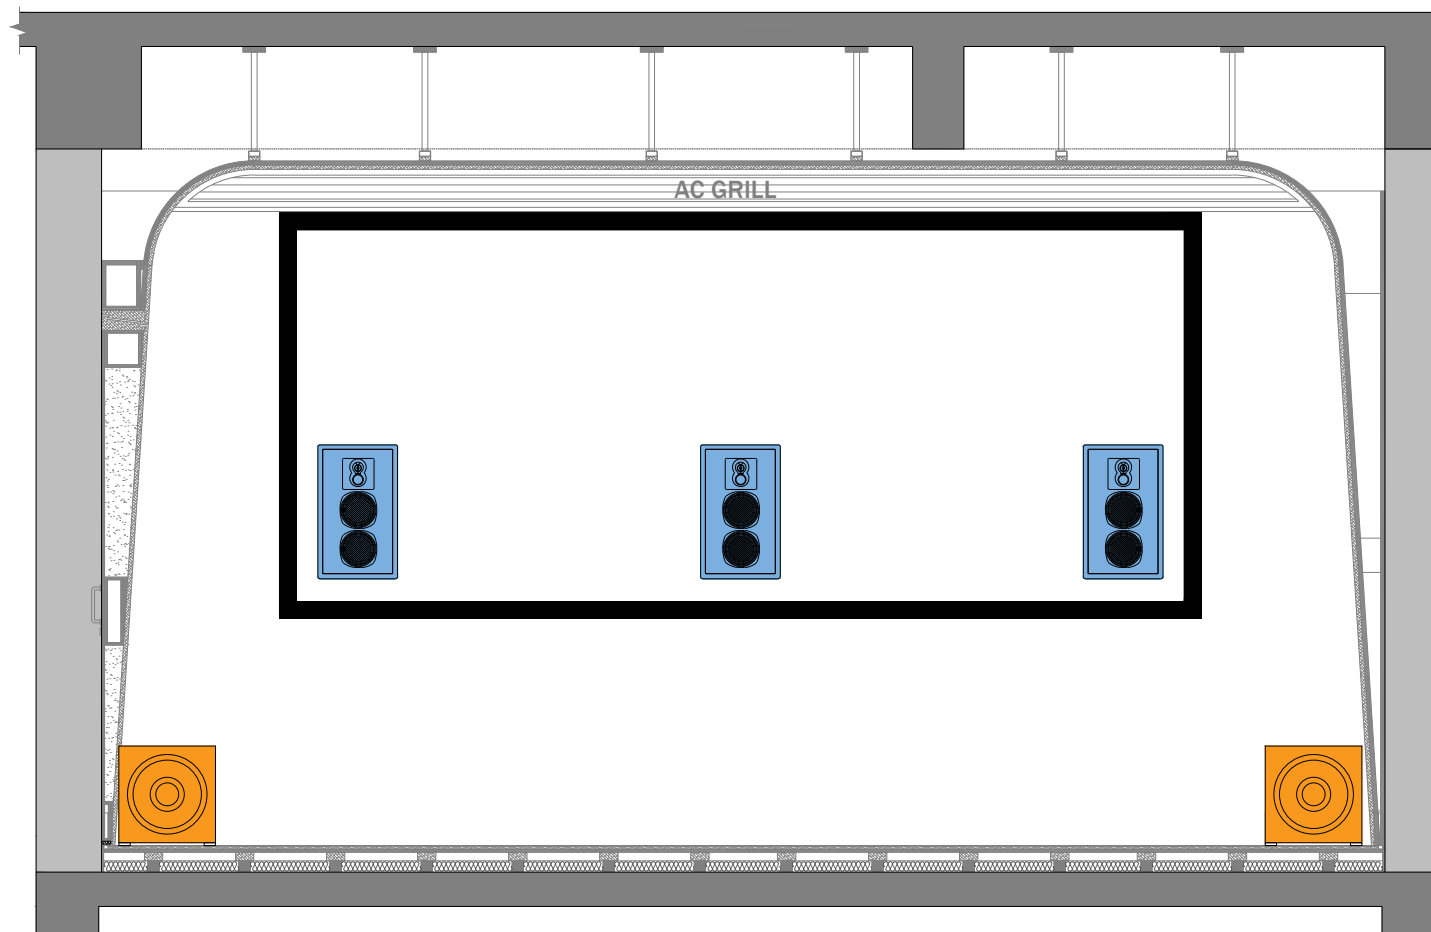

Front Side View

AUDIO VIDEO SYMBOLS		
SYMBOL	NAME	DO=DEVICE OPTIONS
	SPEAKER	LCR-LCR BAR SU-SUBWOOFER ST-STEREO
	VIDEO PROJECTOR	LCD-LIQUID CRYSTAL DISPLAY DLP-DIGITAL LIGHT PROCESSOR SXRD-SILICON X-TEL REF. DISP.
	PROJECTOR SCREEN	F-FIXED M-MOTORISED

COMMUNICATIONS SYMBOLS		
SYMBOL	NAME	DO=DEVICE OPTIONS
	PHONE AND DATA PORT	D-DATA F-FIBRE OPTIC P-PHONE
	INCOMING SERVICES	CTV-CABLE TV P-PHONE S-SATELLITE
	RF REPEATER ACCESS POINT	CR-CELLUAR PR-PHONE WAP-WIRELESSACCESS POINT

FURNISHINGS SYMBOLS		
SYMBOL	NAME	DO=DEVICE OPTIONS
	RACK OR HEAD END	AV-AUDIO/VIDEO C-CONTROL D-DATA SEC-SECURITY
	LIFT/MOUNT	A-ARTICULATED M-MOTORISED UB-UNDER BED

EXAMPLES: SYMBOL + MOUNTING OPTION		
SYMBOL	NAME	MOUNT TYPE
	SPEAKER	CEILING MOUNTED
	SPEAKER	WALL MOUNTED
	SPEAKER	FLOOR MOUNTED
	PRE-WIRE SPEAKER	CEILING MOUNTED PRE-WIRE ONLY NO CUTOUT

CABLING OPTIONS			
	SPKR	2CX2.5 mm ²	SPEAKER CABLE
	COXL	COAXIAL	SUBWOOFER CABLE
	CAT6	CAT6	DATA CABLE
	HDMI	HDMI	VIDEO CABLE

Client : CLINICAL RETREAT

Location : ANAND

Created 06-06-2017
 Modified Not yet
 Printed Not yet

Drawing Name :
ELEVATION


Drawing Type :
SPEAKER PLACEMENT

Drawing Scale : SCALE TO FIT

Designed by Ruchi

Checked by Ankur Bhatt

HC-052/3.5

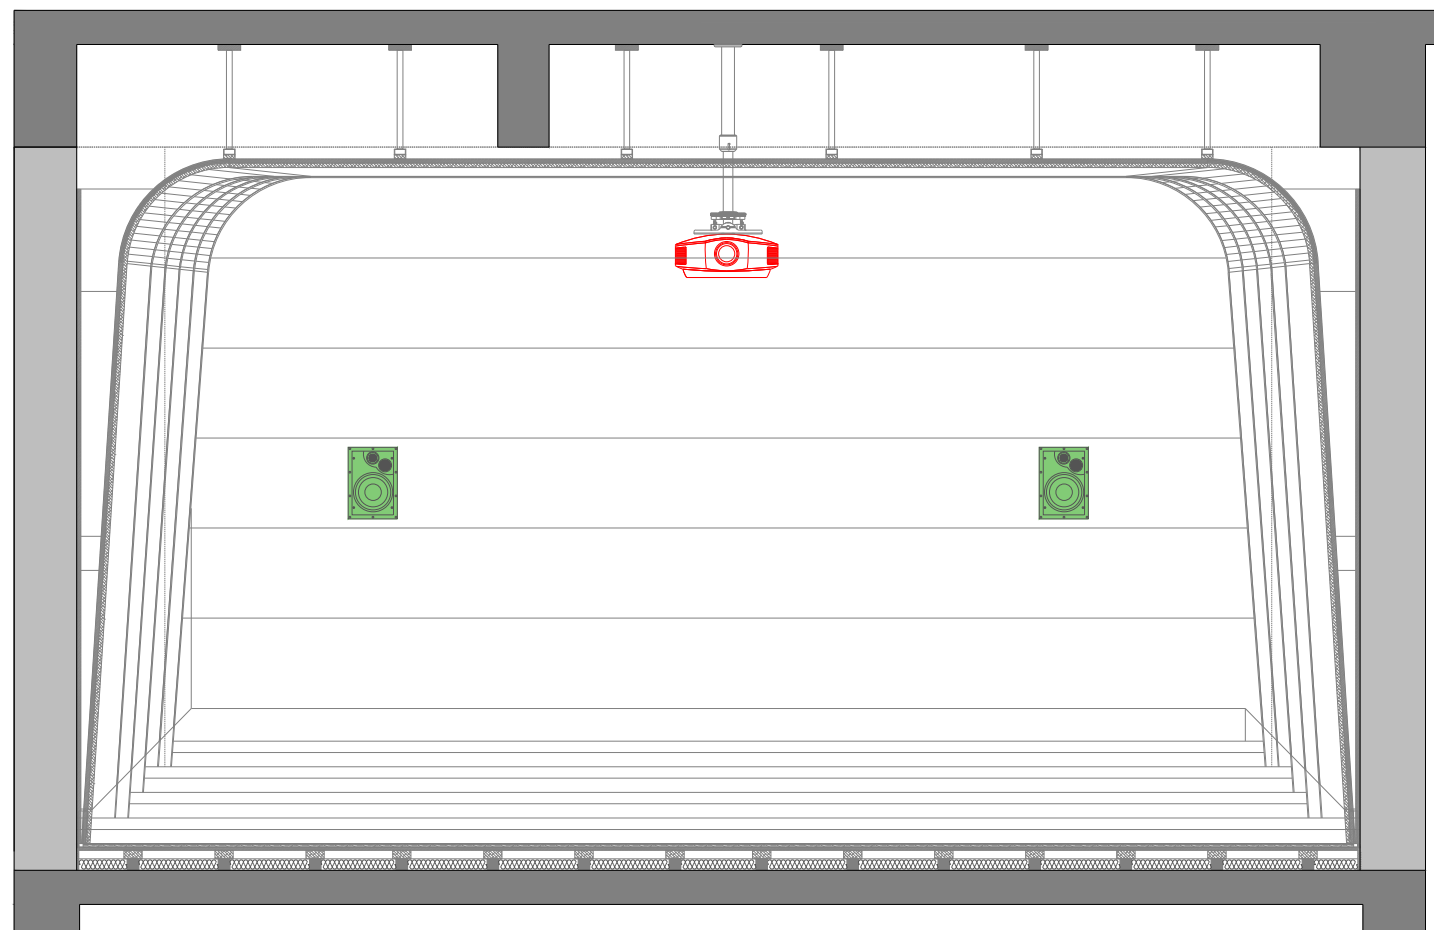

Rear Side View

AUDIO VIDEO SYMBOLS		
SYMBOL	NAME	DO=DEVICE OPTIONS
	SPEAKER	LCR-LCR BAR SU-SUBWOOFER ST-STEREO
	VIDEO PROJECTOR	LCD-LIQUID CRYSTAL DISPLAY DLP-DIGITAL LIGHT PROCESSOR SXRD-SILICON X-TEL REF. DISP.
	PROJECTON SCREEN	F-FIXED M-MOTORISED

COMMUNICATIONS SYMBOLS		
SYMBOL	NAME	DO=DEVICE OPTIONS
	PHONE AND DATA PORT	D-DATA F-FIBRE OPTIC P-PHONE
	INCOMING SERVICES	CTV-CABLE TV P-PHONE S-SATELLITE
	RF REPEATER ACCESS POINT	CR-CELLUAR PR-PHONE WAP-WIRELESSACCESS POINT

FURNISHINGS SYMBOLS		
SYMBOL	NAME	DO=DEVICE OPTIONS
	RACK OR HEAD END	AV-AUDIO/VIDEO C-CONTROL D-DATA SEC-SECURITY
	LIFT/MOUNT	A-ARTICULATED M-MOTORISED UB-UNDER BED

EXAMPLES: SYMBOL + MOUNTING OPTION		
SYMBOL	NAME	MOUNT TYPE
	SPEAKER	CEILING MOUNTED
	SPEAKER	WALL MOUNTED
	SPEAKER	FLOOR MOUNTED
	PRE-WIRE SPEAKER	CEILING MOUNTED PRE-WIRE ONLY NO CUTOUT

CABLING OPTIONS			
	SPKR	2CX2.5 mm ²	SPEAKER CABLE
	COXL	COAXIAL	SUBWOOFER CABLE
	CAT6	CAT6	DATA CABLE
	HDMI	HDMI	VIDEO CABLE

Client : CLINICAL RETREAT

Location : ANAND

Created 06-06-2017
Modified Not yet
Printed Not yet

Drawing Name :
ELEVATION


Drawing Type :
SPEAKER PLACEMENT

Drawing Scale : SCALE TO FIT

Designed by Ruchi

Checked by Ankur Bhatt

HC-052/3.6

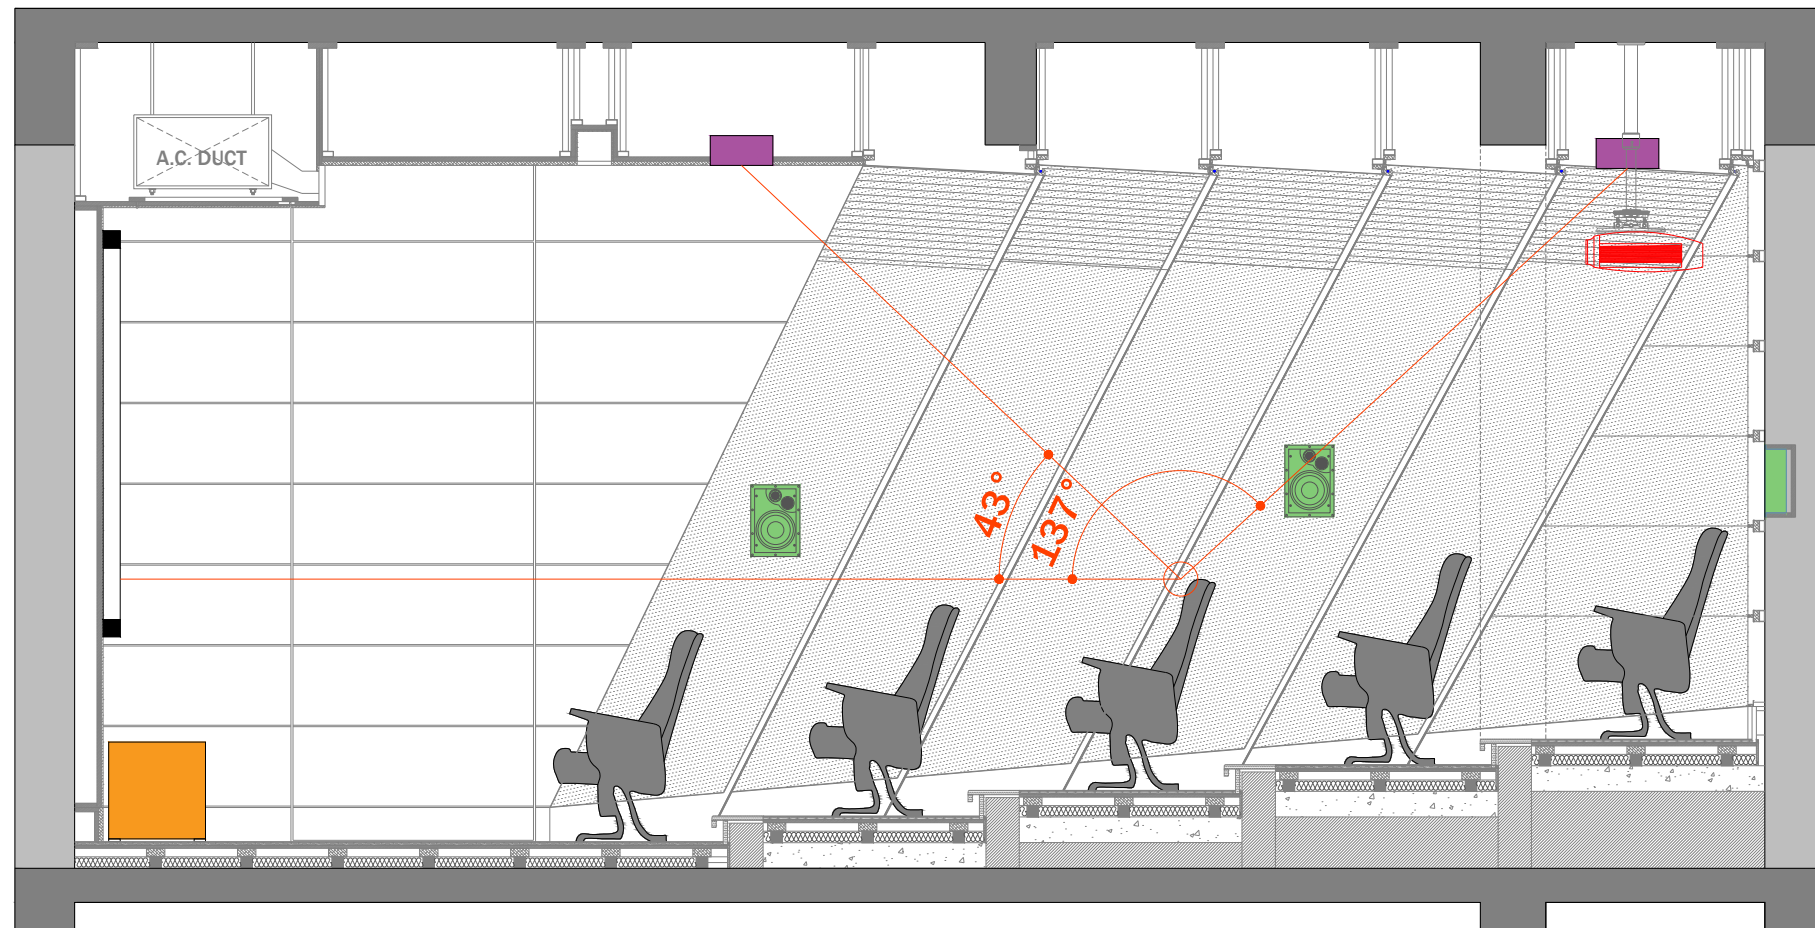

Right Side View

AUDIO VIDEO SYMBOLS			
SYMBOL	NAME	DO=DEVICE OPTIONS	
	SPEAKER	LCR-LCR BAR SU-SUBWOOFER ST-STEREO	
	VIDEO PROJECTOR	LCD-LIQUID CRYSTAL DISPLAY DLP-DIGITAL LIGHT PROCESSOR SXRD-SILICON X-TEL REF. DISP.	
	PROJECTON SCREEN	F-FIXED M-MOTORISED	
COMMUNICATIONS SYMBOLS			
SYMBOL	NAME	DO=DEVICE OPTIONS	
	PHONE AND DATA PORT	D-DATA F-FIBRE OPTIC P-PHONE	
	INCOMING SERVICES	CTV-CABLE TV P-PHONE S-SATELLITE	
	RF REPEATER ACCESS POINT	CR-CELLUAR PR-PHONE WAP-WIRELESSACCESS POINT	
FURNISHINGS SYMBOLS			
SYMBOL	NAME	DO=DEVICE OPTIONS	
	RACK OR HEAD END	AV-AUDIO/VIDEO C-CONTROL D-DATA SEC-SECURITY	
	LIFT/MOUNT	A-ARTICULATED M-MOTORISED UB-UNDER BED	
EXAMPLES: SYMBOL + MOUNTING OPTION			
SYMBOL	NAME	MOUNT TYPE	
	SPEAKER	CEILING MOUNTED	
	SPEAKER	WALL MOUNTED	
	SPEAKER	FLOOR MOUNTED	
	PRE-WIRE SPEAKER	CEILING MOUNTED PRE-WIRE ONLY NO CUTOUT	
CABLING OPTIONS			
	SPKR	2CX2.5 mm ²	SPEAKER CABLE
	COXL	COAXIAL	SUBWOOFER CABLE
	CAT6	CAT6	DATA CABLE
	HDMI	HDMI	VIDEO CABLE

Client : CLINICAL RETREAT

Location : ANAND

Created 06-06-2017
Modified Not yet
Printed Not yet

Drawing Name :
ELEVATION


Drawing Type :
SPEAKER PLACEMENT

Drawing Scale : SCALE TO FIT

Designed by Ruchi

Checked by Ankur Bhatt

HC-052/3.7

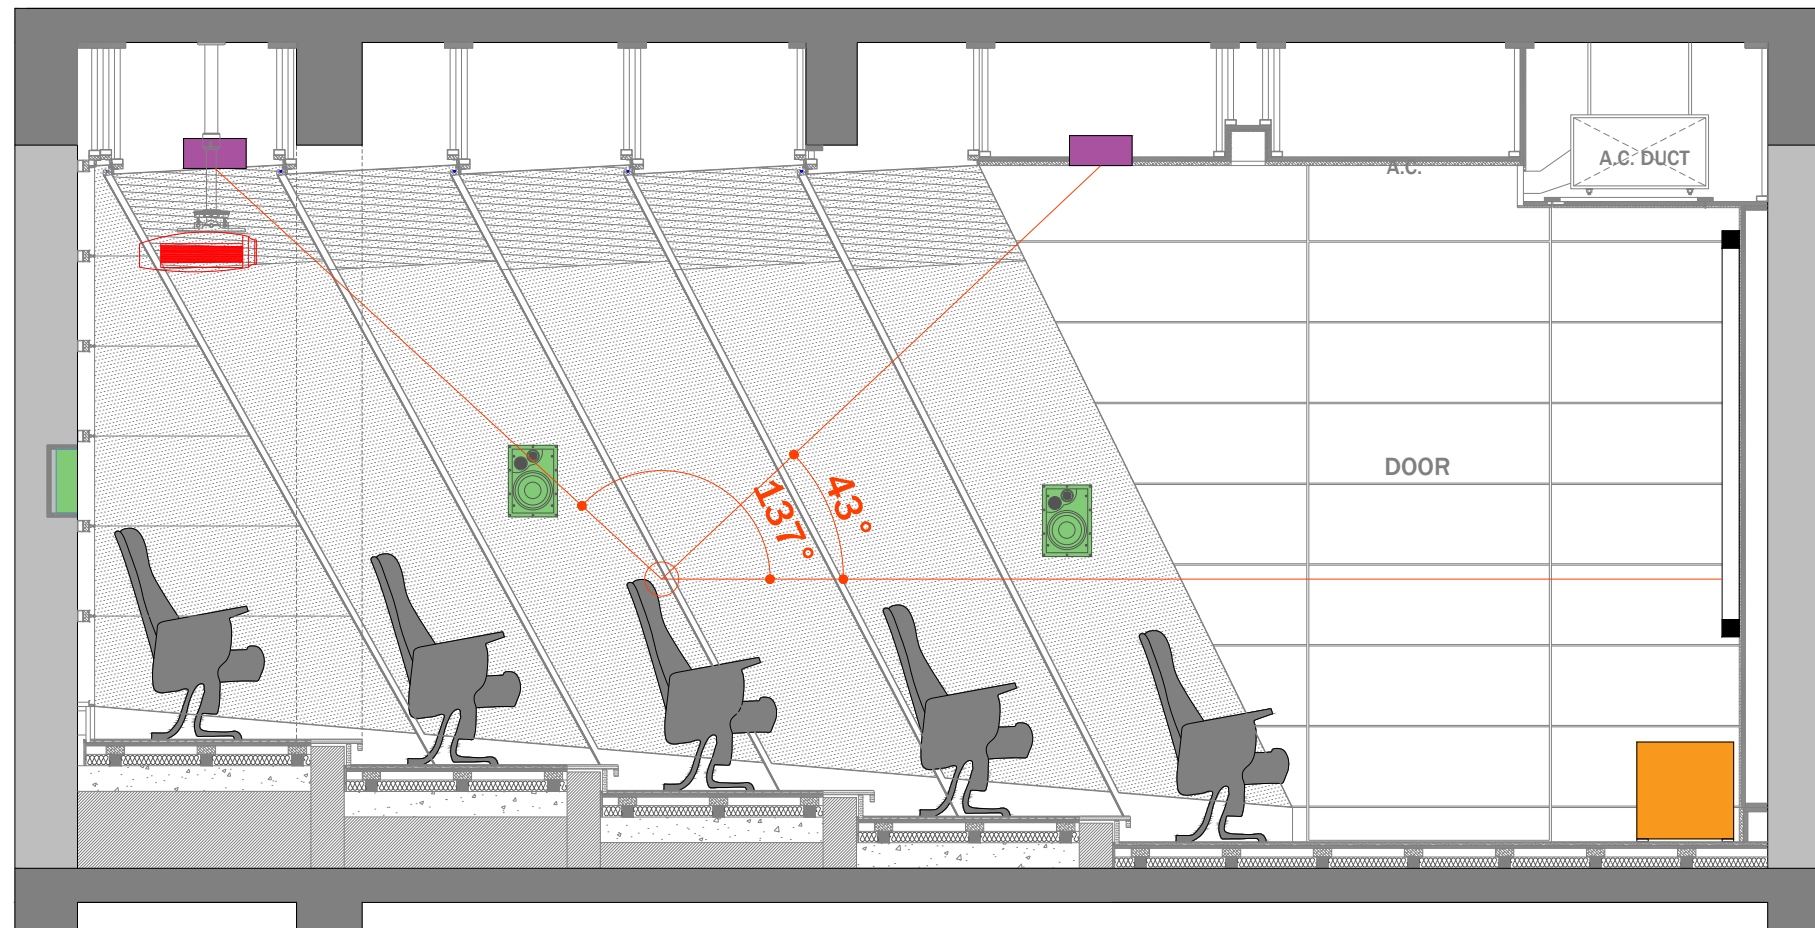

Left Side View

AUDIO VIDEO SYMBOLS		
SYMBOL	NAME	DO=DEVICE OPTIONS
	SPEAKER	LCR-LCR BAR SU-SUBWOOFER ST-STEREO
	VIDEO PROJECTOR	LCD-LIQUID CRYSTAL DISPLAY DLP-DIGITAL LIGHT PROCESSOR SXRD-SILICON X-TEL REF. DISP.
	PROJECTON SCREEN	F-FIXED M-MOTORISED

COMMUNICATIONS SYMBOLS		
SYMBOL	NAME	DO=DEVICE OPTIONS
	PHONE AND DATA PORT	D-DATA F-FIBRE OPTIC P-PHONE
	INCOMING SERVICES	CTV-CABLE TV P-PHONE S-SATELLITE
	RF REPEATER ACCESS POINT	CR-CELLUAR PR-PHONE WAP-WIRELESSACCESS POINT

FURNISHINGS SYMBOLS		
SYMBOL	NAME	DO=DEVICE OPTIONS
	RACK OR HEAD END	AV-AUDIO/VIDEO C-CONTROL D-DATA SEC-SECURITY
	LIFT/MOUNT	A-ARTICULATED M-MOTORISED UB-UNDER BED

EXAMPLES: SYMBOL + MOUNTING OPTION		
SYMBOL	NAME	MOUNT TYPE
	SPEAKER	CEILING MOUNTED
	SPEAKER	WALL MOUNTED
	SPEAKER	FLOOR MOUNTED
	PRE-WIRE SPEAKER	CEILING MOUNTED PRE-WIRE ONLY NO CUTOUT

CABLING OPTIONS			
	SPKR	2CX2.5 mm²	SPEAKER CABLE
	COXL	COAXIAL	SUBWOOFER CABLE
	CAT6	CAT6	DATA CABLE
	HDMI	HDMI	VIDEO CABLE

Client : CLINICAL RETREAT

Location : ANAND

Created 06-06-2017
Modified Not yet
Printed Not yet

Drawing Name :
ELEVATION


Drawing Type :
SPEAKER PLACEMENT

Drawing Scale : SCALE TO FIT

Designed by Ruchi

Checked by Ankur Bhatt

HC-052/3.8

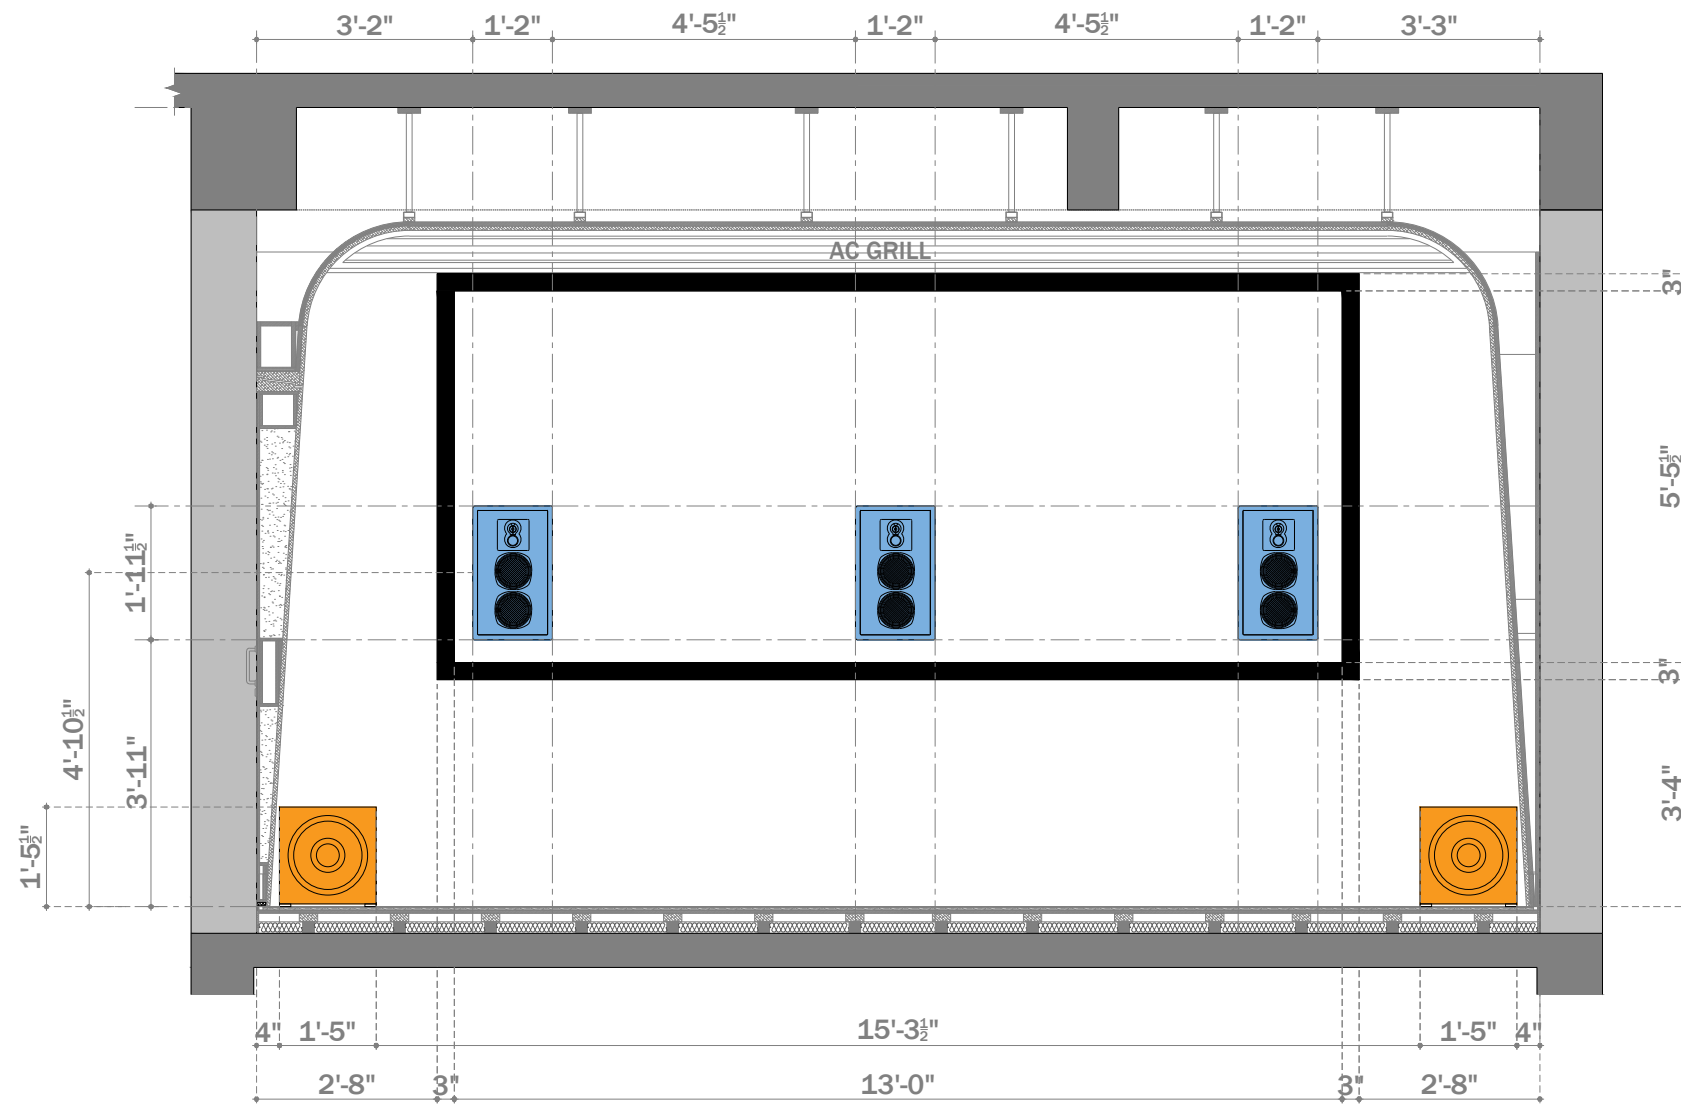

Front Side View

AUDIO VIDEO SYMBOLS		
SYMBOL	NAME	DO=DEVICE OPTIONS
	SPEAKER	LCR-LCR BAR SU-SUBWOOFER ST-STEREO
	VIDEO PROJECTOR	LCD-LIQUID CRYSTAL DISPLAY DLP-DIGITAL LIGHT PROCESSOR SXRD-SILICON X-TEL REF. DISP.
	PROJECTOR SCREEN	F-FIXED M-MOTORISED

COMMUNICATIONS SYMBOLS		
SYMBOL	NAME	DO=DEVICE OPTIONS
	PHONE AND DATA PORT	D-DATA F-FIBRE OPTIC P-PHONE
	INCOMING SERVICES	CTV-CABLE TV P-PHONE S-SATELLITE
	RF REPEATER ACCESS POINT	CR-CELLUAR PR-PHONE WAP-WIRELESSACCESS POINT

FURNISHINGS SYMBOLS		
SYMBOL	NAME	DO=DEVICE OPTIONS
	RACK OR HEAD END	AV-AUDIO/VIDEO C-CONTROL D-DATA SEC-SECURITY
	LIFT/MOUNT	A-ARTICULATED M-MOTORISED UB-UNDER BED

EXAMPLES: SYMBOL + MOUNTING OPTION		
SYMBOL	NAME	MOUNT TYPE
	SPEAKER	CEILING MOUNTED
	SPEAKER	WALL MOUNTED
	SPEAKER	FLOOR MOUNTED
	PRE-WIRE SPEAKER	CEILING MOUNTED PRE-WIRE ONLY NO CUTOUT

CABLING OPTIONS			
	SPKR	2CX2.5 mm ²	SPEAKER CABLE
	COXL	COAXIAL	SUBWOOFER CABLE
	CAT6	CAT6	DATA CABLE
	HDMI	HDMI	VIDEO CABLE

Client : CLINICAL RETREAT

Location : ANAND

Created 06-06-2017
Modified Not yet
Printed Not yet

Drawing Name :
ELEVATION


Drawing Type :
SPEAKER DIMENSIONS

Drawing Scale : SCALE TO FIT

Designed by Ruchi

Checked by Ankur Bhatt

HC-052/3.9

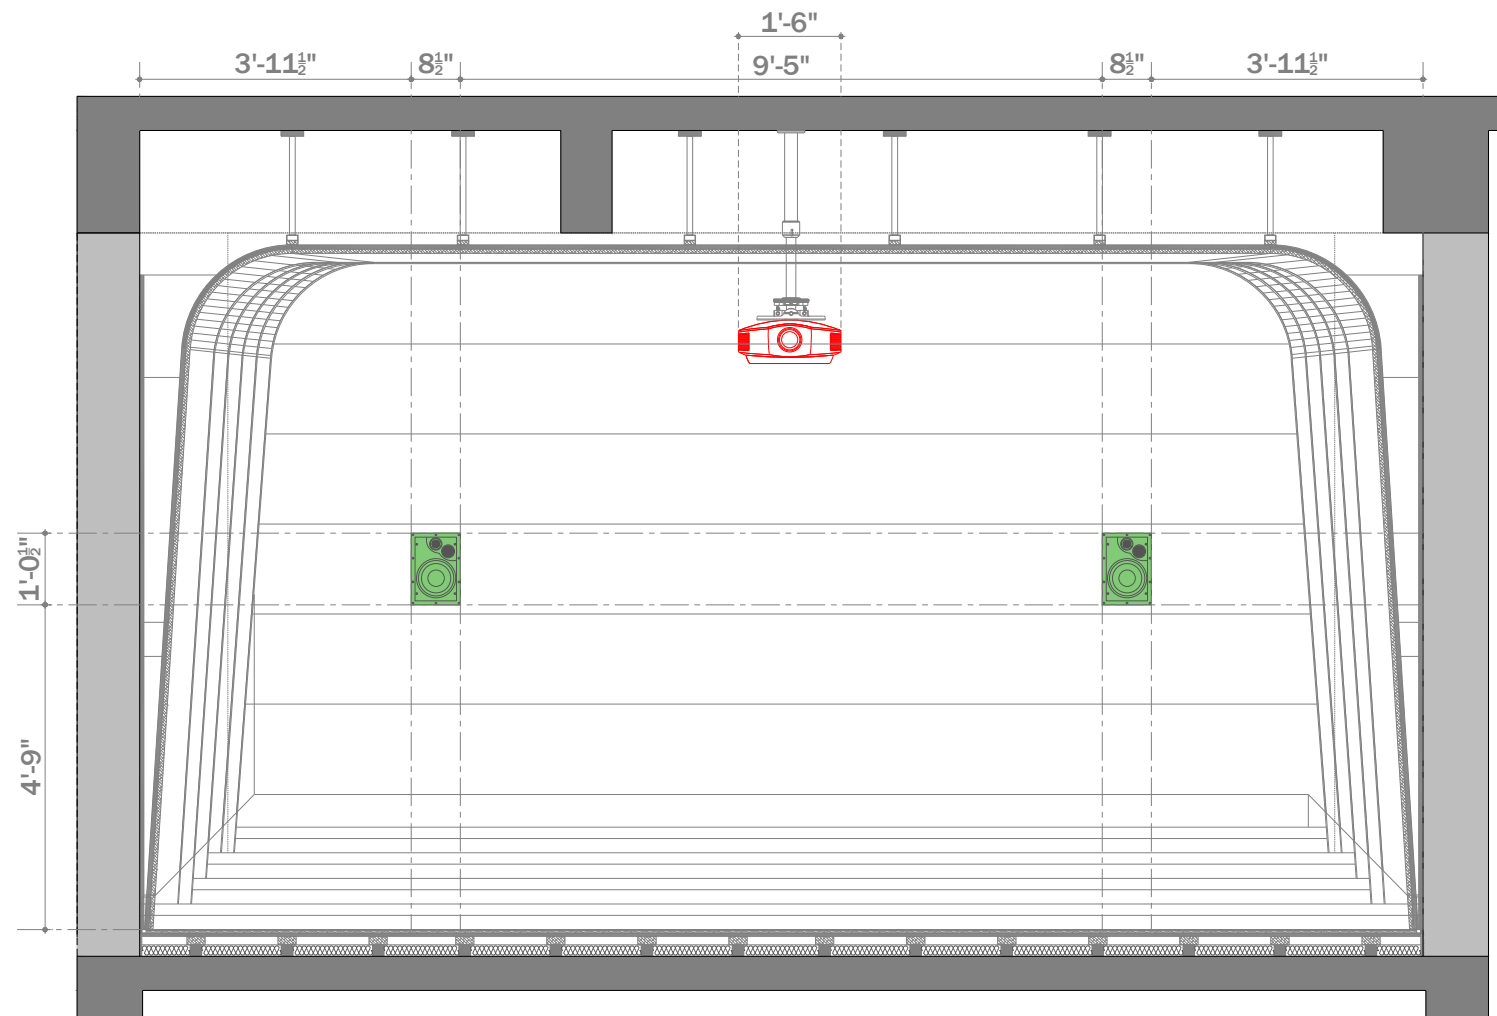

Rear Side View

AUDIO VIDEO SYMBOLS		
SYMBOL	NAME	DO=DEVICE OPTIONS
	SPEAKER	LCR-LCR BAR SU-SUBWOOFER ST-STEREO
	VIDEO PROJECTOR	LCD-LIQUID CRYSTAL DISPLAY DLP-DIGITAL LIGHT PROCESSOR SXRD-SILICON X-TEL REF. DISP.
	PROJECTON SCREEN	F-FIXED M-MOTORISED

COMMUNICATIONS SYMBOLS		
SYMBOL	NAME	DO=DEVICE OPTIONS
	PHONE AND DATA PORT	D-DATA F-FIBRE OPTIC P-PHONE
	INCOMING SERVICES	CTV-CABLE TV P-PHONE S-SATELLITE
	RF REPEATER ACCESS POINT	CR-CELLUAR PR-PHONE WAP-WIRELESSACCESS POINT

FURNISHINGS SYMBOLS		
SYMBOL	NAME	DO=DEVICE OPTIONS
	RACK OR HEAD END	AV-AUDIO/VIDEO C-CONTROL D-DATA SEC-SECURITY
	LIFT/MOUNT	A-ARTICULATED M-MOTORISED UB-UNDER BED

EXAMPLES: SYMBOL + MOUNTING OPTION		
SYMBOL	NAME	MOUNT TYPE
	SPEAKER	CEILING MOUNTED
	SPEAKER	WALL MOUNTED
	SPEAKER	FLOOR MOUNTED
	PRE-WIRE SPEAKER	CEILING MOUNTED PRE-WIRE ONLY NO CUTOUT

CABLING OPTIONS			
	SPKR	2CX2.5 mm ²	SPEAKER CABLE
	COXL	COAXIAL	SUBWOOFER CABLE
	CAT6	CAT6	DATA CABLE
	HDMI	HDMI	VIDEO CABLE

Client : CLINICAL RETREAT

Location : ANAND

Created 06-06-2017
Modified Not yet
Printed Not yet

Drawing Name :
ELEVATION

Drawing Type :
SPEAKER DIMENSIONS

Drawing Scale : SCALE TO FIT

Designed by Ruchi

Checked by Ankur Bhatt

HC-052/3.10



Right Side View

AUDIO VIDEO SYMBOLS		
SYMBOL	NAME	DO=DEVICE OPTIONS
	SPEAKER	LCR-LCR BAR SU-SUBWOOFER ST-STEREO
	VIDEO PROJECTOR	LCD-LIQUID CRYSTAL DISPLAY DLP-DIGITAL LIGHT PROCESSOR SXRD-SILICON X-TEL REF. DISP.
	PROJECTION SCREEN	F-FIXED M-MOTORISED

COMMUNICATIONS SYMBOLS		
SYMBOL	NAME	DO=DEVICE OPTIONS
	PHONE AND DATA PORT	D-DATA F-FIBRE OPTIC P-PHONE
	INCOMING SERVICES	CTV-CABLE TV P-PHONE S-SATELLITE
	RF REPEATER ACCESS POINT	CR-CELLULAR PR-PHONE WAP-WIRELESS ACCESS POINT

FURNISHINGS SYMBOLS		
SYMBOL	NAME	DO=DEVICE OPTIONS
	RACK OR HEAD END	AV-AUDIO/VIDEO C-CONTROL D-DATA SEC-SECURITY
	LIFT/MOUNT	A-ARTICULATED M-MOTORISED UB-UNDER BED

EXAMPLES: SYMBOL + MOUNTING OPTION		
SYMBOL	NAME	MOUNT TYPE
	SPEAKER	CEILING MOUNTED
	SPEAKER	WALL MOUNTED
	SPEAKER	FLOOR MOUNTED
	PRE-WIRE SPEAKER	CEILING MOUNTED PRE-WIRE ONLY NO CUTOUT

CABLING OPTIONS			
	SPKR	2CX2.5 mm²	SPEAKER CABLE
	COXL	COAXIAL	SUBWOOFER CABLE
	CAT6	CAT6	DATA CABLE
	HDMI	HDMI	VIDEO CABLE

Client : CLINICAL RETREAT

Location : ANAND

Created 06-06-2017
 Modified Not yet
 Printed Not yet

Drawing Name :
 ELEVATION

Drawing Type :
 SPEAKER DIMENSIONS

Drawing Scale : SCALE TO FIT

Designed by Ruchi

Checked by Ankur Bhatt

HC-052/3.11



Left Side View

AUDIO VIDEO SYMBOLS		
SYMBOL	NAME	DO=DEVICE OPTIONS
	SPEAKER	LCR-LCR BAR SU-SUBWOOFER ST-STEREO
	VIDEO PROJECTOR	LCD-LIQUID CRYSTAL DISPLAY DLP-DIGITAL LIGHT PROCESSOR SXRD-SILICON X-TEL REF. DISP.
	PROJECTON SCREEN	F-FIXED M-MOTORISED

COMMUNICATIONS SYMBOLS		
SYMBOL	NAME	DO=DEVICE OPTIONS
	PHONE AND DATA PORT	D-DATA F-FIBRE OPTIC P-PHONE
	INCOMING SERVICES	CTV-CABLE TV P-PHONE S-SATELLITE
	RF REPEATER ACCESS POINT	CR-CELLUAR PR-PHONE WAP-WIRELESSACCESS POINT

FURNISHINGS SYMBOLS		
SYMBOL	NAME	DO=DEVICE OPTIONS
	RACK OR HEAD END	AV-AUDIO/VIDEO C-CONTROL D-DATA SEC-SECURITY
	LIFT/MOUNT	A-ARTICULATED M-MOTORISED UB-UNDER BED

EXAMPLES: SYMBOL + MOUNTING OPTION		
SYMBOL	NAME	MOUNT TYPE
	SPEAKER	CEILING MOUNTED
	SPEAKER	WALL MOUNTED
	SPEAKER	FLOOR MOUNTED
	PRE-WIRE SPEAKER	CEILING MOUNTED PRE-WIRE ONLY NO CUTOUT

CABLING OPTIONS			
	SPKR	2CX2.5 mm ²	SPEAKER CABLE
	COXL	COAXIAL	SUBWOOFER CABLE
	CAT6	CAT6	DATA CABLE
	HDMI	HDMI	VIDEO CABLE

Client : CLINICAL RETREAT

Location : ANAND

Created 06-06-2017
 Modified Not yet
 Printed Not yet

Drawing Name :
 ELEVATION


Drawing Type :
 SPEAKER DIMENSIONS

Drawing Scale : SCALE TO FIT

Designed by Ruchi

Checked by Ankur Bhatt

HC-052/3.12

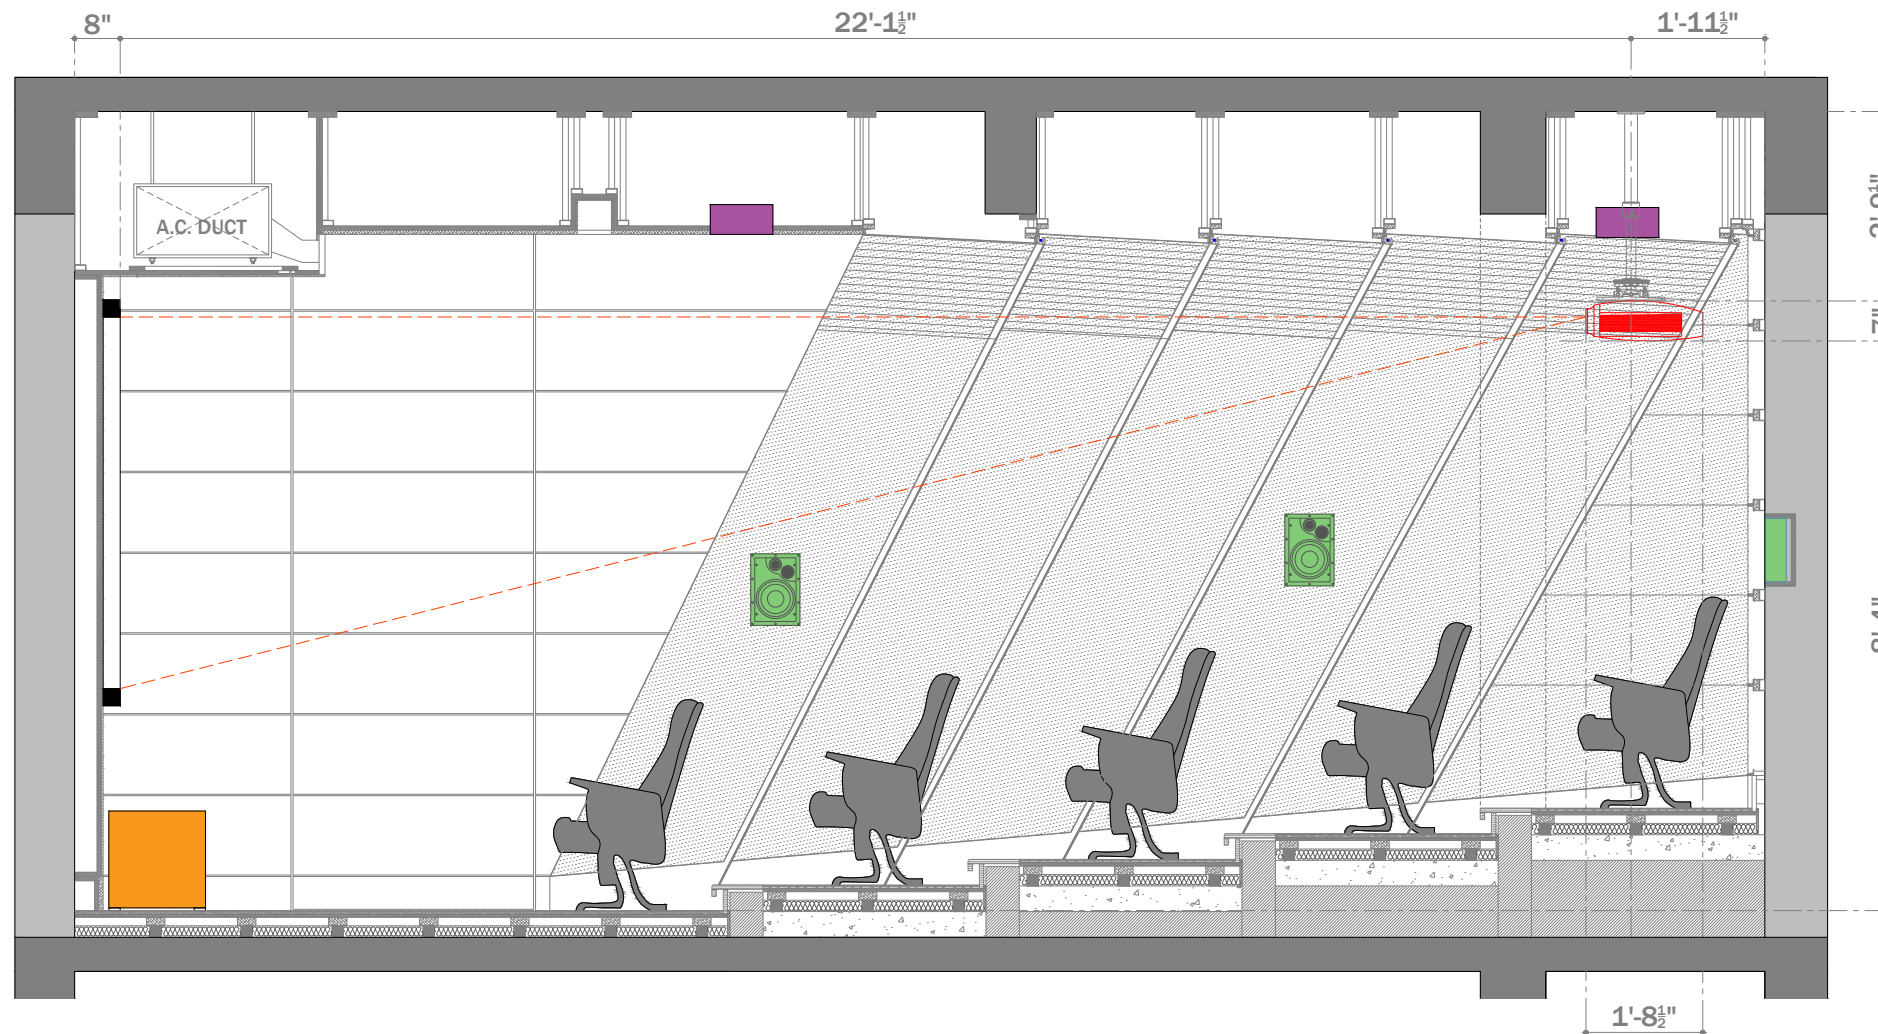

Right Side View

AUDIO VIDEO SYMBOLS		
SYMBOL	NAME	DO=DEVICE OPTIONS
	SPEAKER	LCR-LCR BAR SU-SUBWOOFER ST-STEREO
	VIDEO PROJECTOR	LCD-LIQUID CRYSTAL DISPLAY DLP-DIGITAL LIGHT PROCESSOR SXRD-SILICON X-TEL REF. DISP.
	PROJECTON SCREEN	F-FIXED M-MOTORISED

COMMUNICATIONS SYMBOLS		
SYMBOL	NAME	DO=DEVICE OPTIONS
	PHONE AND DATA PORT	D-DATA F-FIBRE OPTIC P-PHONE
	INCOMING SERVICES	CTV-CABLE TV P-PHONE S-SATELLITE
	RF REPEATER ACCESS POINT	CR-CELLUAR PR-PHONE WAP-WIRELESSACCESS POINT

FURNISHINGS SYMBOLS		
SYMBOL	NAME	DO=DEVICE OPTIONS
	RACK OR HEAD END	AV-AUDIO/VIDEO C-CONTROL D-DATA SEC-SECURITY
	LIFT/MOUNT	A-ARTICULATED M-MOTORISED UB-UNDER BED

EXAMPLES: SYMBOL + MOUNTING OPTION		
SYMBOL	NAME	MOUNT TYPE
	SPEAKER	CEILING MOUNTED
	SPEAKER	WALL MOUNTED
	SPEAKER	FLOOR MOUNTED
	PRE-WIRE SPEAKER	CEILING MOUNTED PRE-WIRE ONLY NO CUTOUT

CABLING OPTIONS			
	SPKR	2CX2.5 mm ²	SPEAKER CABLE
	COXL	COAXIAL	SUBWOOFER CABLE
	CAT6	CAT6	DATA CABLE
	HDMI	HDMI	VIDEO CABLE

Client : CLINICAL RETREAT

Location : ANAND

Created 06-06-2017
 Modified Not yet
 Printed Not yet

Drawing Name :
 ELEVATION


Drawing Type :
 PROJECTOR VIEWING

Drawing Scale : SCALE TO FIT

Designed by Ruchi

Checked by Ankur Bhatt

HC-052/3.13

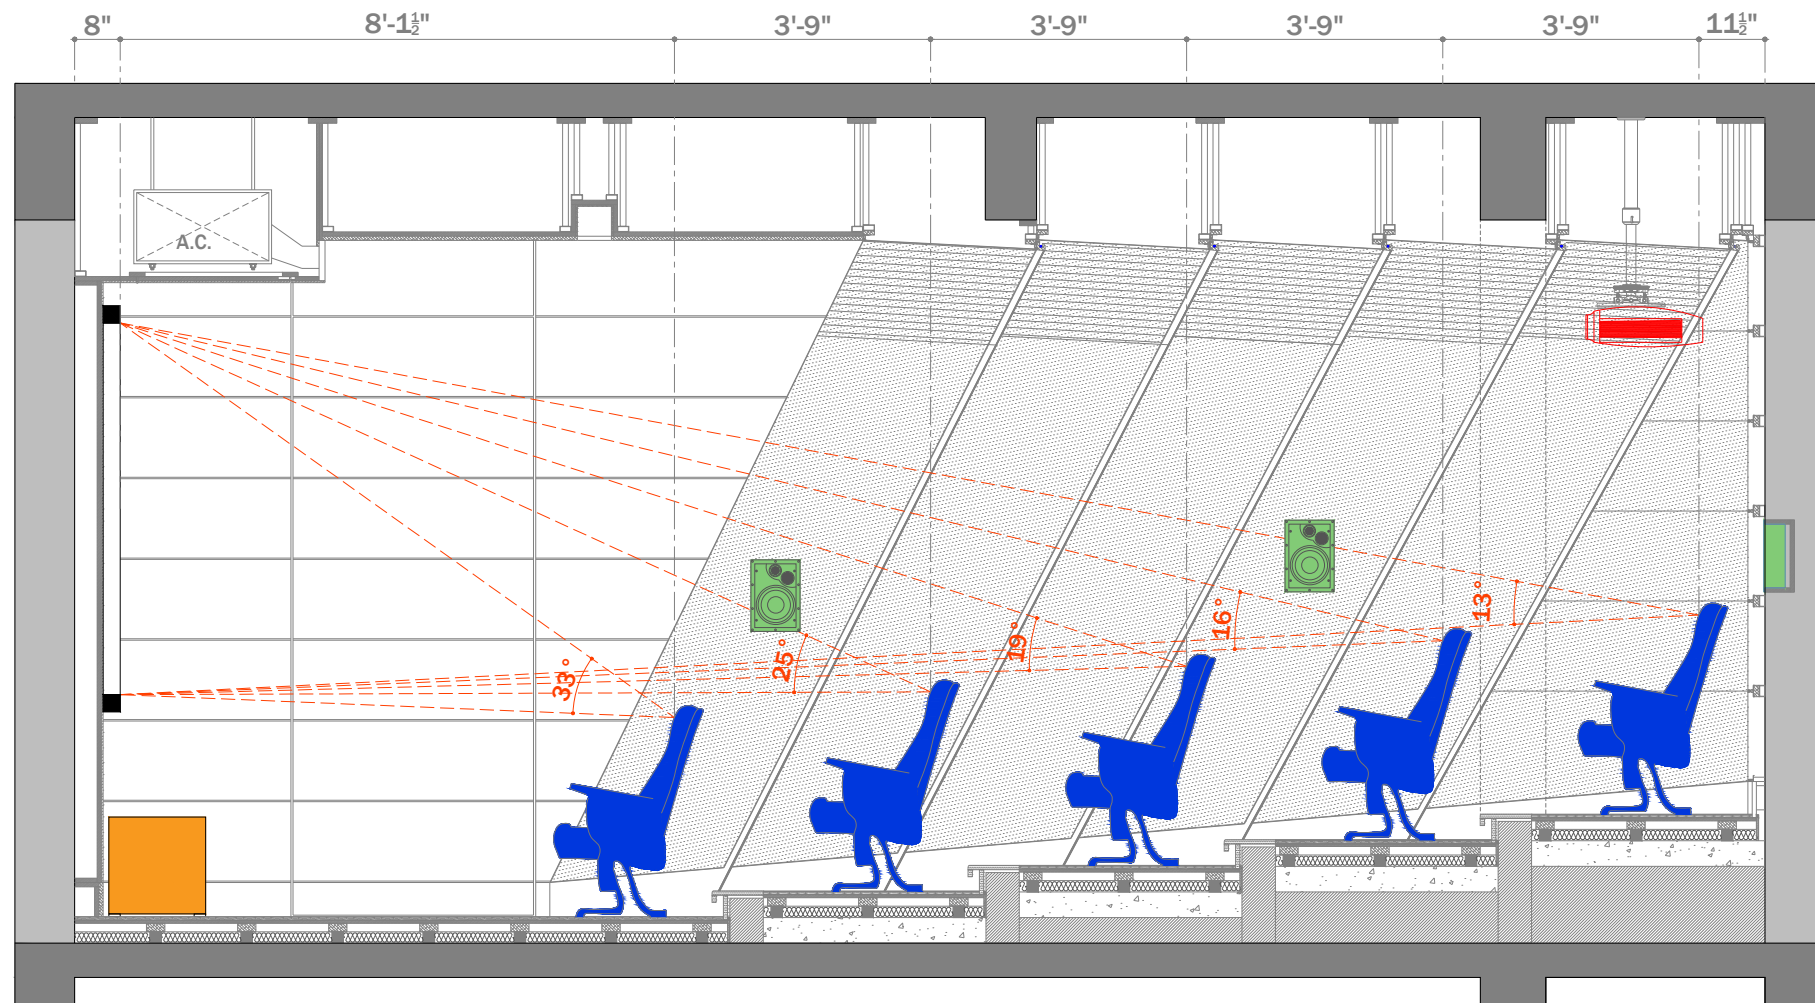

Right Side View

AUDIO VIDEO SYMBOLS		
SYMBOL	NAME	DO=DEVICE OPTIONS
	SPEAKER	LCR-LCR BAR SU-SUBWOOFER ST-STEREO
	VIDEO PROJECTOR	LCD-LIQUID CRYSTAL DISPLAY DLP-DIGITAL LIGHT PROCESSOR SXRD-SILICON X-TEL REF. DISP.
	PROJECTON SCREEN	F-FIXED M-MOTORISED

COMMUNICATIONS SYMBOLS		
SYMBOL	NAME	DO=DEVICE OPTIONS
	PHONE AND DATA PORT	D-DATA F-FIBRE OPTIC P-PHONE
	INCOMING SERVICES	CTV-CABLE TV P-PHONE S-SATELLITE
	RF REPEATER ACCESS POINT	CR-CELLUAR PR-PHONE WAP-WIRELESSACCESS POINT

FURNISHINGS SYMBOLS		
SYMBOL	NAME	DO=DEVICE OPTIONS
	RACK OR HEAD END	AV-AUDIO/VIDEO C-CONTROL D-DATA SEC-SECURITY
	LIFT/MOUNT	A-ARTICULATED M-MOTORISED UB-UNDER BED

EXAMPLES: SYMBOL + MOUNTING OPTION		
SYMBOL	NAME	MOUNT TYPE
	SPEAKER	CEILING MOUNTED
	SPEAKER	WALL MOUNTED
	SPEAKER	FLOOR MOUNTED
	PRE-WIRE SPEAKER	CEILING MOUNTED PRE-WIRE ONLY NO CUTOUT

CABLING OPTIONS			
	SPKR	2CX2.5 mm ²	SPEAKER CABLE
	COXL	COAXIAL	SUBWOOFER CABLE
	CAT6	CAT6	DATA CABLE
	HDMI	HDMI	VIDEO CABLE

Client : CLINICAL RETREAT

Location : ANAND

Created 06-06-2017
 Modified Not yet
 Printed Not yet

Drawing Name :
 ELEVATION


Drawing Type :
 VIEWING ANGLES

Drawing Scale : SCALE TO FIT

Designed by Ruchi

Checked by Ankur Bhatt

HC-052/3.14

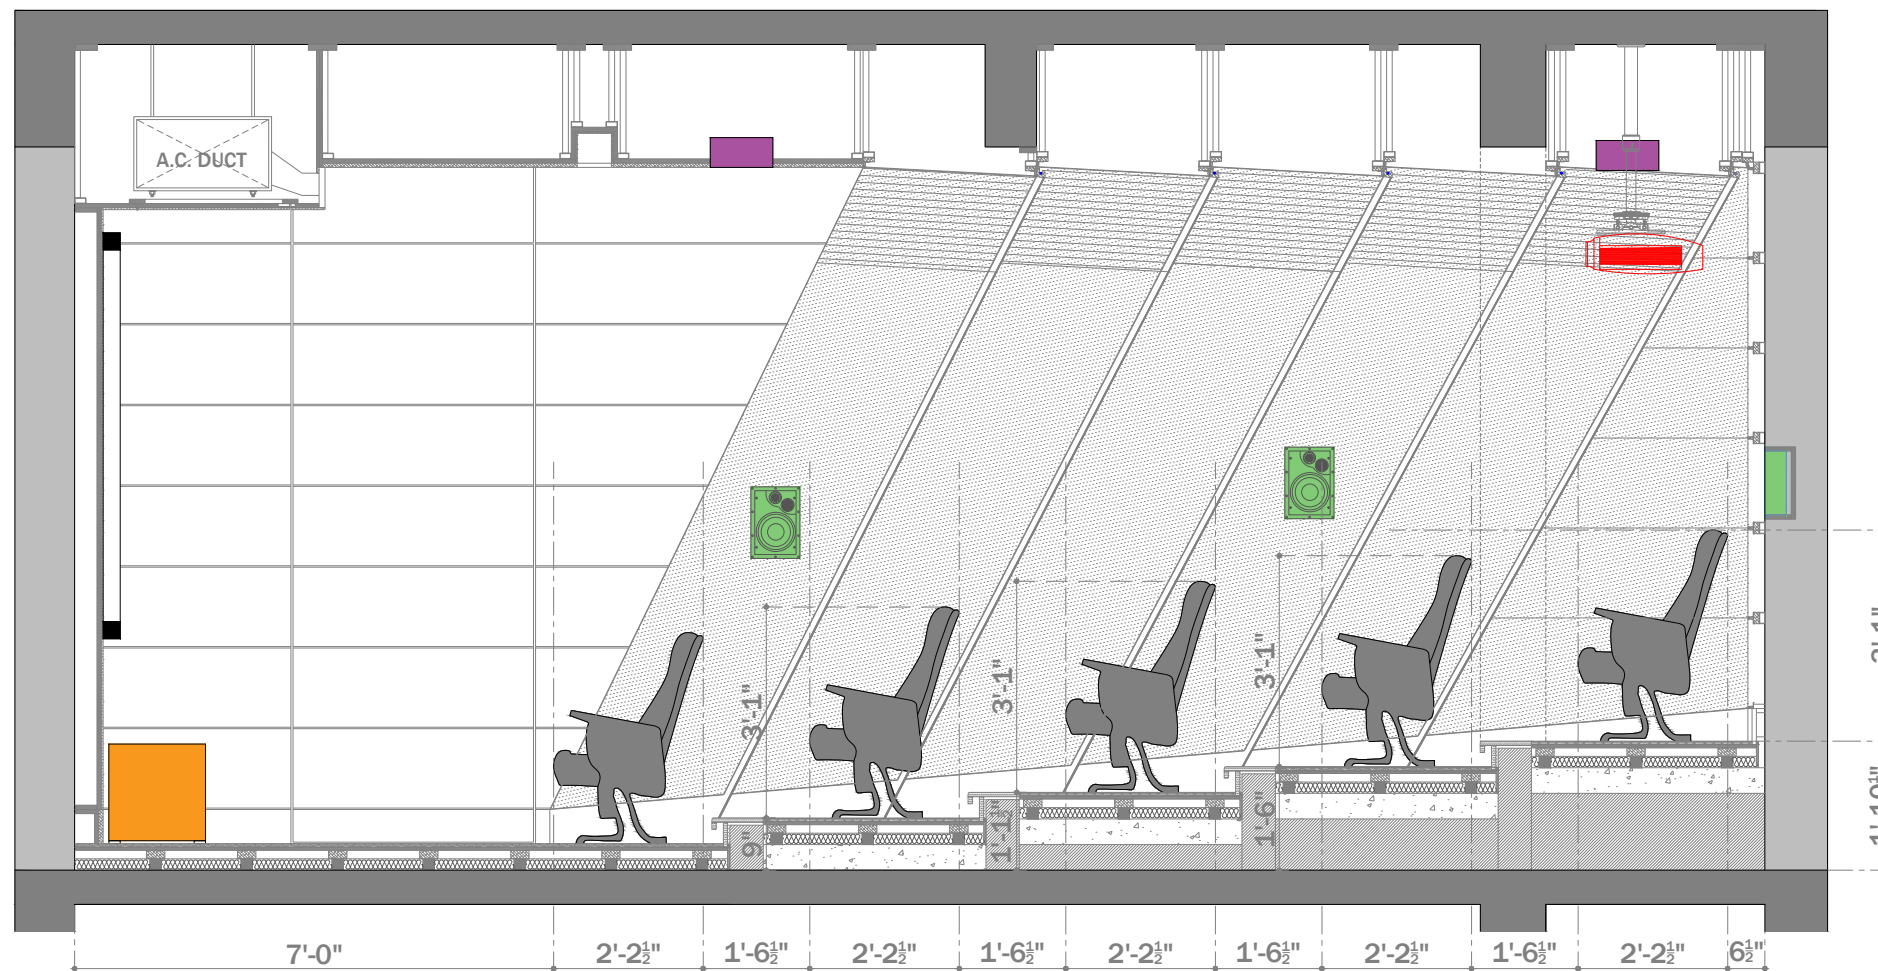

Right Side View

AUDIO VIDEO SYMBOLS			
SYMBOL	NAME	DO=DEVICE OPTIONS	
	SPEAKER	LCR-LCR BAR SU-SUBWOOFER ST-STEREO	
	VIDEO PROJECTOR	LCD-LIQUID CRYSTAL DISPLAY DLP-DIGITAL LIGHT PROCESSOR SXRD-SILICON X-TEL REF. DISP.	
	PROJECTON SCREEN	F-FIXED M-MOTORISED	
COMMUNICATIONS SYMBOLS			
SYMBOL	NAME	DO=DEVICE OPTIONS	
	PHONE AND DATA PORT	D-DATA F-FIBRE OPTIC P-PHONE	
	INCOMING SERVICES	CTV-CABLE TV P-PHONE S-SATELLITE	
	RF REPEATER ACCESS POINT	CR-CELLUAR PR-PHONE WAP-WIRELESSACCESS POINT	
FURNISHINGS SYMBOLS			
SYMBOL	NAME	DO=DEVICE OPTIONS	
	RACK OR HEAD END	AV-AUDIO/VIDEO C-CONTROL D-DATA SEC-SECURITY	
	LIFT/MOUNT	A-ARTICULATED M-MOTORISED UB-UNDER BED	
EXAMPLES: SYMBOL + MOUNTING OPTION			
SYMBOL	NAME	MOUNT TYPE	
	SPEAKER	CEILING MOUNTED	
	SPEAKER	WALL MOUNTED	
	SPEAKER	FLOOR MOUNTED	
	PRE-WIRE SPEAKER	CEILING MOUNTED PRE-WIRE ONLY NO CUTOUT	
CABLING OPTIONS			
	SPKR	2CX2.5 mm ²	SPEAKER CABLE
	COXL	COAXIAL	SUBWOOFER CABLE
	CAT6	CAT6	DATA CABLE
	HDMI	HDMI	VIDEO CABLE

Client : CLINICAL RETREAT

Location : ANAND

Created 06-06-2017
 Modified Not yet
 Printed Not yet

Drawing Name :
 ELEVATION


Drawing Type :
 SEATING PLACEMENT

Drawing Scale : SCALE TO FIT

Designed by Ruchi

Checked by Ankur Bhatt

HC-052/3.15

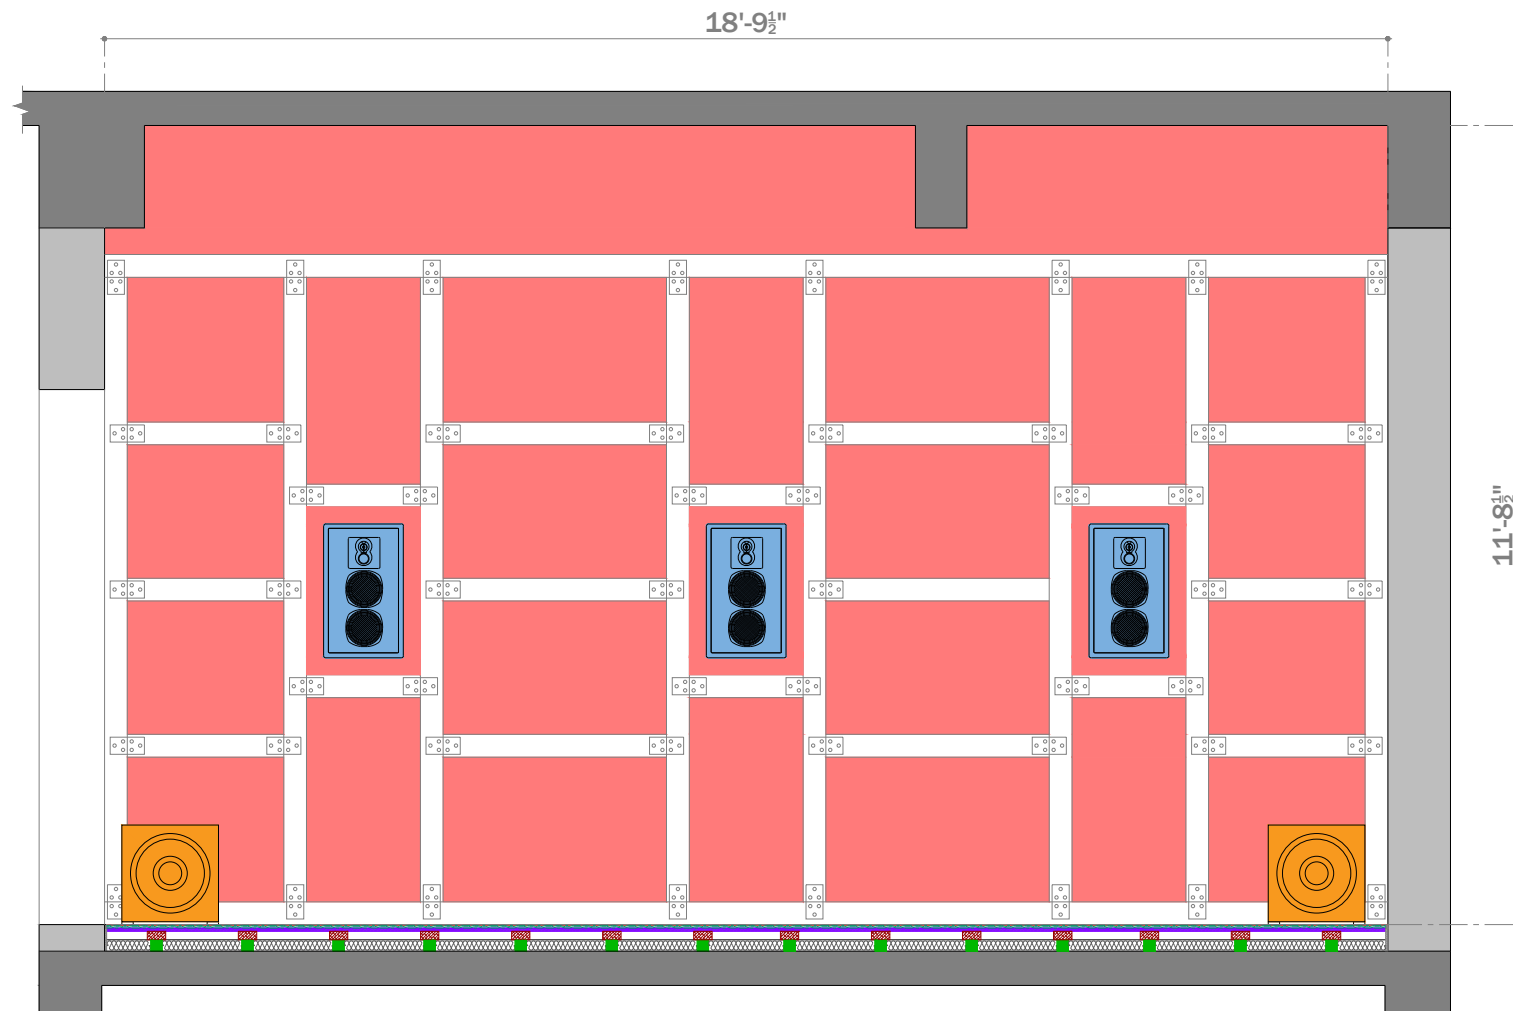

Front Side View

AUDIO VIDEO SYMBOLS			
SYMBOL	NAME	DO=DEVICE OPTIONS	
	SPEAKER	LCR-LCR BAR SU-SUBWOOFER ST-STEREO	
	VIDEO PROJECTOR	LCD-LIQUID CRYSTAL DISPLAY DLP-DIGITAL LIGHT PROCESSOR SXRD-SILICON X-TEL REF. DISP.	
	PROJECTION SCREEN	F-FIXED M-MOTORISED	
COMMUNICATIONS SYMBOLS			
SYMBOL	NAME	DO=DEVICE OPTIONS	
	PHONE AND DATA PORT	D-DATA F-FIBRE OPTIC P-PHONE	
	INCOMING SERVICES	CTV-CABLE TV P-PHONE S-SATELLITE	
	RF REPEATER ACCESS POINT	CR-CELLUAR PR-PHONE WAP-WIRELESSACCESS POINT	
FURNISHINGS SYMBOLS			
SYMBOL	NAME	DO=DEVICE OPTIONS	
	RACK OR HEAD END	AV-AUDIO/VIDEO C-CONTROL D-DATA SEC-SECURITY	
	LIFT/MOUNT	A-ARTICULATED M-MOTORISED UB-UNDER BED	
EXAMPLES: SYMBOL + MOUNTING OPTION			
SYMBOL	NAME	MOUNT TYPE	
	SPEAKER	CEILING MOUNTED	
	SPEAKER	WALL MOUNTED	
	SPEAKER	FLOOR MOUNTED	
	PRE-WIRE SPEAKER	CEILING MOUNTED PRE-WIRE ONLY NO CUTOUT	
CABLING OPTIONS			
	SPKR	2CX2.5 mm ²	SPEAKER CABLE
	COXL	COAXIAL	SUBWOOFER CABLE
	CAT6	CAT6	DATA CABLE
	HDMI	HDMI	VIDEO CABLE

Client : CLINICAL RETREAT

Location : ANAND

Created 06-06-2017
 Modified Not yet
 Printed Not yet

Drawing Name :
 ELEVATION


Drawing Type :
 ACOUSTICS

Drawing Scale : SCALE TO FIT

Designed by Ruchi

Checked by Ankur Bhatt

HC-052/3.16

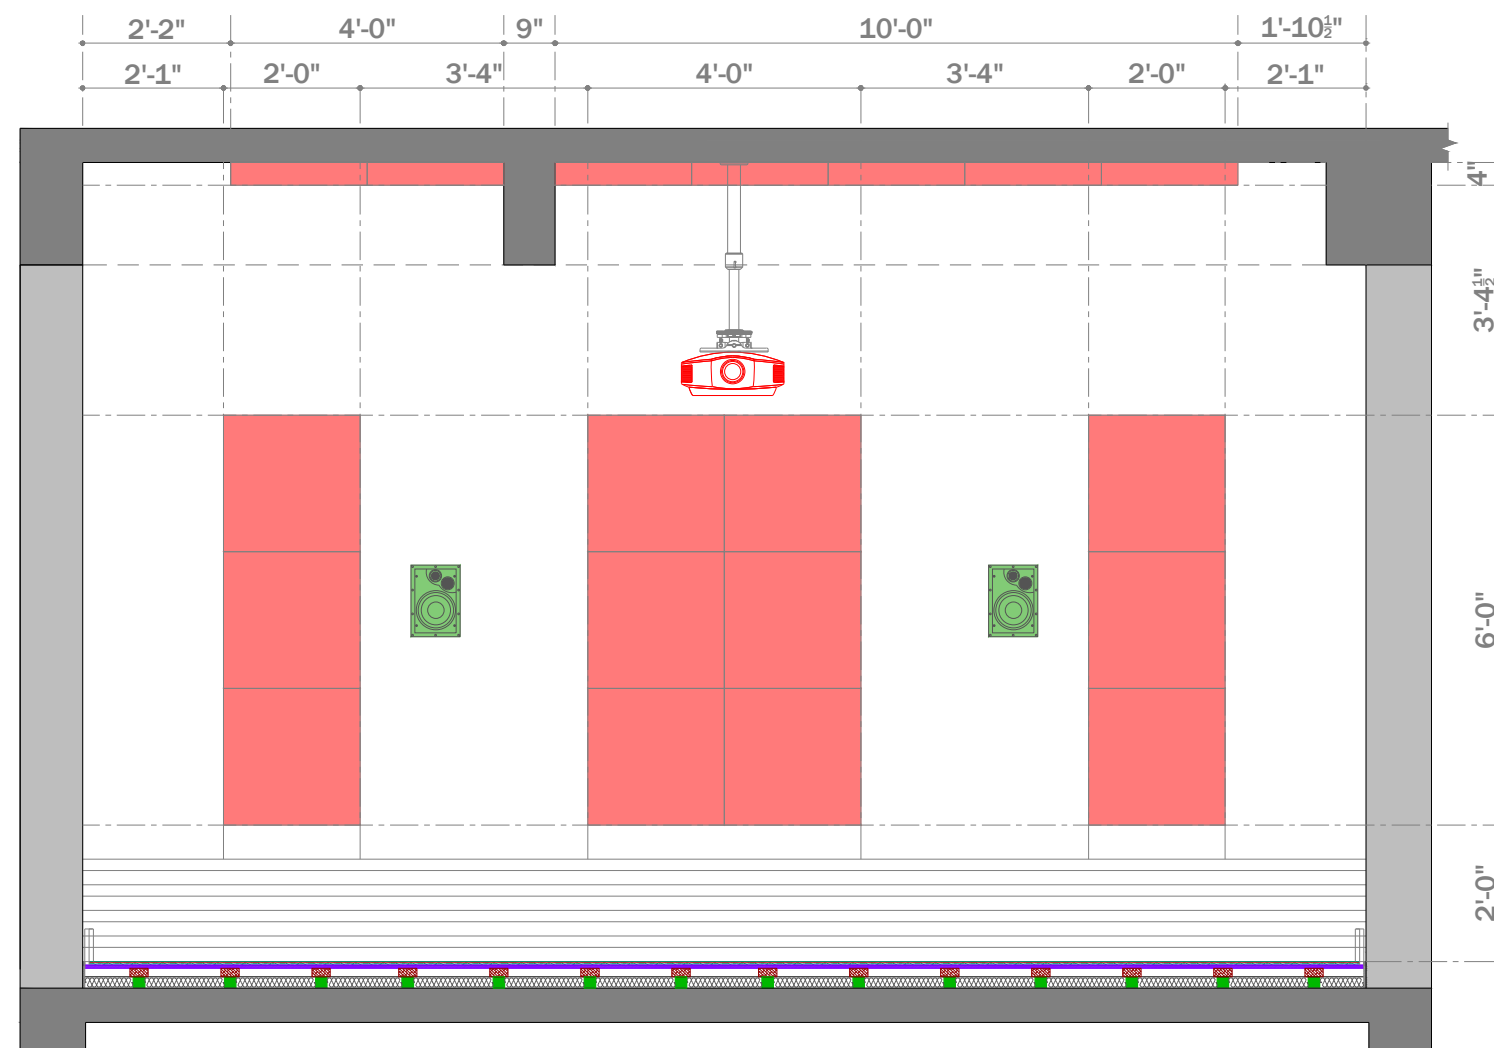

Rear Side View

AUDIO VIDEO SYMBOLS		
SYMBOL	NAME	DO=DEVICE OPTIONS
	SPEAKER	LCR-LCR BAR SU-SUBWOOFER ST-STEREO
	VIDEO PROJECTOR	LCD-LIQUID CRYSTAL DISPLAY DLP-DIGITAL LIGHT PROCESSOR SXRD-SILICON X-TEL REF. DISP.
	PROJECTON SCREEN	F-FIXED M-MOTORISED

COMMUNICATIONS SYMBOLS		
SYMBOL	NAME	DO=DEVICE OPTIONS
	PHONE AND DATA PORT	D-DATA F-FIBRE OPTIC P-PHONE
	INCOMING SERVICES	CTV-CABLE TV P-PHONE S-SATELLITE
	RF REPEATER ACCESS POINT	CR-CELLUAR PR-PHONE WAP-WIRELESSACCESS POINT

FURNISHINGS SYMBOLS		
SYMBOL	NAME	DO=DEVICE OPTIONS
	RACK OR HEAD END	AV-AUDIO/VIDEO C-CONTROL D-DATA SEC-SECURITY
	LIFT/MOUNT	A-ARTICULATED M-MOTORISED UB-UNDER BED

EXAMPLES: SYMBOL + MOUNTING OPTION		
SYMBOL	NAME	MOUNT TYPE
	SPEAKER	CEILING MOUNTED
	SPEAKER	WALL MOUNTED
	SPEAKER	FLOOR MOUNTED
	PRE-WIRE SPEAKER	CEILING MOUNTED PRE-WIRE ONLY NO CUTOUT

CABLING OPTIONS			
	SPKR	2CX2.5 mm ²	SPEAKER CABLE
	COXL	COAXIAL	SUBWOOFER CABLE
	CAT6	CAT6	DATA CABLE
	HDMI	HDMI	VIDEO CABLE

Client : CLINICAL RETREAT

Location : ANAND

Created 06-06-2017
Modified Not yet
Printed Not yet

Drawing Name :
ELEVATION


Drawing Type :
ACOUSTICS

Drawing Scale : SCALE TO FIT

Designed by Ruchi

Checked by Ankur Bhatt

HC-052/3.17

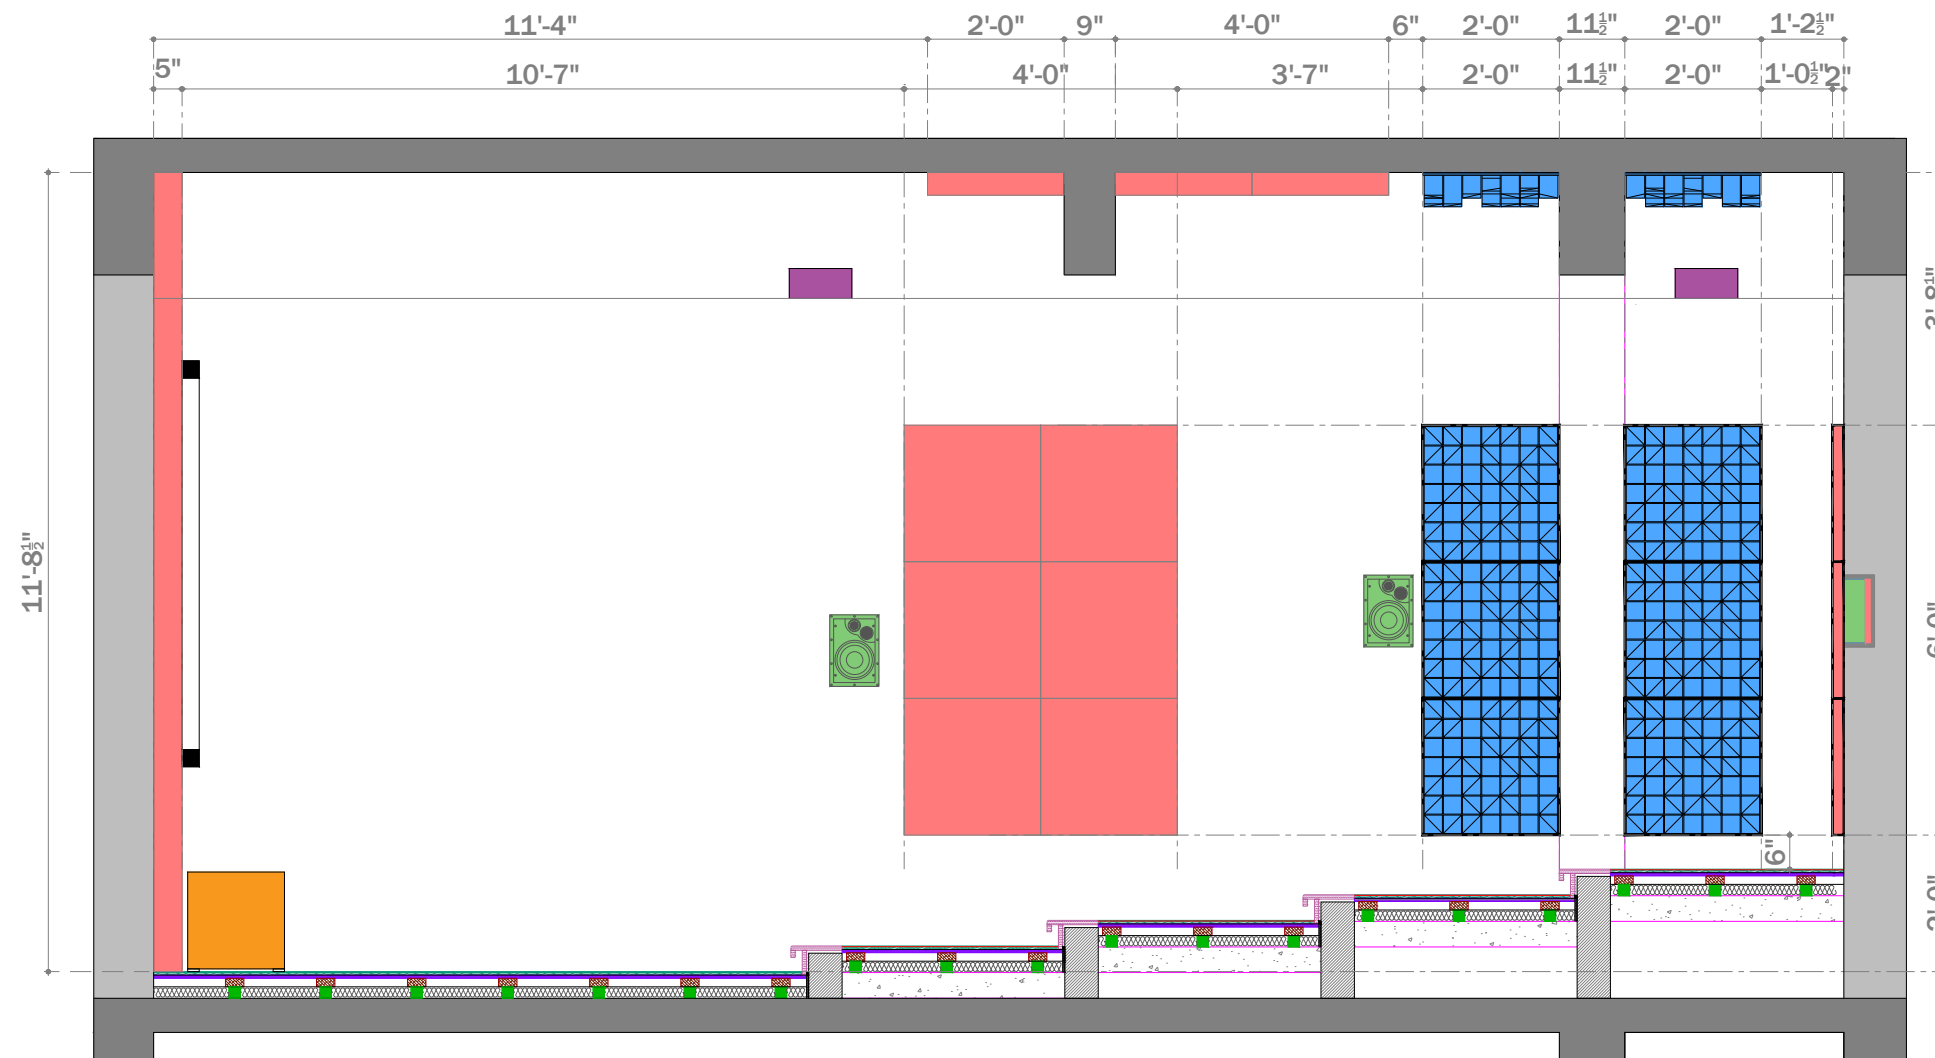

Right Side View

AUDIO VIDEO SYMBOLS			
SYMBOL	NAME	DO=DEVICE OPTIONS	
	SPEAKER	LCR-LCR BAR SU-SUBWOOFER ST-STEREO	
	VIDEO PROJECTOR	LCD-LIQUID CRYSTAL DISPLAY DLP-DIGITAL LIGHT PROCESSOR SXRD-SILICON X-TEL REF. DISP.	
	PROJECTON SCREEN	F-FIXED M-MOTORISED	
COMMUNICATIONS SYMBOLS			
SYMBOL	NAME	DO=DEVICE OPTIONS	
	PHONE AND DATA PORT	D-DATA F-FIBRE OPTIC P-PHONE	
	INCOMING SERVICES	CTV-CABLE TV P-PHONE S-SATELLITE	
	RF REPEATER ACCESS POINT	CR-CELLUAR PR-PHONE WAP-WIRELESSACCESS POINT	
FURNISHINGS SYMBOLS			
SYMBOL	NAME	DO=DEVICE OPTIONS	
	RACK OR HEAD END	AV-AUDIO/VIDEO C-CONTROL D-DATA SEC-SECURITY	
	LIFT/MOUNT	A-ARTICULATED M-MOTORISED UB-UNDER BED	
EXAMPLES: SYMBOL + MOUNTING OPTION			
SYMBOL	NAME	MOUNT TYPE	
	SPEAKER	CEILING MOUNTED	
	SPEAKER	WALL MOUNTED	
	SPEAKER	FLOOR MOUNTED	
	PRE-WIRE SPEAKER	CEILING MOUNTED PRE-WIRE ONLY NO CUTOUT	
CABLING OPTIONS			
	SPKR	2CX2.5 mm ²	SPEAKER CABLE
	COXL	COAXIAL	SUBWOOFER CABLE
	CAT6	CAT6	DATA CABLE
	HDMI	HDMI	VIDEO CABLE

Client : CLINICAL RETREAT

Location : ANAND

Created 06-06-2017
 Modified Not yet
 Printed Not yet

Drawing Name :
 ELEVATION


Drawing Type :
 ACOUSTICS

Drawing Scale : SCALE TO FIT

Designed by Ruchi

Checked by Ankur Bhatt

HC-052/3.18

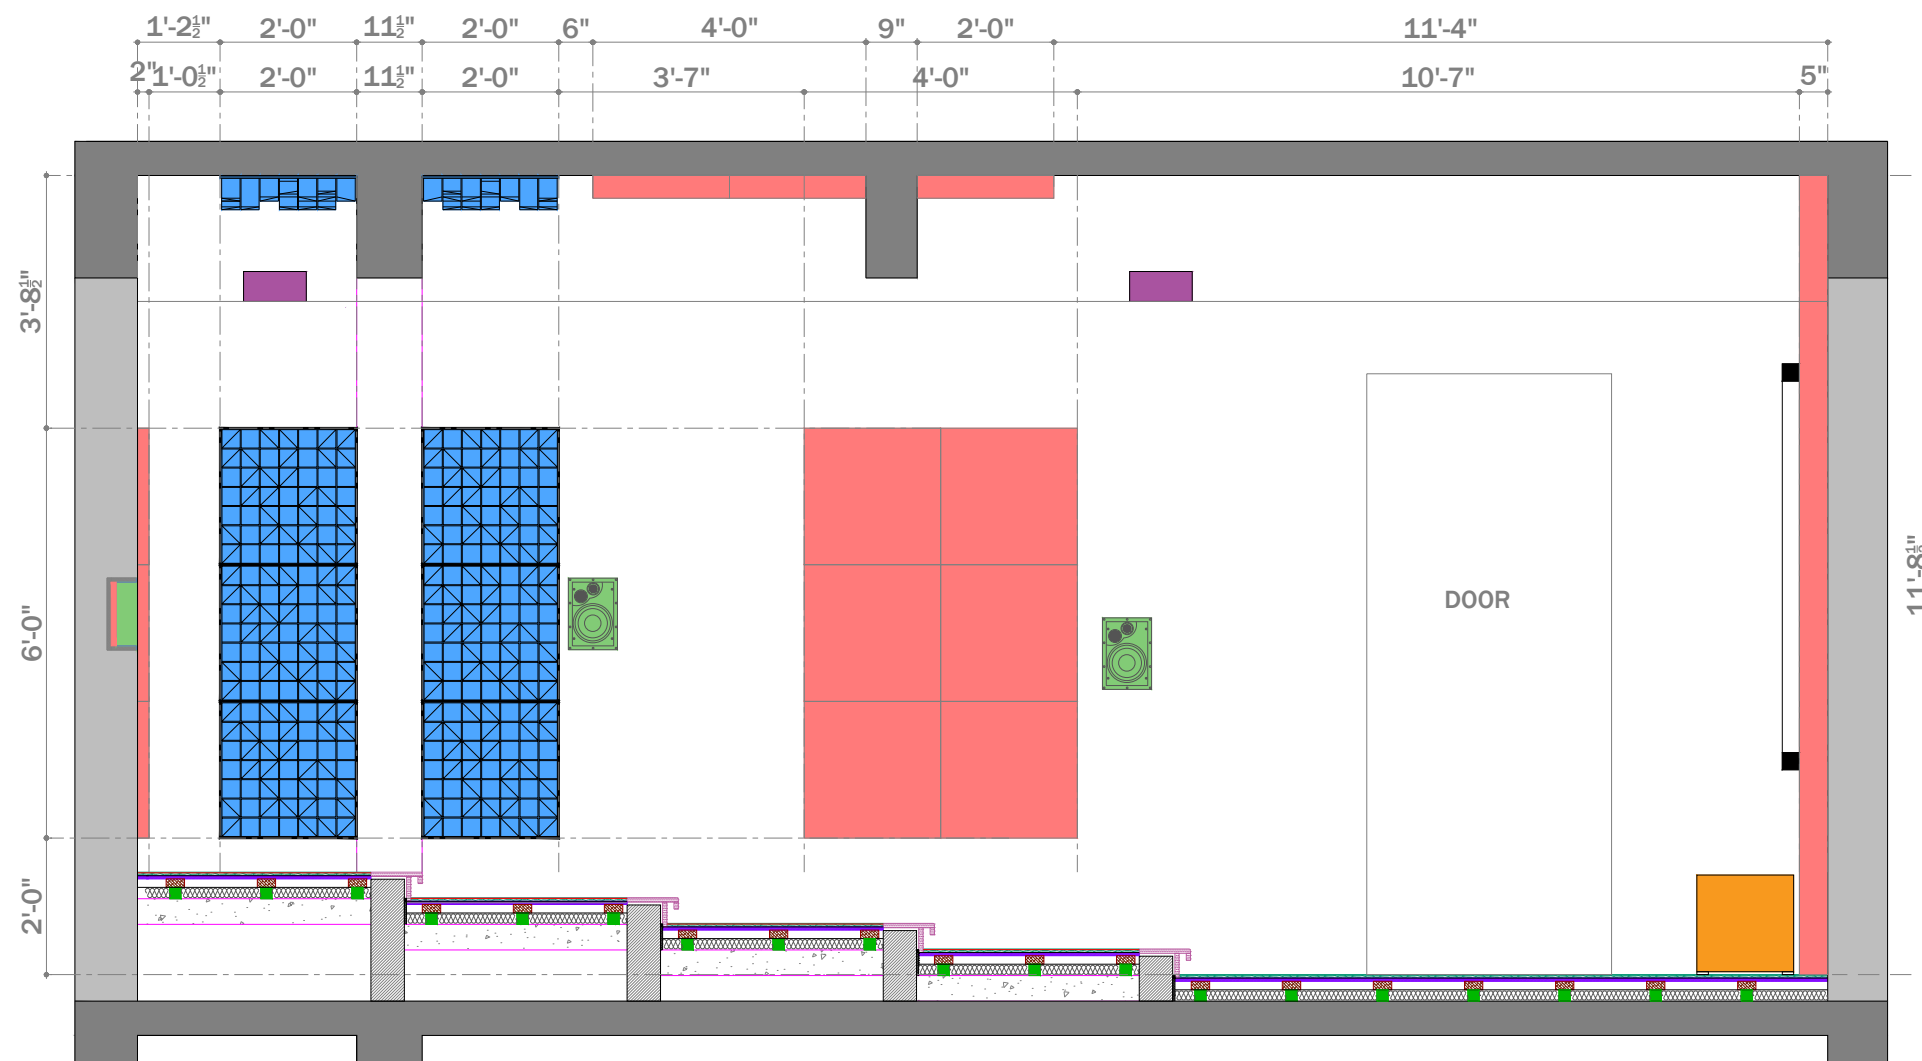

Left Side View

AUDIO VIDEO SYMBOLS		
SYMBOL	NAME	DO=DEVICE OPTIONS
	SPEAKER	LCR-LCR BAR SU-SUBWOOFER ST-STEREO
	VIDEO PROJECTOR	LCD-LIQUID CRYSTAL DISPLAY DLP-DIGITAL LIGHT PROCESSOR SXRD-SILICON X-TEL REF. DISP.
	PROJECTOR SCREEN	F-FIXED M-MOTORISED

COMMUNICATIONS SYMBOLS		
SYMBOL	NAME	DO=DEVICE OPTIONS
	PHONE AND DATA PORT	D-DATA F-FIBRE OPTIC P-PHONE
	INCOMING SERVICES	CTV-CABLE TV P-PHONE S-SATELLITE
	RF REPEATER ACCESS POINT	CR-CELLUAR PR-PHONE WAP-WIRELESSACCESS POINT

FURNISHINGS SYMBOLS		
SYMBOL	NAME	DO=DEVICE OPTIONS
	RACK OR HEAD END	AV-AUDIO/VIDEO C-CONTROL D-DATA SEC-SECURITY
	LIFT/MOUNT	A-ARTICULATED M-MOTORISED UB-UNDER BED

EXAMPLES: SYMBOL + MOUNTING OPTION		
SYMBOL	NAME	MOUNT TYPE
	SPEAKER	CEILING MOUNTED
	SPEAKER	WALL MOUNTED
	SPEAKER	FLOOR MOUNTED
	PRE-WIRE SPEAKER	CEILING MOUNTED PRE-WIRE ONLY NO CUTOUT

CABLING OPTIONS			
	SPKR	2CX2.5 mm ²	SPEAKER CABLE
	COXL	COAXIAL	SUBWOOFER CABLE
	CAT6	CAT6	DATA CABLE
	HDMI	HDMI	VIDEO CABLE

Client : CLINICAL RETREAT

Location : ANAND

Created 06-06-2017
 Modified Not yet
 Printed Not yet

Drawing Name :
 ELEVATION

Drawing Type :
 ACOUSTICS

Drawing Scale : SCALE TO FIT

Designed by Ruchi

Checked by Ankur Bhatt

HC-052/3.19

CABLING INFORMATION

IT IS ESSENTIAL THAT THE FOLLOWING INFORMATION IS READ AND UNDERSTOOD TO ENSURE THE SYSTEMS SUPPLIED AND INSTALLED PERFORM TO THE HIGHEST STANDARD

1: MAIN CONTRACTOR TO UNDERTAKE THE FOLLOWING:

- 1.1: ENSURE ALL SUB-CONTRACTORS ARE AWARE OF THE STANDARDS AS SET OUT HERE.
- 1.2: ENSURE THAT ALL CABLES ARE STORED IN DRY SURROUNDINGS AT TEMPRATURES NOT LOWER THAN 5C.
- 1.3: NOTIFY WHEN ALL CABLING AND BACK BOXES HAVE BEEN INSTALLED AND CUT OUTS HAVE BEEN ,ADE FOR SPEAKERS SO TESTING AND CERTIFICATION CAN COMMENCE

2: ELECTRICAL CONTRACTOR TO UNDERTAKE THE FOLLOWING:

- 2.1: INSTALL ALL ULTRA LOW VOLTAGE ELECTRICAL CABLING TO THE CORRECT POSITIONS AS INDICATED WITHIN THIS SITE PACK.
- 2.2: ALL CABLING TO BE CLEARLY LABELED AT BOTH ENDS ONLY WITH THE CABLE ID'S SHOWN WITHIN THIS SITE PACK - FAILURE TO CORRECTLY LABEL THE CABLING MAY RESULT IN ADDITIONAL CHARGES BEING MADE TO THE CLIENT.
- 2.3: SUPPLY AND FIT ALL BACK BOXES AS DETAILED WITHIN THIS SITE PACK. NOTE THAT HEIGHTS AND POSITIONS OF BACK BOXES ARE INDICATED WITHIN THIS SITE PACK BUT ARE SUBJECT TO CONFIRMATION BY THE ARCHITECT.
- 2.4: CUT OUT ALL IN-CEILING AND IN-WALL SPEAKER POSITIONS AS INDICATED WITHIN THIS SITE PACK - CUT OUT DETAILS WILL BE PROVIDED UPON REQUEST.
- 2.5: INSTALL ANY ADDITIONAL MAINS SUPPLIES AS INDICATED WITHIN THIS SITE PACK.
- 2.6: IN THE CASE OF A LIGHTING CONTROL SYSTEM OR MAINS VOLTAGE RELAYS/CONTROLS, THE ELECTRICAL CONTRACTOR SHALL BE RESPONSIBLE FOR ALL TERMINATIONS OF THE HIGH VOLTAGE SYSTEMS IN LINE WITH CUTRRENT BUILDING/ELECTRICAL REGULATIONS.
- 2.7: LEAVE ALL CABLES LOOSELY COILED 1M ABOVE FEL (FINISHED FLOOR LEVEL) TO AVOID CRUSHING, DAMP, AND COLD.

3: WE ASK THAT THE FOLLOWING STANDARDS ARE FOLLOEWD TO ENSURE THE PERFORMANCE OF THE STRUCTURED CABLING:

- 3.1: IN ORDER TO REDUCE ELECTRO-MAGNETIC INTERFERENCE, ALL ULTRA LOW VOLTAGE CABLING IS TO BE RUN AT LEAST 500MM FROM ANY LOW VOLTAGE (MAINS 120-230V) CABLING.
- 3.2: WHERE ULTRA LOW VOLTAGE CABLING CROSSES LOW VOLTAGE CABLING (MAINS 120-230V), IT SHOULD DO SO AT 90 DEGREES (RIGHT ANGLES).
- 3.3: IT IS NOT RECOMMENDED THAT ANY ULTRA LOW VOLTAGE CABLING IS BENT AT A RADIUS OF LESS THAN 60MM.
- 3.4: NO ULTRA LOW VOLTAGE CABLING SHOULD BE EXPOSED TO A PULLING TENSION IN EXCESS OF 10N.
- 3.5: UNLESS OTHERWISE INDICATED, AT EQUIPMENT POSITIONS/HEAD END, AT LEAST 5M OF SPARE CABLE SHOULD BE LEFT (FROM FLOOR OR CEILING LEVEL).
- 3.6: UNLESS OTHERWISE INDICATED, PLEASE LEAVE 1M OF SPARE CABLE AT ANY WALL OUTLET/CONTROL POINT.
- 3.7: AT CEILING SPEAKER LOCATIONS, PLEASE LEAVE 1M OF SPARE CABLE UNLESS OTHERWISE INDICATED - PLEASE LEAVE 2M LOOPS WHERE LOOPS ARE INDICATED.
- 3.8: IT IS NOT RECOMMENDED THAT ANY OPTICAL FIBRE CABLE IS BENT AT A RADIUS OF LESS THAN 200MM.
- 3.9: IT IS RECOMMENDED THAT OPTICAL FIBRE CABLE IS ONLY CUT WITH APPROVED FIBRE CUTTING TOOLS.

NO ALTERATIONS ARE TO BE MADE WITHOUT PRIOR CONSULTATION.

EXPLANATION OF CABLE TEXT ELEMENTS:

CABLE ID: AA-S-02 - LOWEST FLOOR (A) TOP LEFT ROOM (A) SPEAKER CABLE (S) ID NUMBER (02)
 CABLE TYPE: SPEAKER 2 - 2 CORE SPEAKER CABLE
 CABLE DESTINATION: HE: AV-AUDIO/VIDEO HEAD END

EXPLANATION OF SYMBOLS

TWO TEXT ATTRIBUTES ARE USED TO DESCRIBE SYBOLS AS SHOWN:

SYMBOL	NAME	DO = DEVICE OPTIONS
	SPEAKER	LCR-LCR BAR S-SUBWOOFER ST-STEREO

DO = DEVICE OPTIOS - KEY DESCRIOION OF THE TECHNOLOGY
 UNIQUE TO EACH SYMBOL.SEE

ABOVE FOR EXAMPLES AND MAIN LEGEND FOR DEVICE OPTIONS FOR EACH SYMBOL

ID = ID REFERENCE - ALPHANUMERIC CHARACTERS IDENTIFYING THE SYMBOL. FORMAT XX-YY-00

YY = ITEM CODE (SP = SPEAKER, KP = KEYPAD, DT = DIGITAL TELEVISION, ETC.).

XX = ROOM ID (FLOORS ARE LABELLED WITH A LETTERS STARTING WITH A FOR THE LOWEST FLOOR, ROOMS ARE GIVEN A LETTER STARTING WITH A FOR TOP LEFT ROOM THEN GOING IN ROWS AS IF RESDING A BOOK, SO AA IS TOP LEFT ROOM ON THE LOWEST FLOOR).

00 = UNIQUE ITEM ID NUMBER (01-99)
 E.G. AA-SP-01 = LOWEST FLOOR/TOP LEFT ROOM-SPEAKER-1

THREE SHAPE OUTLINES ARE USED TO DESCRIBE THE MOUNTING OF DEVICE AS SHOWN:


MOUNTING OPTIONS		
	CEILING MOUNTED	MOUNTED ON CEILING OR CUT INTO CEILING
	WALL MOUNTED	MOUNTED ON OR IN WALL HEIGHT AS INDICATED IN ELEVATIONS OR AS MARKED
	FLOOR MOUNTED	MOUNTED IN FLOOR OR FREESTANDING

EXAMPLES: SYMBOL + MOUNTING OPTION

SYMBOL	NAME	MOUNT TYPE
	SPEAKER	CEILING MOUNTED
	SPEAKER	WALL MOUNTED
	SPEAKER	FLOOR MOUNTED

ITEMS THAT WILL NOT BE INSTALLED BUT STILL REQUIRE WIRES RUNNING FOR FUTURE USE OR INSTALLATION ARE INDICATED WITH A BLACK SURROUNDING BOX AS SHOWN BELOW:

SYMBOL	NAME	DO = DEVICE OPTIONS
	PRE-WIRE SPEAKER	ALL DEVICE OPTIONS AS PER MAIN SYMBOLS

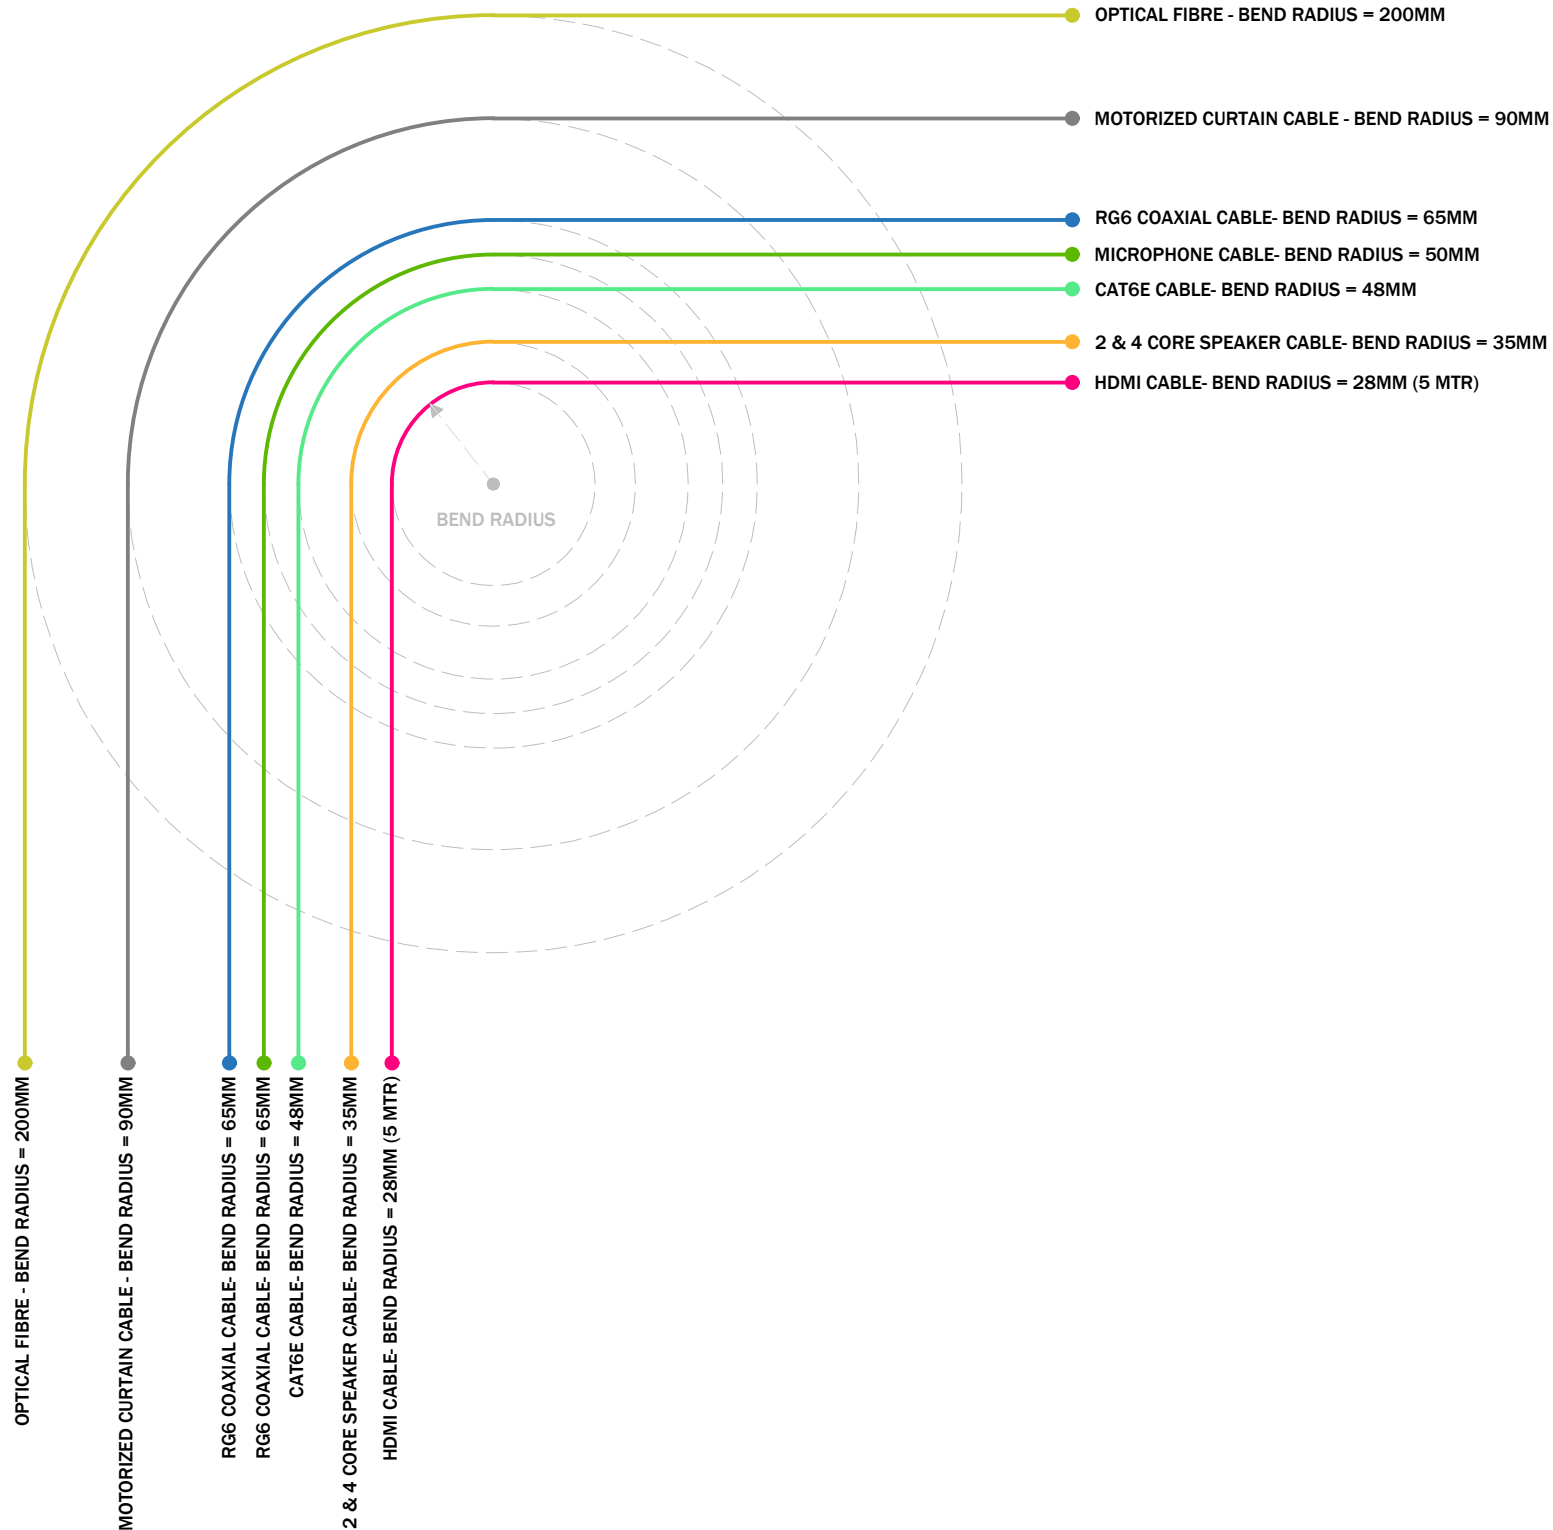

AUDIO VIDEO SYMBOLS		
SYMBOL	NAME	DO=DEVICE OPTIONS
	SPEAKER	LCR-LCR BAR SU-SUBWOOFER ST-STEREO
	VIDEO PROJECTOR	LCD-LIQUID CRYSTAL DISPLAY DLP-DIGITAL LIGHT PROCESSOR SXRD-SILICON X-TEL REF. DISP.
	PROJECTON SCREEN	F-FIXED M-MOTORISED

COMMUNICATIONS SYMBOLS		
SYMBOL	NAME	DO=DEVICE OPTIONS
	PHONE AND DATA PORT	D-DATA F-FIBRE OPTIC P-PHONE
	INCOMING SERVICES	CTV-CABLE TV P-PHONE S-SATELLITE
	RF REPEATER ACCESS POINT	CR-CELLUAR PR-PHONE WAP-WIRELESSACCESS POINT

FURNISHINGS SYMBOLS		
SYMBOL	NAME	DO=DEVICE OPTIONS
	RACK OR HEAD END	AV-AUDIO/VIDEO C-CONTROL D-DATA SEC-SECURITY
	LIFT/MOUNT	A-ARTICULATED M-MOTORISED UB-UNDER BED

EXAMPLES: SYMBOL + MOUNTING OPTION		
SYMBOL	NAME	MOUNT TYPE
	SPEAKER	CEILING MOUNTED
	SPEAKER	WALL MOUNTED
	SPEAKER	FLOOR MOUNTED
	PRE-WIRE SPEAKER	CEILING MOUNTED PRE-WIRE ONLY NO CUTOUT

CABLING OPTIONS			
	SPKR	2CX2.5 mm²	SPEAKER CABLE
	COXL	COAXIAL	SUBWOOFER CABLE
	CAT6	CAT6	DATA CABLE
	HDMI	HDMI	VIDEO CABLE

Client : CLINICAL RETREAT

Location : ANAND

Created 08-06-2017
 Modified Not yet
 Printed Not yet

Drawing Name :
 GENERAL NOTES


Drawing Type :
 GENERAL NOTES

Drawing Scale : SCALE TO FIT

Designed by Ruchi

Checked by Ankur Bhatt

HC-052/4

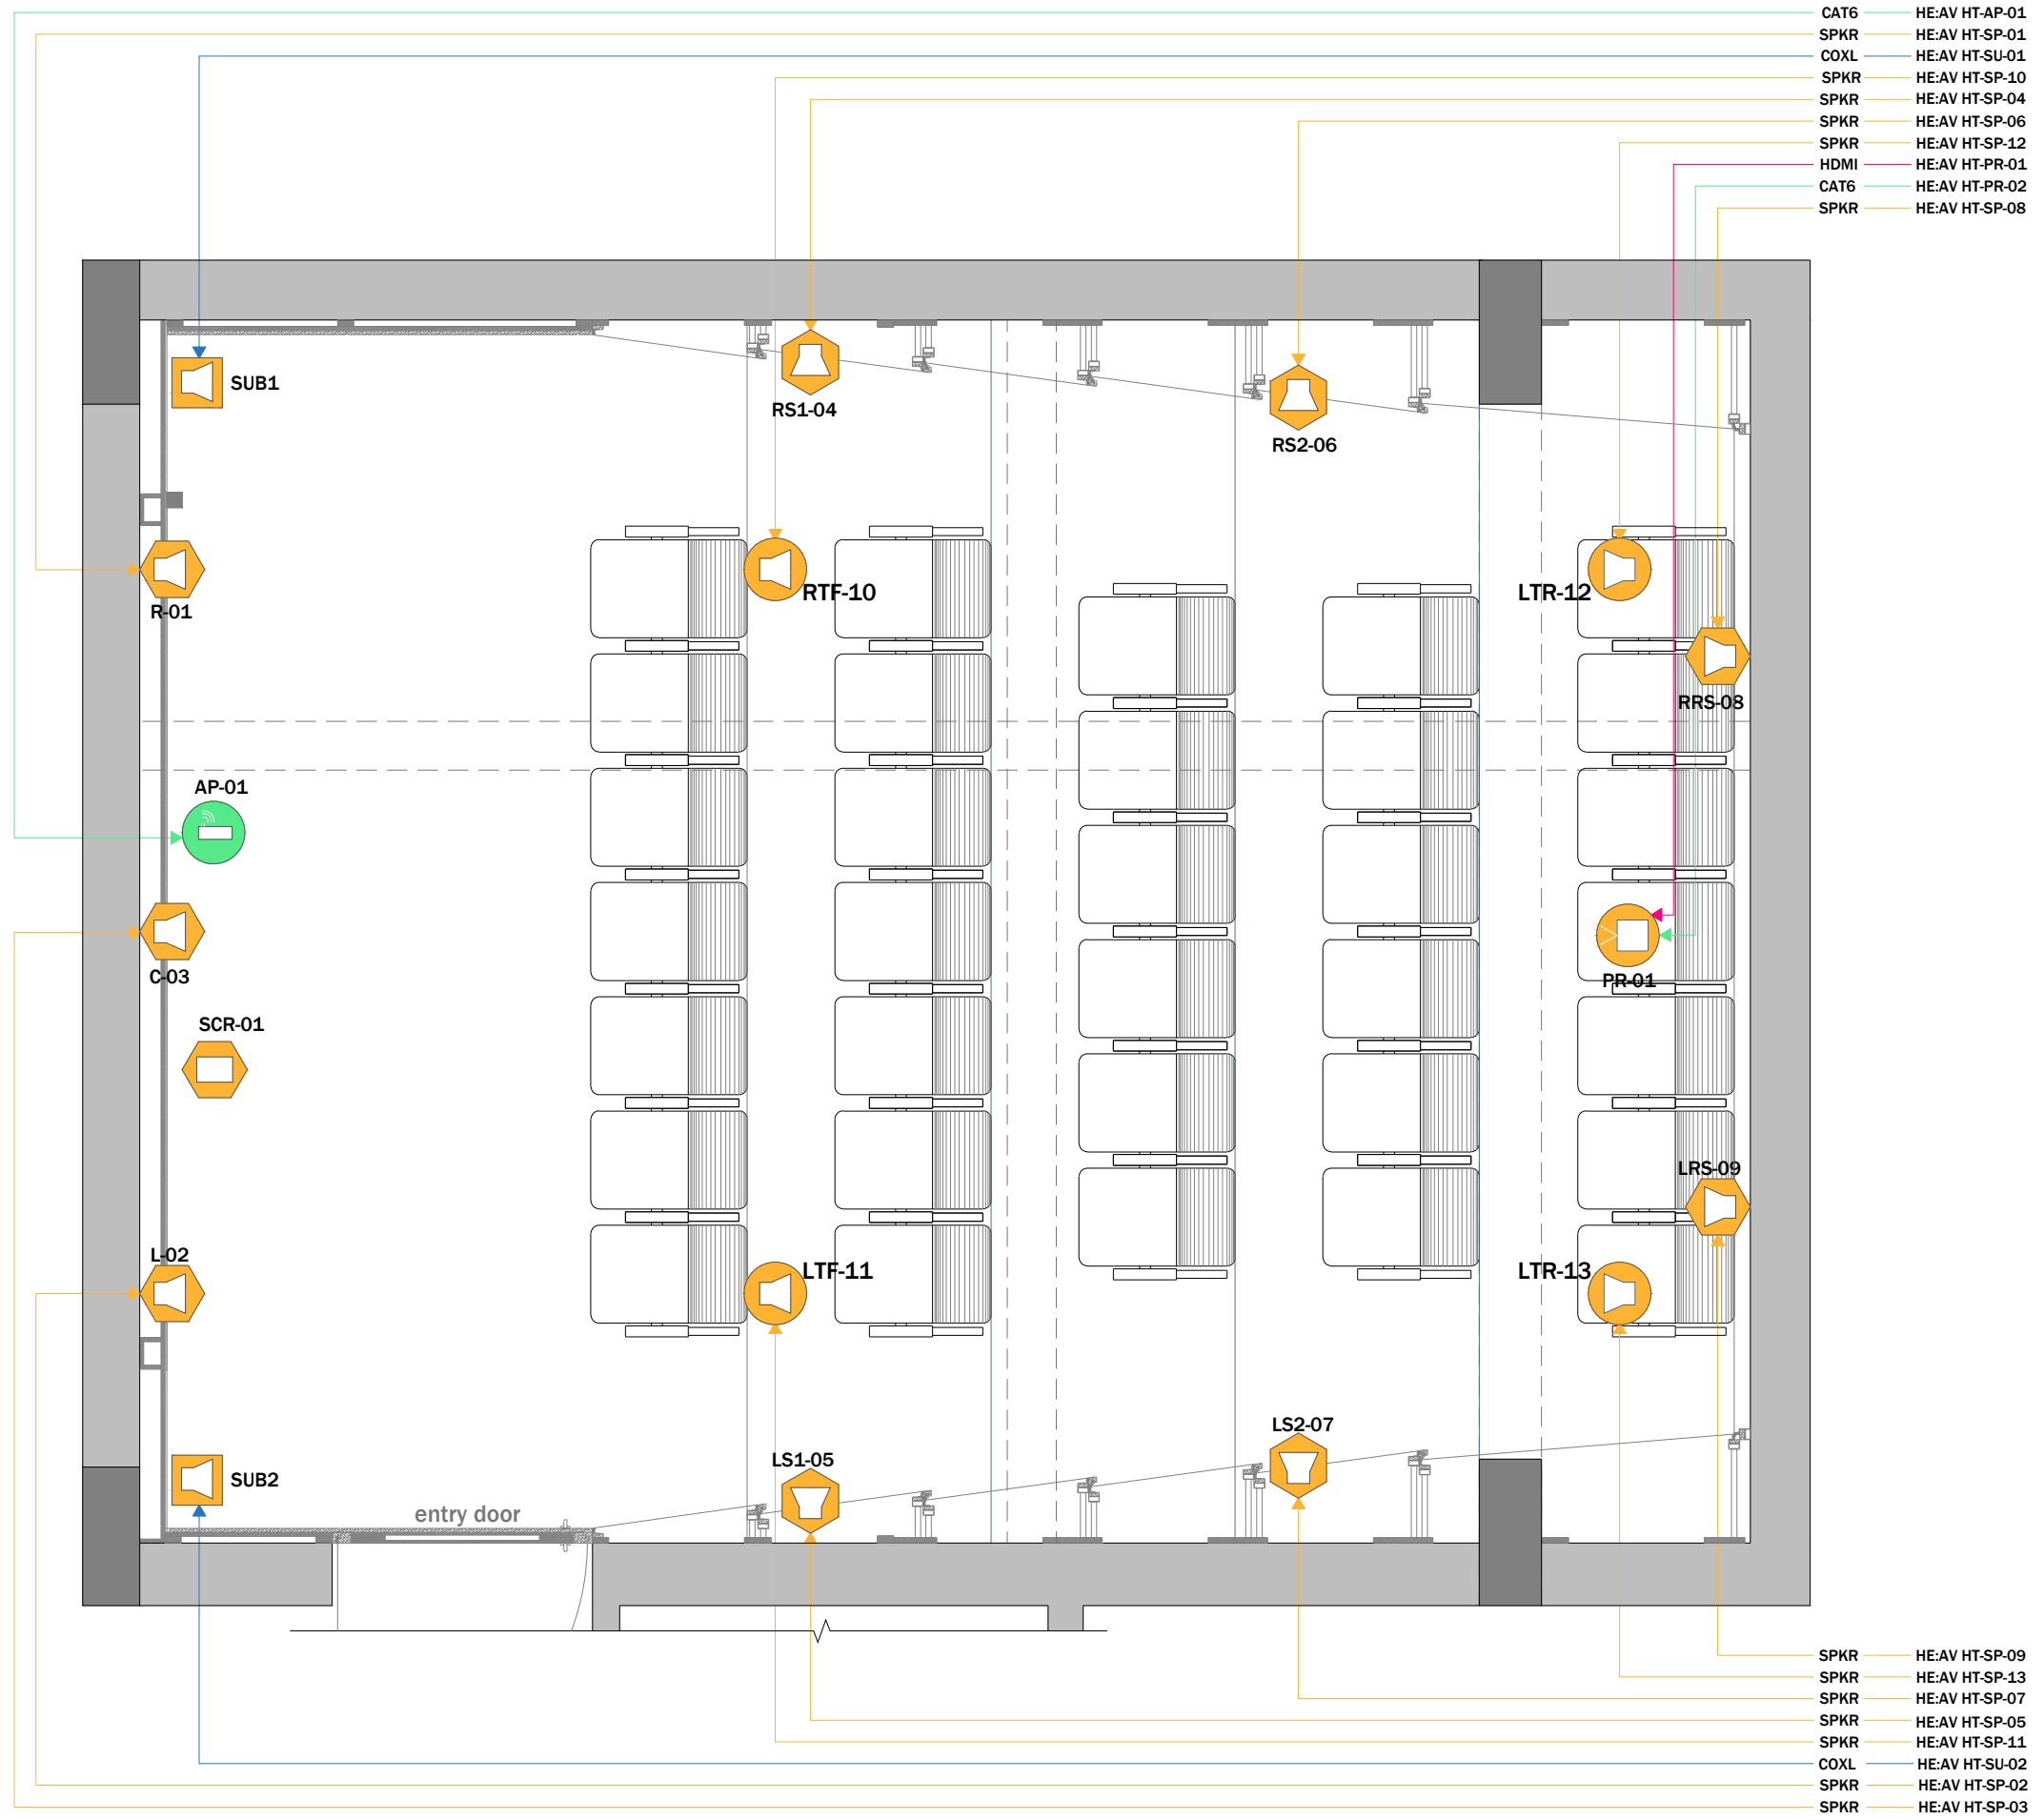

- CAT6 HE:AV HT-AP-01
- SPKR HE:AV HT-SP-01
- COXL HE:AV HT-SU-01
- SPKR HE:AV HT-SP-10
- SPKR HE:AV HT-SP-04
- SPKR HE:AV HT-SP-06
- SPKR HE:AV HT-SP-12
- HDMI HE:AV HT-PR-01
- CAT6 HE:AV HT-PR-02
- SPKR HE:AV HT-SP-08

- SPKR HE:AV HT-SP-09
- SPKR HE:AV HT-SP-13
- SPKR HE:AV HT-SP-07
- SPKR HE:AV HT-SP-05
- SPKR HE:AV HT-SP-11
- COXL HE:AV HT-SU-02
- SPKR HE:AV HT-SP-02
- SPKR HE:AV HT-SP-03

AUDIO VIDEO SYMBOLS		
SYMBOL	NAME	DO=DEVICE OPTIONS
	SPEAKER	LCR-LCR BAR SU-SUBWOOFER ST-STEREO
	VIDEO PROJECTOR	LCD-LIQUID CRYSTAL DISPLAY DLP-DIGITAL LIGHT PROCESSOR SXRD-SILICON X-TEL REF. DISP.
	PROJECTON SCREEN	F-FIXED M-MOTORISED

COMMUNICATIONS SYMBOLS		
SYMBOL	NAME	DO=DEVICE OPTIONS
	PHONE AND DATA PORT	D-DATA F-FIBRE OPTIC P-PHONE
	INCOMING SERVICES	CTV-CABLE TV P-PHONE S-SATELLITE
	RF REPEATER ACCESS POINT	CR-CELLUAR PR-PHONE WAP-WIRELESSACCESS POINT

FURNISHINGS SYMBOLS		
SYMBOL	NAME	DO=DEVICE OPTIONS
	RACK OR HEAD END	AV-AUDIO/VIDEO C-CONTROL D-DATA SEC-SECURITY
	LIFT/MOUNT	A-ARTICULATED M-MOTORISED UB-UNDER BED

EXAMPLES: SYMBOL + MOUNTING OPTION		
SYMBOL	NAME	MOUNT TYPE
	SPEAKER	CEILING MOUNTED
	SPEAKER	WALL MOUNTED
	SPEAKER	FLOOR MOUNTED
	PRE-WIRE SPEAKER	CEILING MOUNTED PRE-WIRE ONLY NO CUTOUT

CABLING OPTIONS			
	SPKR	2CX2.5 mm ²	SPEAKER CABLE
	COXL	COAXIAL	SUBWOOFER CABLE
	CAT6	CAT6	DATA CABLE
	HDMI	HDMI	VIDEO CABLE

Client : CLINICAL RETREAT

Location : ANAND

Created 08-06-2017
 Modified Not yet
 Printed Not yet

Drawing Name :
 WIRING DETAILS


Drawing Type :
 PRE WIRE WIRING

Drawing Scale : SCALE TO FIT

Designed by Ruchi

Checked by Ankur Bhatt

HC-052/4.1

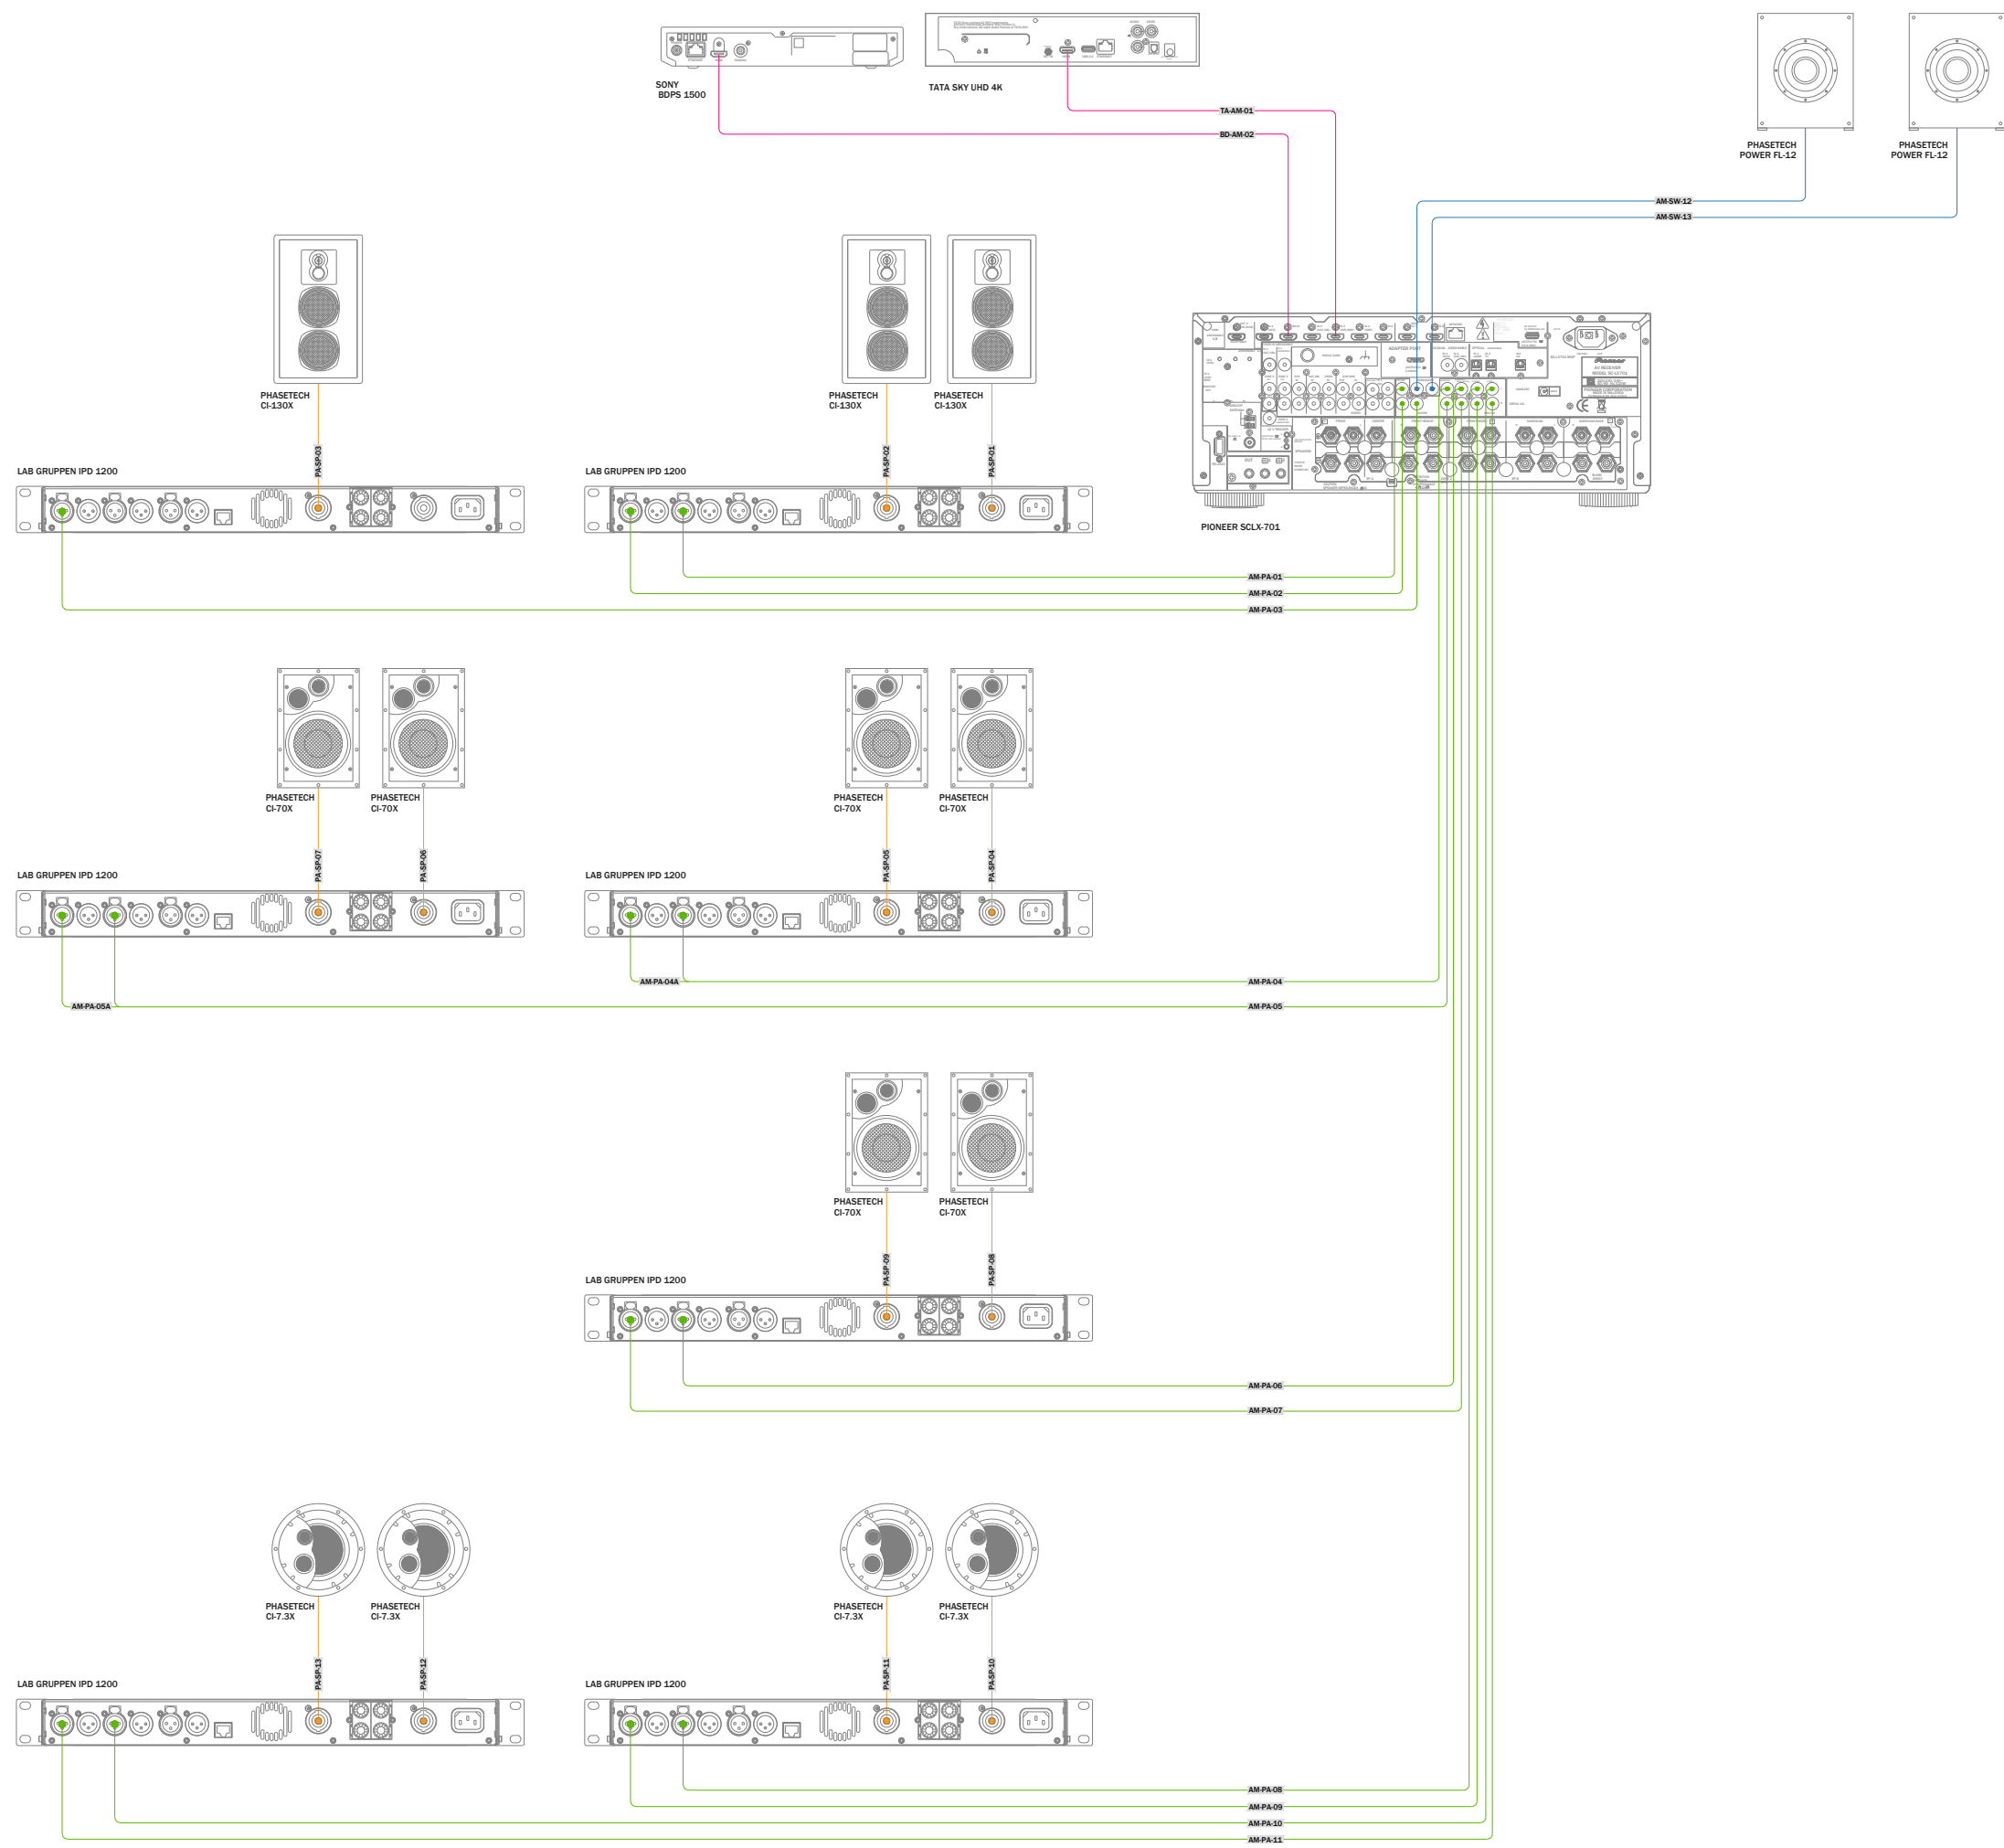

AUDIO VIDEO SYMBOLS		
SYMBOL	NAME	DO=DEVICE OPTIONS
	SPEAKER	LCR-LCR BAR SU-SUBWOOFER ST-STEREO
	VIDEO PROJECTOR	LCD-LIQUID CRYSTAL DISPLAY DLP-DIGITAL LIGHT PROCESSOR SXRD-SILICON X-TEL REF. DISP.
	PROJECTOR SCREEN	F-FIXED M-MOTORISED

COMMUNICATIONS SYMBOLS		
SYMBOL	NAME	DO=DEVICE OPTIONS
	PHONE AND DATA PORT	D-DATA F-FIBRE OPTIC P-PHONE
	INCOMING SERVICES	CTV-CABLE TV P-PHONE S-SATELLITE
	RF REPEATER ACCESS POINT	CR-CELLUAR PR-PHONE WAP-WIRELESSACCESS POINT

FURNISHINGS SYMBOLS		
SYMBOL	NAME	DO=DEVICE OPTIONS
	RACK OR HEAD END	AV-AUDIO/VIDEO C-CONTROL D-DATA SEC-SECURITY
	LIFT/MOUNT	A-ARTICULATED M-MOTORISED UB-UNDER BED

EXAMPLES: SYMBOL + MOUNTING OPTION		
SYMBOL	NAME	MOUNT TYPE
	SPEAKER	CEILING MOUNTED
	SPEAKER	WALL MOUNTED
	SPEAKER	FLOOR MOUNTED
	PRE-WIRE SPEAKER	CEILING MOUNTED PRE-WIRE ONLY NO CUTOUT

CABLING OPTIONS			
	SPKR	2CX2.5 mm²	SPEAKER CABLE
	COXL	COAXIAL	SUBWOOFER CABLE
	CAT6	CAT6	DATA CABLE
	HDMI	HDMI	VIDEO CABLE

Client : CLINICAL RETREAT

Location : ANAND

Created 07-06-2017
 Modified Not yet
 Printed Not yet

Drawing Name : SCHEMATIC


Drawing Type : AV LINE DIAGRAM

Drawing Scale : SCALE TO FIT

Designed by Ruchi

Checked by Ankur Bhatt

HC-052/5

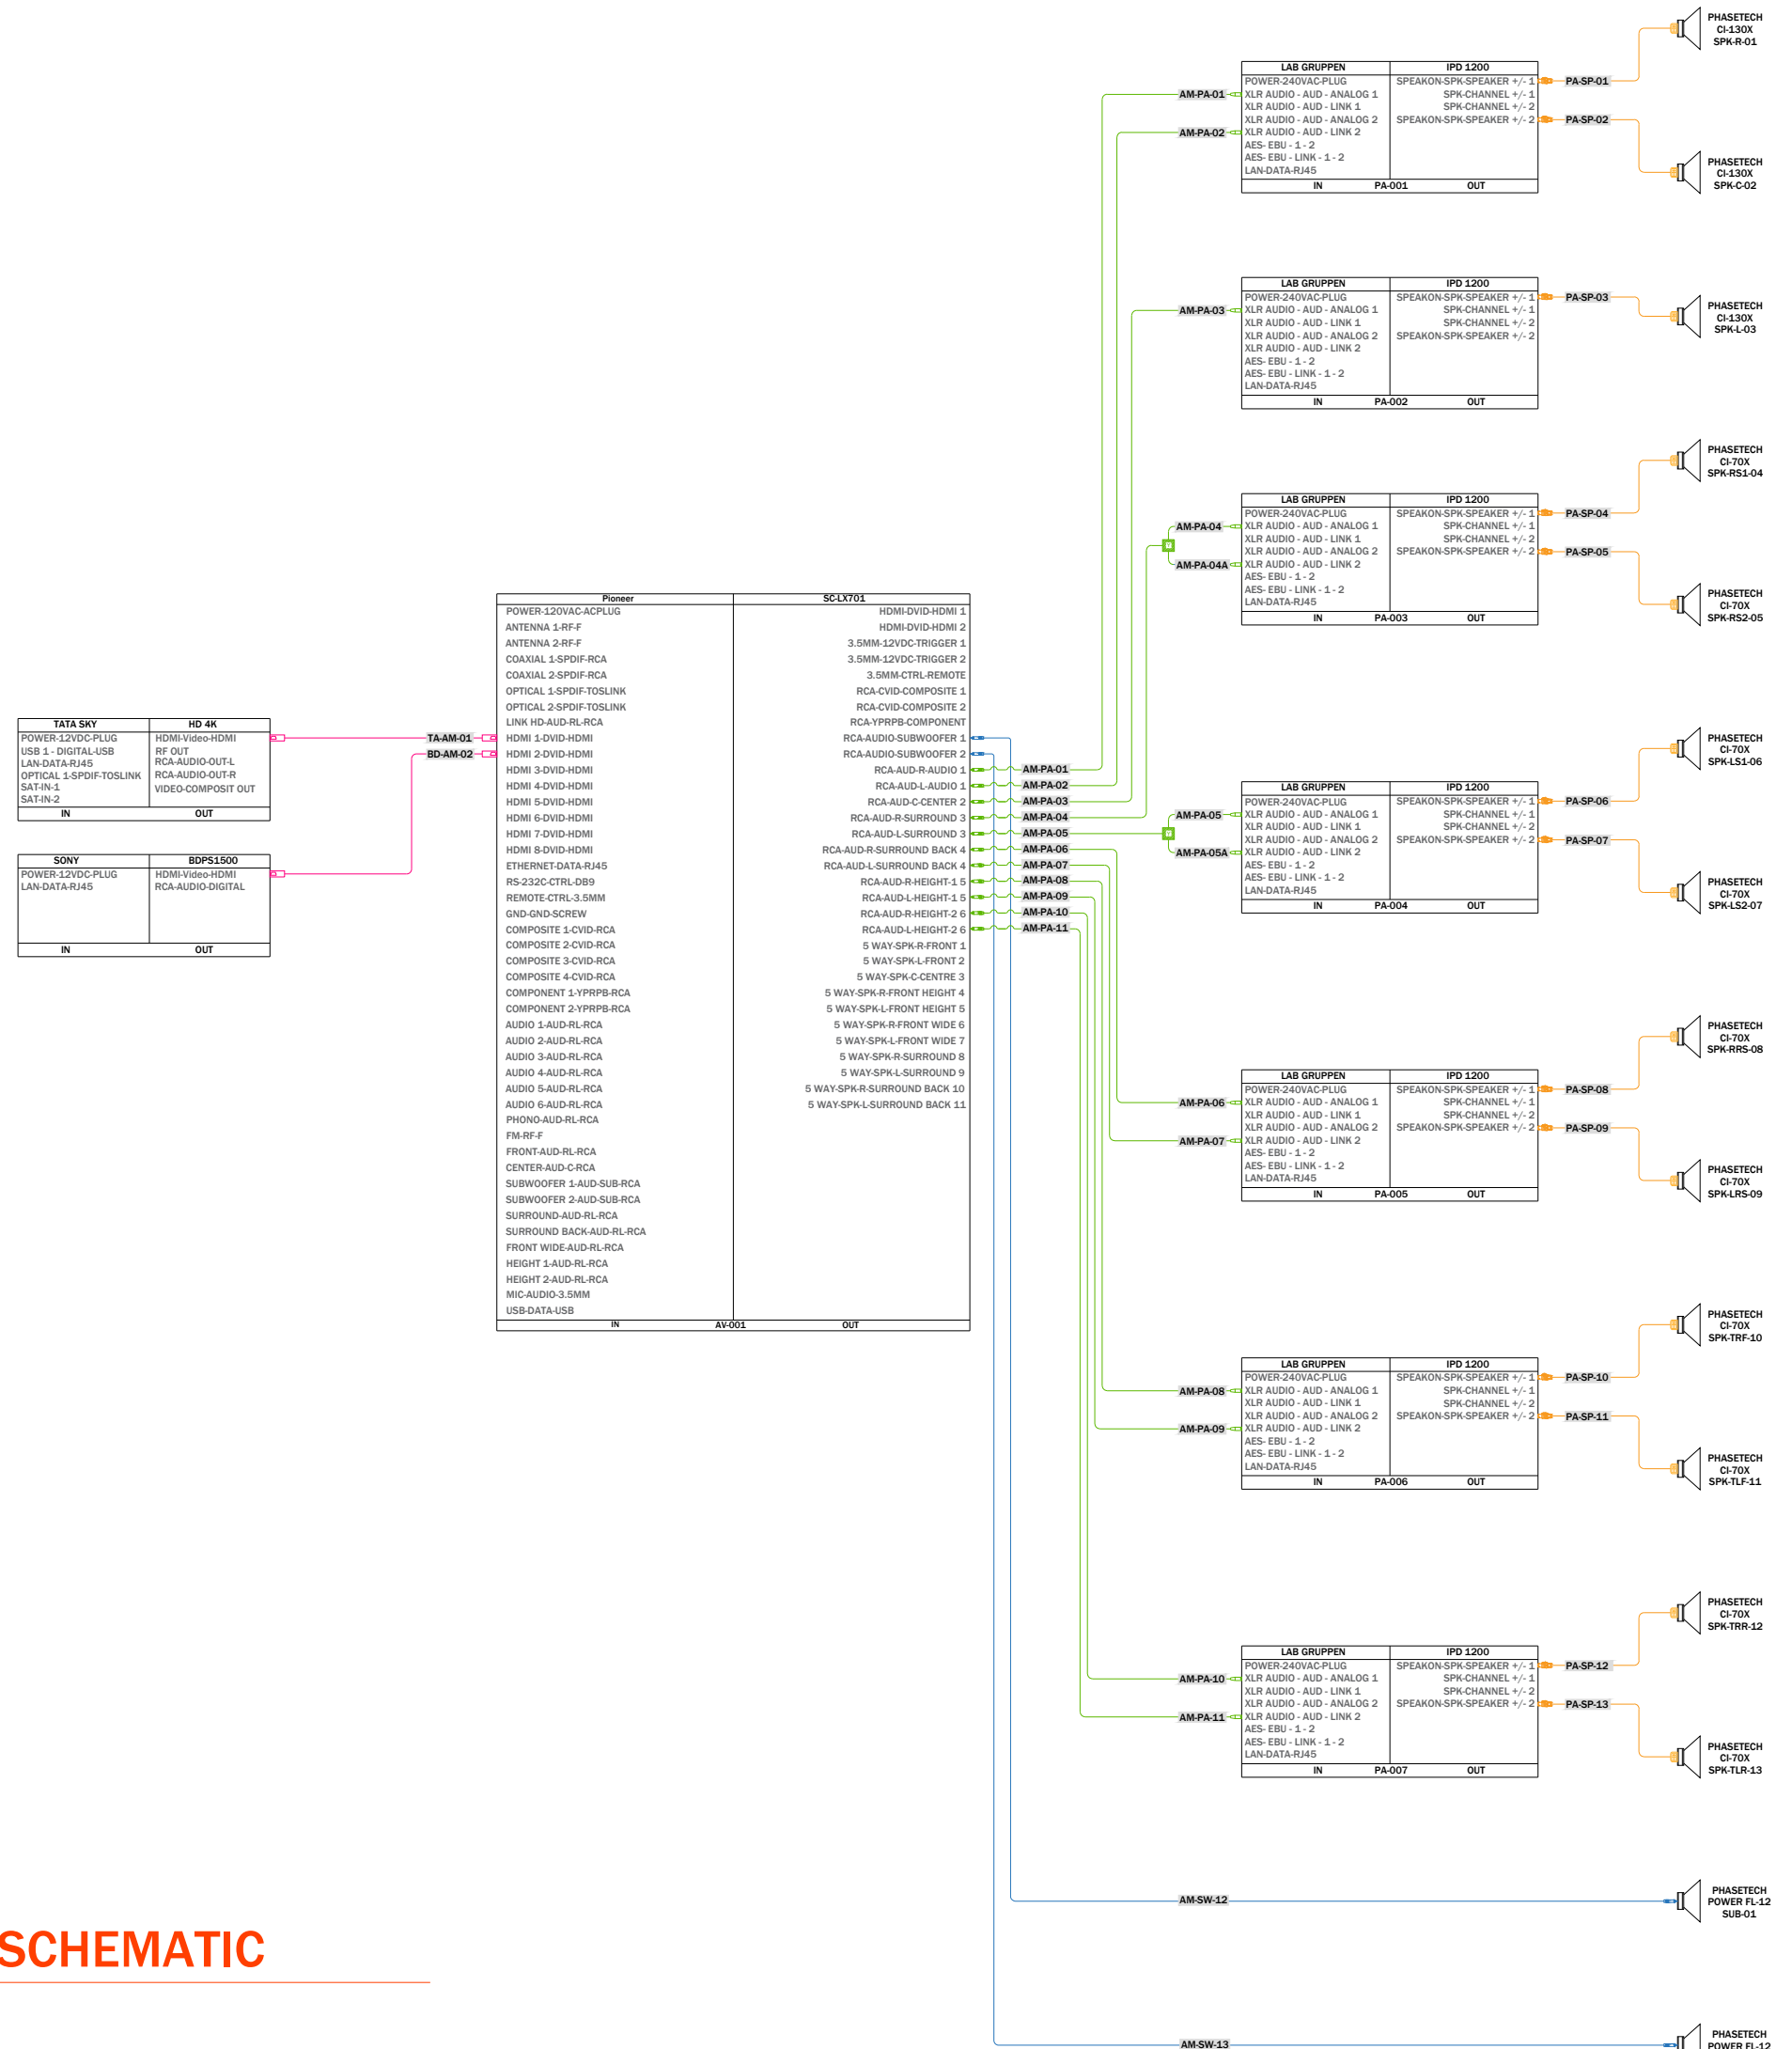

AUDIO VIDEO SYMBOLS		
SYMBOL	NAME	DO=DEVICE OPTIONS
	SPEAKER	LCR-LCR BAR SU-SUBWOOFER ST-STEREO
	VIDEO PROJECTOR	LCD-LIQUID CRYSTAL DISPLAY DLP-DIGITAL LIGHT PROCESSOR SXR-D-SILICON X-TEL REF. DISP.
	PROJECTON SCREEN	F-FIXED M-MOTORISED

COMMUNICATIONS SYMBOLS		
SYMBOL	NAME	DO=DEVICE OPTIONS
	PHONE AND DATA PORT	D-DATA F-FIBRE OPTIC P-PHONE
	INCOMING SERVICES	CTV-CABLE TV P-PHONE S-SATELLITE
	RF REPEATER ACCESS POINT	CR-CELLUAR PR-PHONE WAP-WIRELESSACCESS POINT

FURNISHINGS SYMBOLS		
SYMBOL	NAME	DO=DEVICE OPTIONS
	RACK OR HEAD END	AV-AUDIO/VIDEO C-CONTROL D-DATA SEC-SECURITY
	LIFT/MOUNT	A-ARTICULATED M-MOTORISED UB-UNDER BED

EXAMPLES: SYMBOL + MOUNTING OPTION		
SYMBOL	NAME	MOUNT TYPE
	SPEAKER	CEILING MOUNTED
	SPEAKER	WALL MOUNTED
	SPEAKER	FLOOR MOUNTED
	PRE-WIRE SPEAKER	CEILING MOUNTED PRE-WIRE ONLY NO CUTOUT

CABLING OPTIONS			
Symbol	Line Type	Line Size	Cable Type
	SPKR	2CX2.5 mm ²	SPEAKER CABLE
	COXL	COAXIAL	SUBWOOFER CABLE
	CAT6	CAT6	DATA CABLE
	HDMI	HDMI	VIDEO CABLE

Client : CLINICAL RETREAT

Location : ANAND

Created 07-06-2017
 Modified Not yet
 Printed Not yet

Drawing Name : SCHEMATIC

Drawing Type : CINEMA SCHEMATIC

Drawing Scale : SCALE TO FIT

Designed by Ruchi

Checked by Ankur Bhatt

HC-052/5.1



IN-AP-01

LINKSYS	E-900
POWER-12VDC-PLUG	LAN-DATA-RJ45-01
WAN-DATA-RJ45	LAN-DATA-RJ45-02
	LAN-DATA-RJ45-03
	LAN-DATA-RJ45-04
IN	OUT

AP-TA-01
AP-BD-02
AP-AM-05

TATA SKY	HD 4K
POWER-12VDC-PLUG	HDMI-Video-HDMI
USB 1 - DIGITAL-USB	RF OUT
LAN-DATA-RJ45	RCA-AUDIO-OUT-L
OPTICAL 1-SPDIF-TOSLINK	RCA-AUDIO-OUT-R
SAT-IN-1	VIDEO-COMPOSIT OUT
SAT-IN-2	
IN	OUT

SONY	BDPS1500
POWER-12VDC-PLUG	HDMI-Video-HDMI
LAN-DATA-RJ45	RCA-AUDIO-DIGITAL
IN	OUT

Pioneer	SC-LX701	
POWER-120VAC-ACPLUG	HDMI-DVID-HDMI 1	
ANTENNA 1-RF-F	HDMI-DVID-HDMI 2	
ANTENNA 2-RF-F	3.5MM-12VDC-TRIGGER 1	
COAXIAL 1-SPDIF-RCA	3.5MM-12VDC-TRIGGER 2	
COAXIAL 2-SPDIF-RCA	3.5MM-CTRL-REMOTE	
OPTICAL 1-SPDIF-TOSLINK	RCA-CVID-COMPOSITE 1	
OPTICAL 2-SPDIF-TOSLINK	RCA-CVID-COMPOSITE 2	
LINK HD-AUD-RL-RCA	RCA-YPRPB-COMPONENT	
HDMI 1-DVID-HDMI	RCA-AUDIO-SUBWOOFER 1	
HDMI 2-DVID-HDMI	RCA-AUDIO-SUBWOOFER 2	
HDMI 3-DVID-HDMI	RCA-AUD-R-AUDIO 1	
HDMI 4-DVID-HDMI	RCA-AUD-L-AUDIO 1	
HDMI 5-DVID-HDMI	RCA-AUD-C-CENTER 2	
HDMI 6-DVID-HDMI	RCA-AUD-R-SURROUND 3	
HDMI 7-DVID-HDMI	RCA-AUD-L-SURROUND 3	
HDMI 8-DVID-HDMI	RCA-AUD-R-SURROUND BACK 4	
ETHERNET-DATA-RJ45	RCA-AUD-L-SURROUND BACK 4	
RS-232C-CTRL-DB9	RCA-AUD-R-HEIGHT-1 5	
REMOTE-CTRL-3.5MM	RCA-AUD-L-HEIGHT-1 5	
GND-GND-SCREW	RCA-AUD-R-HEIGHT-2 6	
COMPOSITE 1-CVID-RCA	RCA-AUD-L-HEIGHT-2 6	
COMPOSITE 2-CVID-RCA	5 WAY-SPK-R-FRONT 1	
COMPOSITE 3-CVID-RCA	5 WAY-SPK-L-FRONT 2	
COMPOSITE 4-CVID-RCA	5 WAY-SPK-C-CENTRE 3	
COMPONENT 1-YPRPB-RCA	5 WAY-SPK-R-FRONT HEIGHT 4	
COMPONENT 2-YPRPB-RCA	5 WAY-SPK-L-FRONT HEIGHT 5	
AUDIO 1-AUD-RL-RCA	5 WAY-SPK-R-FRONT WIDE 6	
AUDIO 2-AUD-RL-RCA	5 WAY-SPK-L-FRONT WIDE 7	
AUDIO 3-AUD-RL-RCA	5 WAY-SPK-R-SURROUND 8	
AUDIO 4-AUD-RL-RCA	5 WAY-SPK-L-SURROUND 9	
AUDIO 5-AUD-RL-RCA	5 WAY-SPK-R-SURROUND BACK 10	
AUDIO 6-AUD-RL-RCA	5 WAY-SPK-L-SURROUND BACK 11	
PHONO-AUD-RL-RCA		
FM-RF-F		
FRONT-AUD-RL-RCA		
CENTER-AUD-C-RCA		
SUBWOOFER 1-AUD-SUB-RCA		
SUBWOOFER 2-AUD-SUB-RCA		
SURROUND-AUD-RL-RCA		
SURROUND BACK-AUD-RL-RCA		
FRONT WIDE-AUD-RL-RCA		
HEIGHT 1-AUD-RL-RCA		
HEIGHT 2-AUD-RL-RCA		
MIC-AUDIO-3.5MM		
USB-DATA-USB		
IN	AV-001	OUT

AUDIO VIDEO SYMBOLS		
SYMBOL	NAME	DO=DEVICE OPTIONS
	SPEAKER	LCR-LCR BAR SU-SUBWOOFER ST-STEREO
	VIDEO PROJECTOR	LCD-LIQUID CRYSTAL DISPLAY DLP-DIGITAL LIGHT PROCESSOR SXRD-SILICON X-TEL REF. DISP.
	PROJECTON SCREEN	F-FIXED M-MOTORISED

COMMUNICATIONS SYMBOLS		
SYMBOL	NAME	DO=DEVICE OPTIONS
	PHONE AND DATA PORT	D-DATA F-FIBRE OPTIC P-PHONE
	INCOMING SERVICES	CTV-CABLE TV P-PHONE S-SATELLITE
	RF REPEATER ACCESS POINT	CR-CELLULAR PR-PHONE WAP-WIRELESSACCESS POINT

FURNISHINGS SYMBOLS		
SYMBOL	NAME	DO=DEVICE OPTIONS
	RACK OR HEAD END	AV-AUDIO/VIDEO C-CONTROL D-DATA SEC-SECURITY
	LIFT/MOUNT	A-ARTICULATED M-MOTORISED UB-UNDER BED

EXAMPLES: SYMBOL + MOUNTING OPTION		
SYMBOL	NAME	MOUNT TYPE
	SPEAKER	CEILING MOUNTED
	SPEAKER	WALL MOUNTED
	SPEAKER	FLOOR MOUNTED
	PRE-WIRE SPEAKER	CEILING MOUNTED PRE-WIRE ONLY NO CUTOUT

CABLING OPTIONS			
	SPKR	2CX2.5 mm²	SPEAKER CABLE
	COXL	COAXIAL	SUBWOOFER CABLE
	CAT6	CAT6	DATA CABLE
	HDMI	HDMI	VIDEO CABLE

Client : CLINICAL RETREAT

Location : ANAND

Created 07-06-2017
Modified Not yet
Printed Not yet

Drawing Name : SCHEMATIC


Drawing Type : NETWORK SCHEMATIC

Drawing Scale : SCALE TO FIT

Designed by Ruchi

Checked by Ankur Bhatt

HC-052/5.2

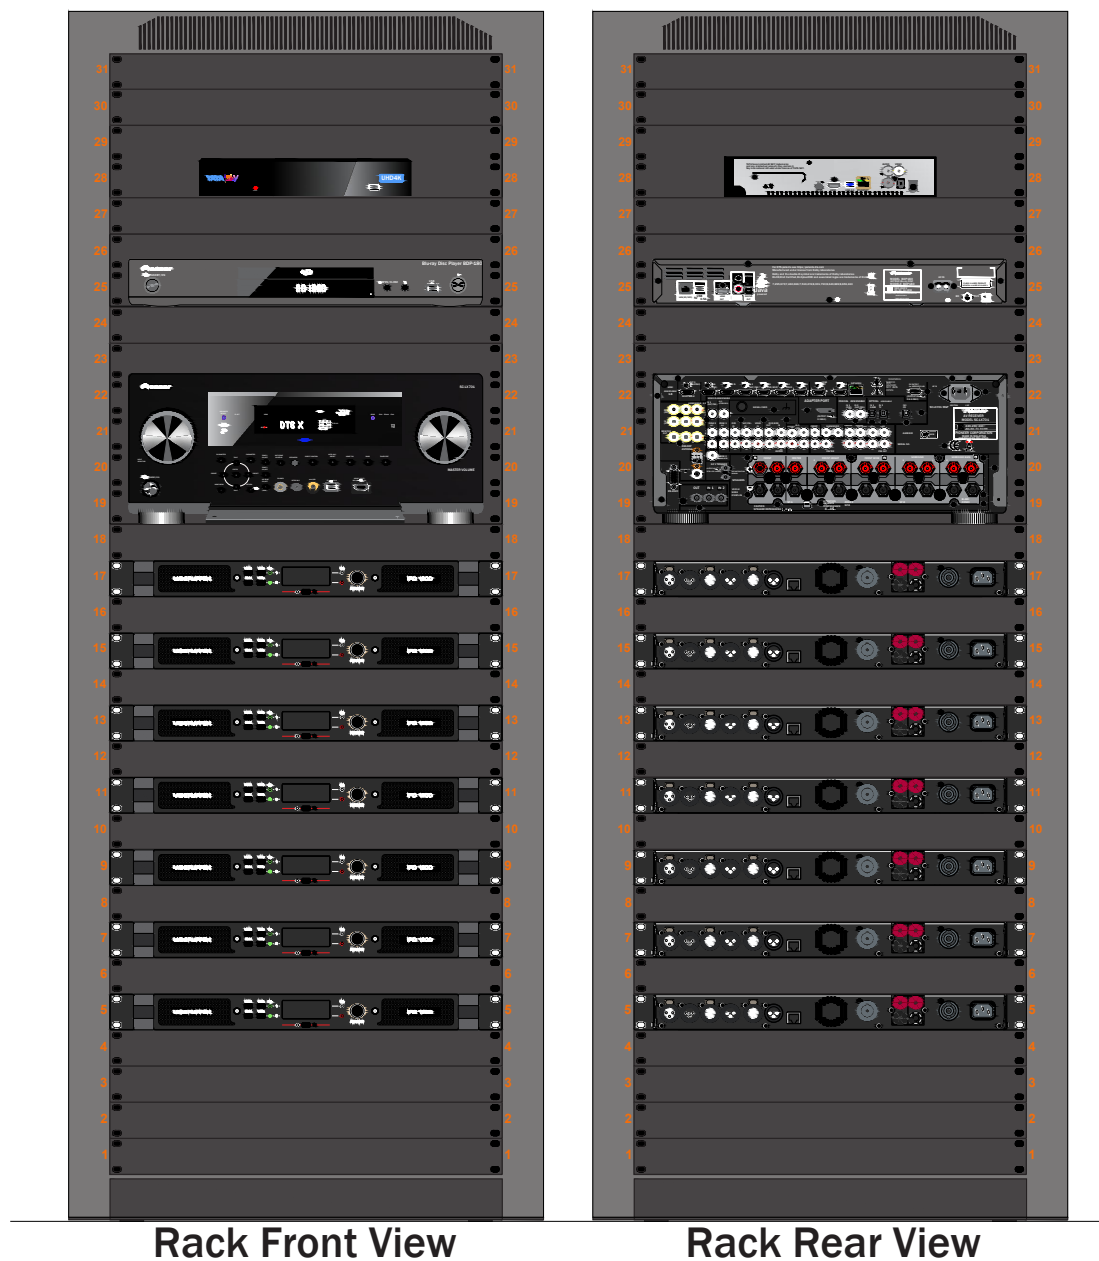

Rack Front View

Rack Rear View

AUDIO VIDEO SYMBOLS		
SYMBOL	NAME	DO=DEVICE OPTIONS
	SPEAKER	LCR-LCR BAR SU-SUBWOOFER ST-STEREO
	VIDEO PROJECTOR	LCD-LIQUID CRYSTAL DISPLAY DLP-DIGITAL LIGHT PROCESSOR SXRD-SILICON X-TEL REF. DISP.
	PROJECTON SCREEN	F-FIXED M-MOTORISED

COMMUNICATIONS SYMBOLS		
SYMBOL	NAME	DO=DEVICE OPTIONS
	PHONE AND DATA PORT	D-DATA F-FIBRE OPTIC P-PHONE
	INCOMING SERVICES	CTV-CABLE TV P-PHONE S-SATELLITE
	RF REPEATER ACCESS POINT	CR-CELLUAR PR-PHONE WAP-WIRELESSACCESS POINT

FURNISHINGS SYMBOLS		
SYMBOL	NAME	DO=DEVICE OPTIONS
	RACK OR HEAD END	AV-AUDIO/VIDEO C-CONTROL D-DATA SEC-SECURITY
	LIFT/MOUNT	A-ARTICULATED M-MOTORISED UB-UNDER BED

EXAMPLES: SYMBOL + MOUNTING OPTION		
SYMBOL	NAME	MOUNT TYPE
	SPEAKER	CEILING MOUNTED
	SPEAKER	WALL MOUNTED
	SPEAKER	FLOOR MOUNTED
	PRE-WIRE SPEAKER	CEILING MOUNTED PRE-WIRE ONLY NO CUTOUT

CABLING OPTIONS			
SYMBOL	NAME	DO=DEVICE OPTIONS	DESCRIPTION
	SPKR	2CX2.5 mm ²	SPEAKER CABLE
	COXL	COAXIAL	SUBWOOFER CABLE
	CAT6	CAT6	DATA CABLE
	HDMI	HDMI	VIDEO CABLE

Client : CLINICAL RETREAT

Location : ANAND

Created 08-06-2017
 Modified Not yet
 Printed Not yet

Drawing Name :
RACK


Drawing Type :
RACK DETAIL

Drawing Scale : SCALE TO FIT

Designed by Ruchi

Checked by Ankur Bhatt

HC-052/6

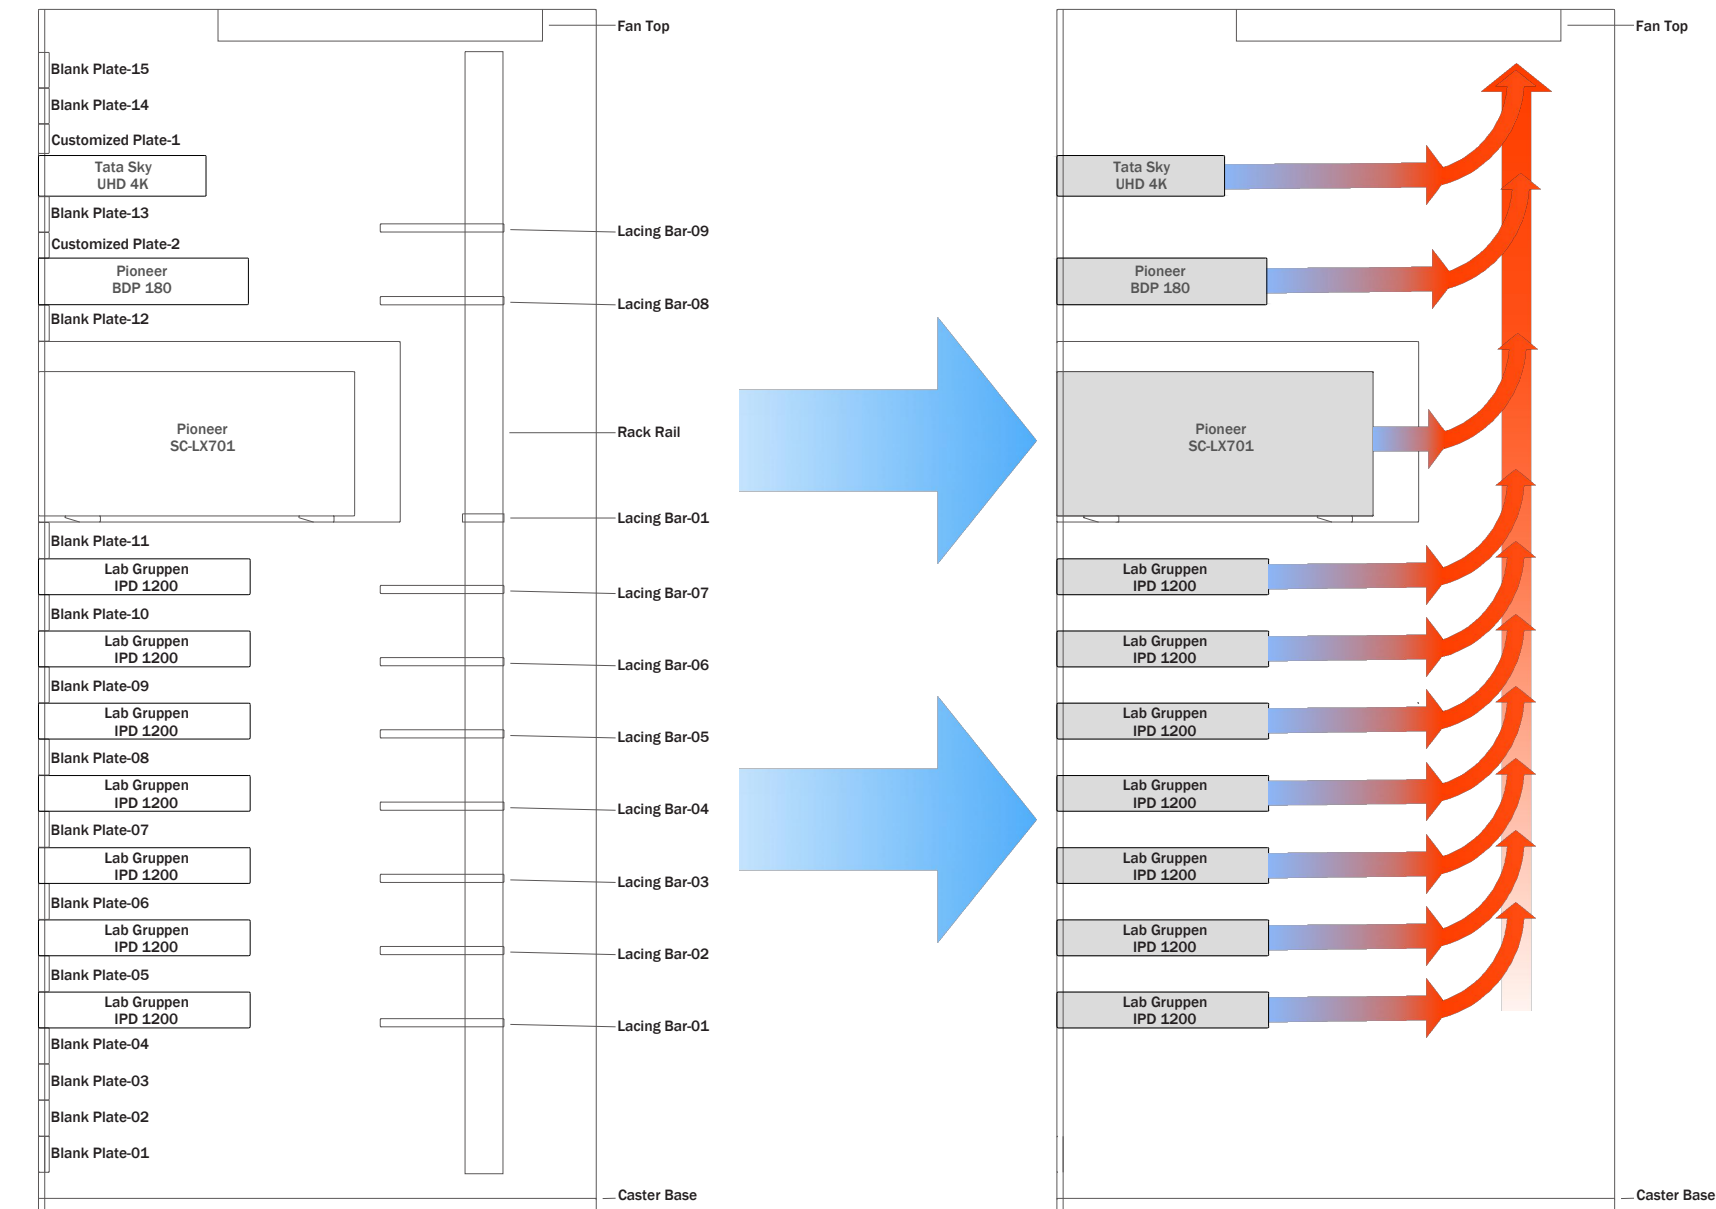

Rack Side View

Ventilation & Thermal Management

Model	Description	QTY	Total U	Total Watts	Total BTU	Total KG
Pioneer SC-LX 701	Audio Video amplifier	1	5	310	1057.72	10.04
BDP 180	Blu Ray Player	1	2	35	119.42	2.00
Lab Gruppen IPD 1200	Power amplifier	7	7	1750	5971	32.2
Tata Sky UHD 4K	Satellite TV	1	2	35	119.42	0.2
Rack Accesories						
BLK-1	1 space (1 3/4 in.) flanged	15	15			1.91
CUS-01	Customized flanged	4				
REC	Gangable rack enclosure	1				65.33
FT	Fan top	1				4.35
CCT	Cable chase top	1				1.78
FDV	Front door -vented	1				14.22
CK	Caster kit	1				7.78
SCR	Standard rack screw x 500	350				
Lacing bar	L shaped lacing bar, only	9				
Lacing bar	L shaped lacing bar, 50mm	1				
RDV	Rear door vent strip	1				1.47
Totals			31	2130.0	7267.56	135.28

AUDIO VIDEO SYMBOLS		
SYMBOL	NAME	DO=DEVICE OPTIONS
	SPEAKER	LCR-LCR BAR SU-SUBWOOFER ST-STEREO
	VIDEO PROJECTOR	LCD-LIQUID CRYSTAL DISPLAY DLP-DIGITAL LIGHT PROCESSOR SXRD-SILICON X-TEL REF. DISP.
	PROJECTOR SCREEN	F-FIXED M-MOTORISED

COMMUNICATIONS SYMBOLS		
SYMBOL	NAME	DO=DEVICE OPTIONS
	PHONE AND DATA PORT	D-DATA F-FIBRE OPTIC P-PHONE
	INCOMING SERVICES	CTV-CABLE TV P-PHONE S-SATELLITE
	RF REPEATER ACCESS POINT	CR-CELLUAR PR-PHONE WAP-WIRELESSACCESS POINT

FURNISHINGS SYMBOLS		
SYMBOL	NAME	DO=DEVICE OPTIONS
	RACK OR HEAD END	AV-AUDIO/VIDEO C-CONTROL D-DATA SEC-SECURITY
	LIFT/MOUNT	A-ARTICULATED M-MOTORISED UB-UNDER BED

EXAMPLES: SYMBOL + MOUNTING OPTION		
SYMBOL	NAME	MOUNT TYPE
	SPEAKER	CEILING MOUNTED
	SPEAKER	WALL MOUNTED
	SPEAKER	FLOOR MOUNTED
	PRE-WIRE SPEAKER	CEILING MOUNTED PRE-WIRE ONLY NO CUTOUT

CABLING OPTIONS			
	SPKR	2CX2.5 mm²	SPEAKER CABLE
	COXL	COAXIAL	SUBWOOFER CABLE
	CAT6	CAT6	DATA CABLE
	HDMI	HDMI	VIDEO CABLE

Client : CLINICAL RETREAT

Location : ANAND

Created 08-06-2017
 Modified Not yet
 Printed Not yet

Drawing Name :
RACK


Drawing Type :
RACK & HEAT CALCULATION

Drawing Scale : SCALE TO FIT

Designed by Ruchi

Checked by Ankur Bhatt

HC-052/6.1

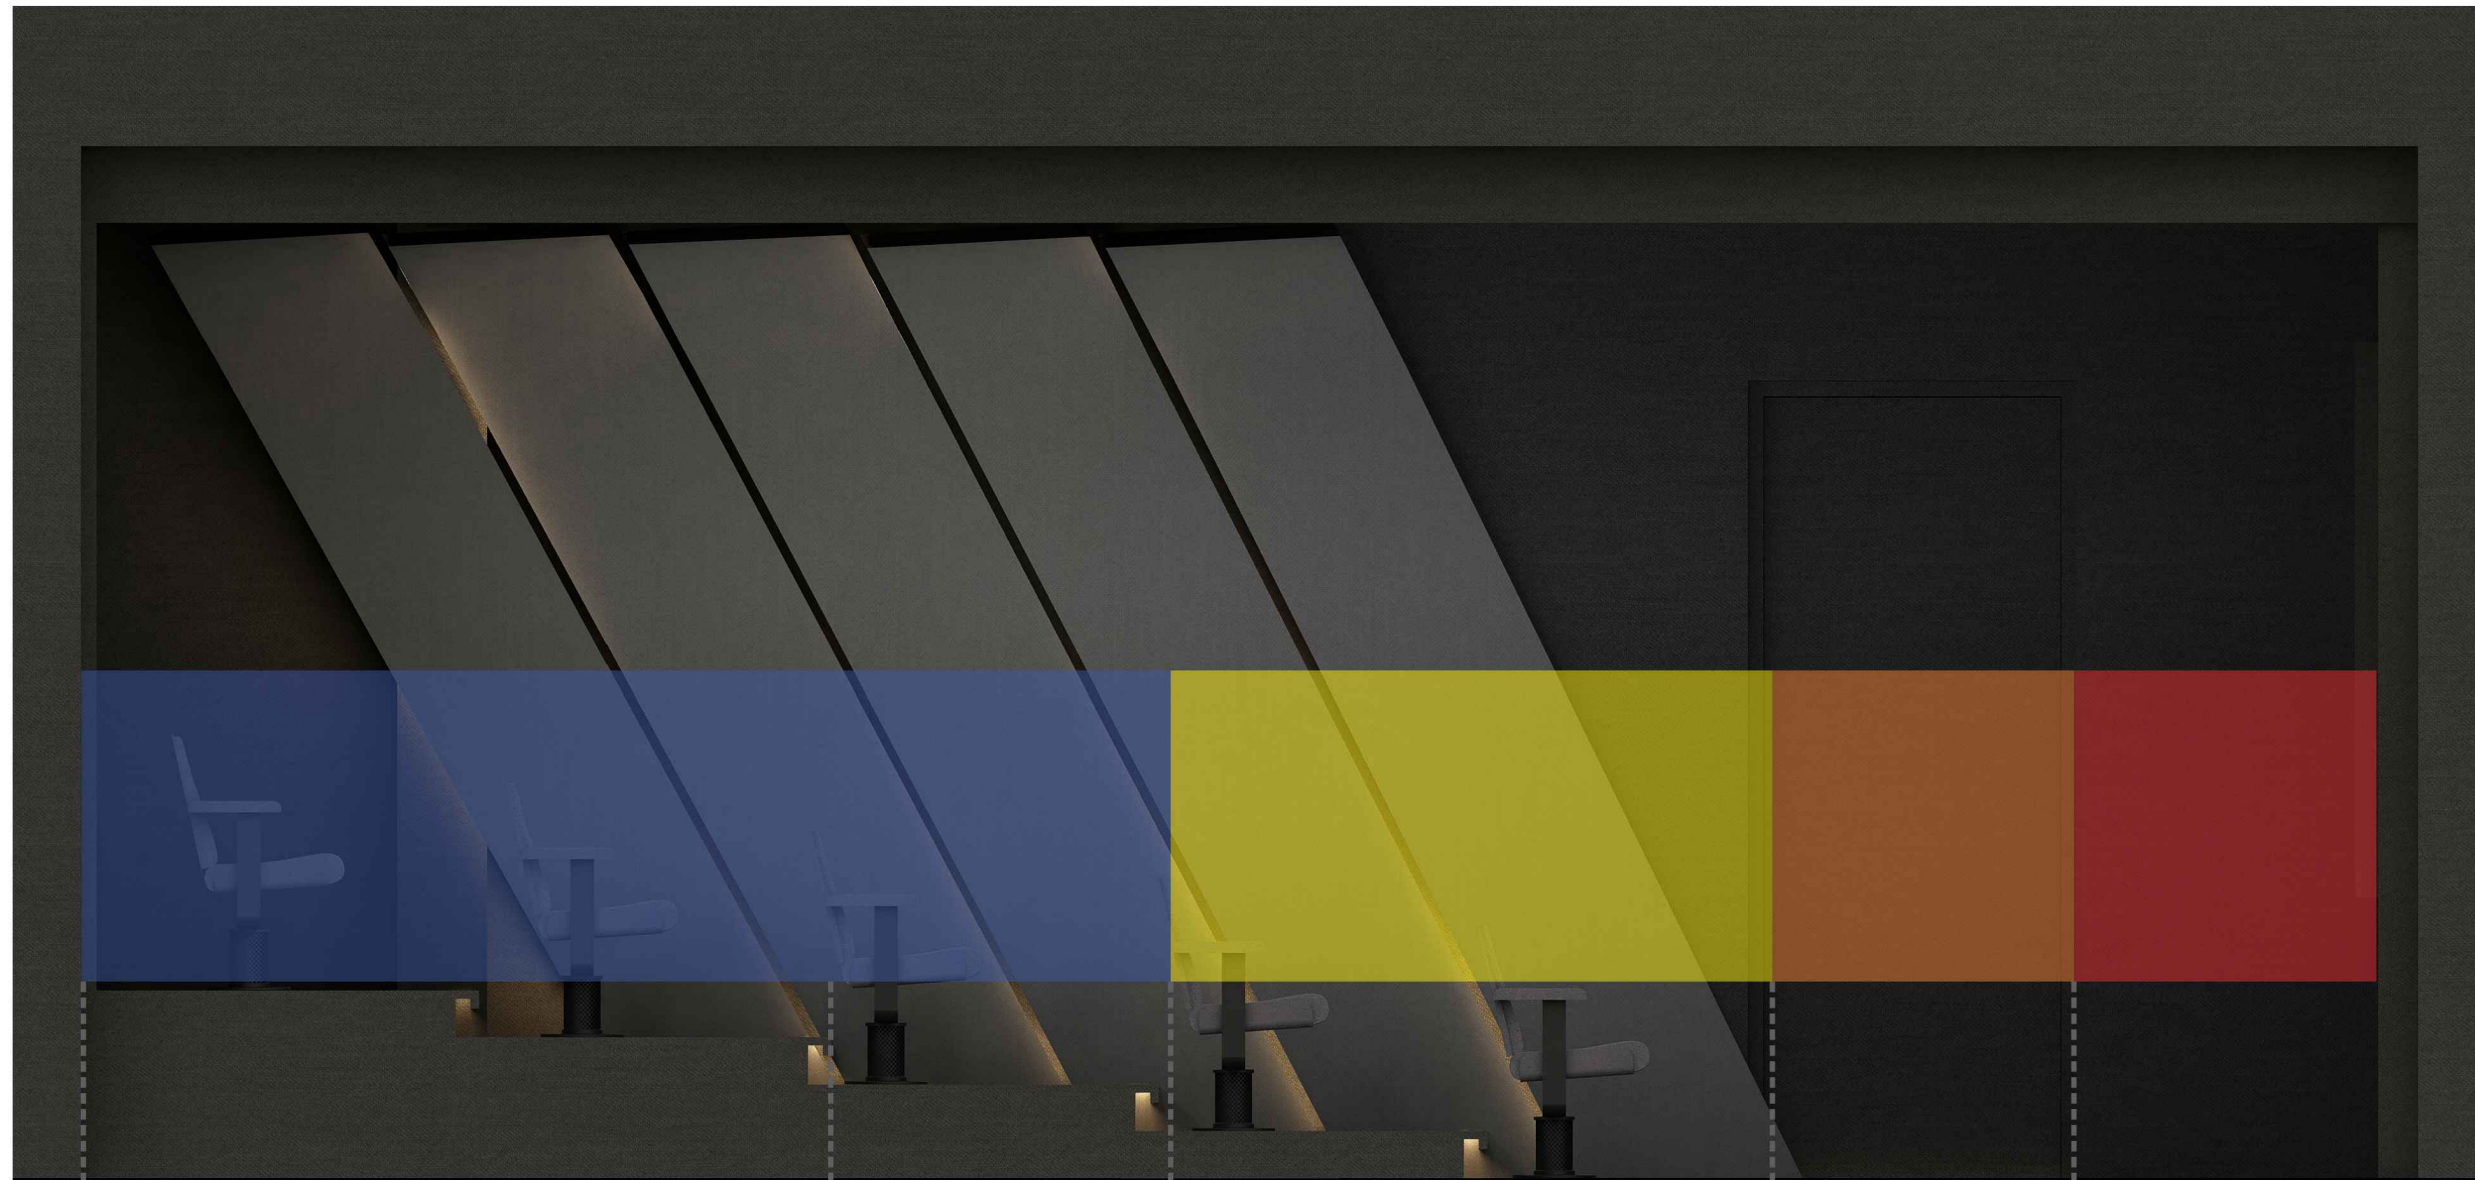

7.5 meter

103db

4.87 meter

106db

4 meter

108db

2 meter

114db

1 meter

120db

AUDIO VIDEO SYMBOLS			
SYMBOL	NAME	DO=DEVICE OPTIONS	
	SPEAKER	LCR-LCR BAR SU-SUBWOOFER ST-STEREO	
	VIDEO PROJECTOR	LCD-LIQUID CRYSTAL DISPLAY DLP-DIGITAL LIGHT PROCESSOR SXRD-SILICON X-TEL REF. DISP.	
	PROJECTON SCREEN	F-FIXED M-MOTORISED	
COMMUNICATIONS SYMBOLS			
SYMBOL	NAME	DO=DEVICE OPTIONS	
	PHONE AND DATA PORT	D-DATA F-FIBRE OPTIC P-PHONE	
	INCOMING SERVICES	CTV-CABLE TV P-PHONE S-SATELLITE	
	RF REPEATER ACCESS POINT	CR-CELLUAR PR-PHONE WAP-WIRELESSACCESS POINT	
FURNISHINGS SYMBOLS			
SYMBOL	NAME	DO=DEVICE OPTIONS	
	RACK OR HEAD END	AV-AUDIO/VIDEO C-CONTROL D-DATA SEC-SECURITY	
	LIFT/MOUNT	A-ARTICULATED M-MOTORISED UB-UNDER BED	
EXAMPLES: SYMBOL + MOUNTING OPTION			
SYMBOL	NAME	MOUNT TYPE	
	SPEAKER	CEILING MOUNTED	
	SPEAKER	WALL MOUNTED	
	SPEAKER	FLOOR MOUNTED	
	PRE-WIRE SPEAKER	CEILING MOUNTED PRE-WIRE ONLY NO CUTOUT	
CABLING OPTIONS			
	SPKR	2CX2.5 mm ²	SPEAKER CABLE
	COXL	COAXIAL	SUBWOOFER CABLE
	CAT6	CAT6	DATA CABLE
	HDMI	HDMI	VIDEO CABLE

Client : CLINICAL RETREAT

Location : ANAND

Created 06-06-2017

Modified Not yet

Printed Not yet

Drawing Name :
3D VISULIZATION

Drawing Type :
SPL CALCULATION


Drawing Scale : SCALE TO FIT

Designed by Chirantan

Checked by Ankur Bhatt

HC-052/7

AMP POWER: SPL DECREASE AS DISTANCE INCREASES

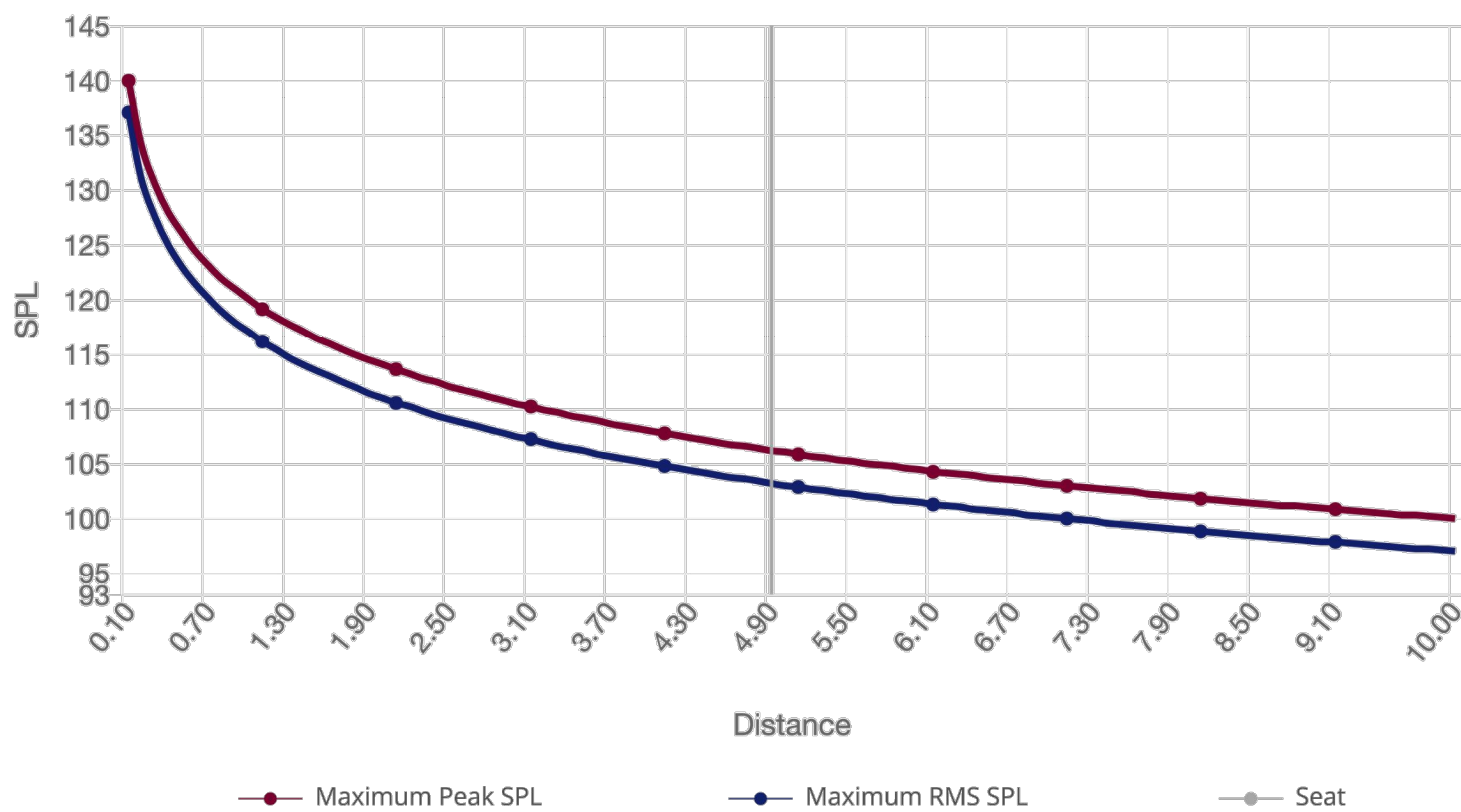

DR.SOHAM

SPEAKER

Sensitivity	88 @ 1W
Impedance	4 ohms
RMS Amp Power	200 W
In Wall gain added	Yes
Distance	16 ft
Target Peak SPL	105 dB

RMS SPL

RMS SPL at seat	103.21 dB
RMS SPL at 1m	117.01 dB

PEAK SPL

RMS power for Peak SPL	106.25 W
Peak power for peak SPL	299.41 W
Peak SPL at seat	106.21 dB
Peak SPL at 1m	120.01 dB

AUDIO VIDEO SYMBOLS		
SYMBOL	NAME	DO=DEVICE OPTIONS
	SPEAKER	LCR-LCR BAR SU-SUBWOOFER ST-STEREO
	VIDEO PROJECTOR	LCD-LIQUID CRYSTAL DISPLAY DLP-DIGITAL LIGHT PROCESSOR SXRD-SILICON X-TEL REF. DISP.
	PROJECTOR SCREEN	F-FIXED M-MOTORISED

COMMUNICATIONS SYMBOLS		
SYMBOL	NAME	DO=DEVICE OPTIONS
	PHONE AND DATA PORT	D-DATA F-FIBRE OPTIC P-PHONE
	INCOMING SERVICES	CTV-CABLE TV P-PHONE S-SATELLITE
	RF REPEATER ACCESS POINT	CR-CELLULAR PR-PHONE WAP-WIRELESSACCESS POINT

FURNISHINGS SYMBOLS		
SYMBOL	NAME	DO=DEVICE OPTIONS
	RACK OR HEAD END	AV-AUDIO/VIDEO C-CONTROL D-DATA SEC-SECURITY
	LIFT/MOUNT	A-ARTICULATED M-MOTORISED UB-UNDER BED

EXAMPLES: SYMBOL + MOUNTING OPTION		
SYMBOL	NAME	MOUNT TYPE
	SPEAKER	CEILING MOUNTED
	SPEAKER	WALL MOUNTED
	SPEAKER	FLOOR MOUNTED
	PRE-WIRE SPEAKER	CEILING MOUNTED PRE-WIRE ONLY NO CUTOUT

CABLING OPTIONS			
SYMBOL	NAME	TYPE	CABLE
	SPKR	2CX2.5 mm²	SPEAKER CABLE
	COXL	COAXIAL	SUBWOOFER CABLE
	CAT6	CAT6	DATA CABLE
	HDMI	HDMI	VIDEO CABLE

Client : CLINICAL RETREAT

Location : ANAND

Created 06-06-2017
Modified Not yet
Printed Not yet

Drawing Name :
SPL CALCULATION




Drawing Type :
SPL CALCULATION

Drawing Scale : SCALE TO FIT

Designed by Chirantan

Checked by Ankur Bhatt

HC-052/7.1

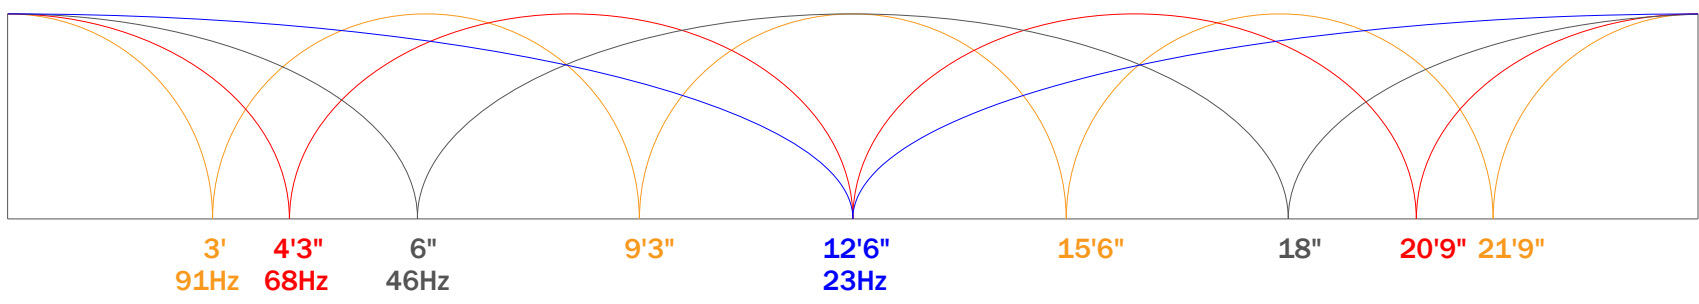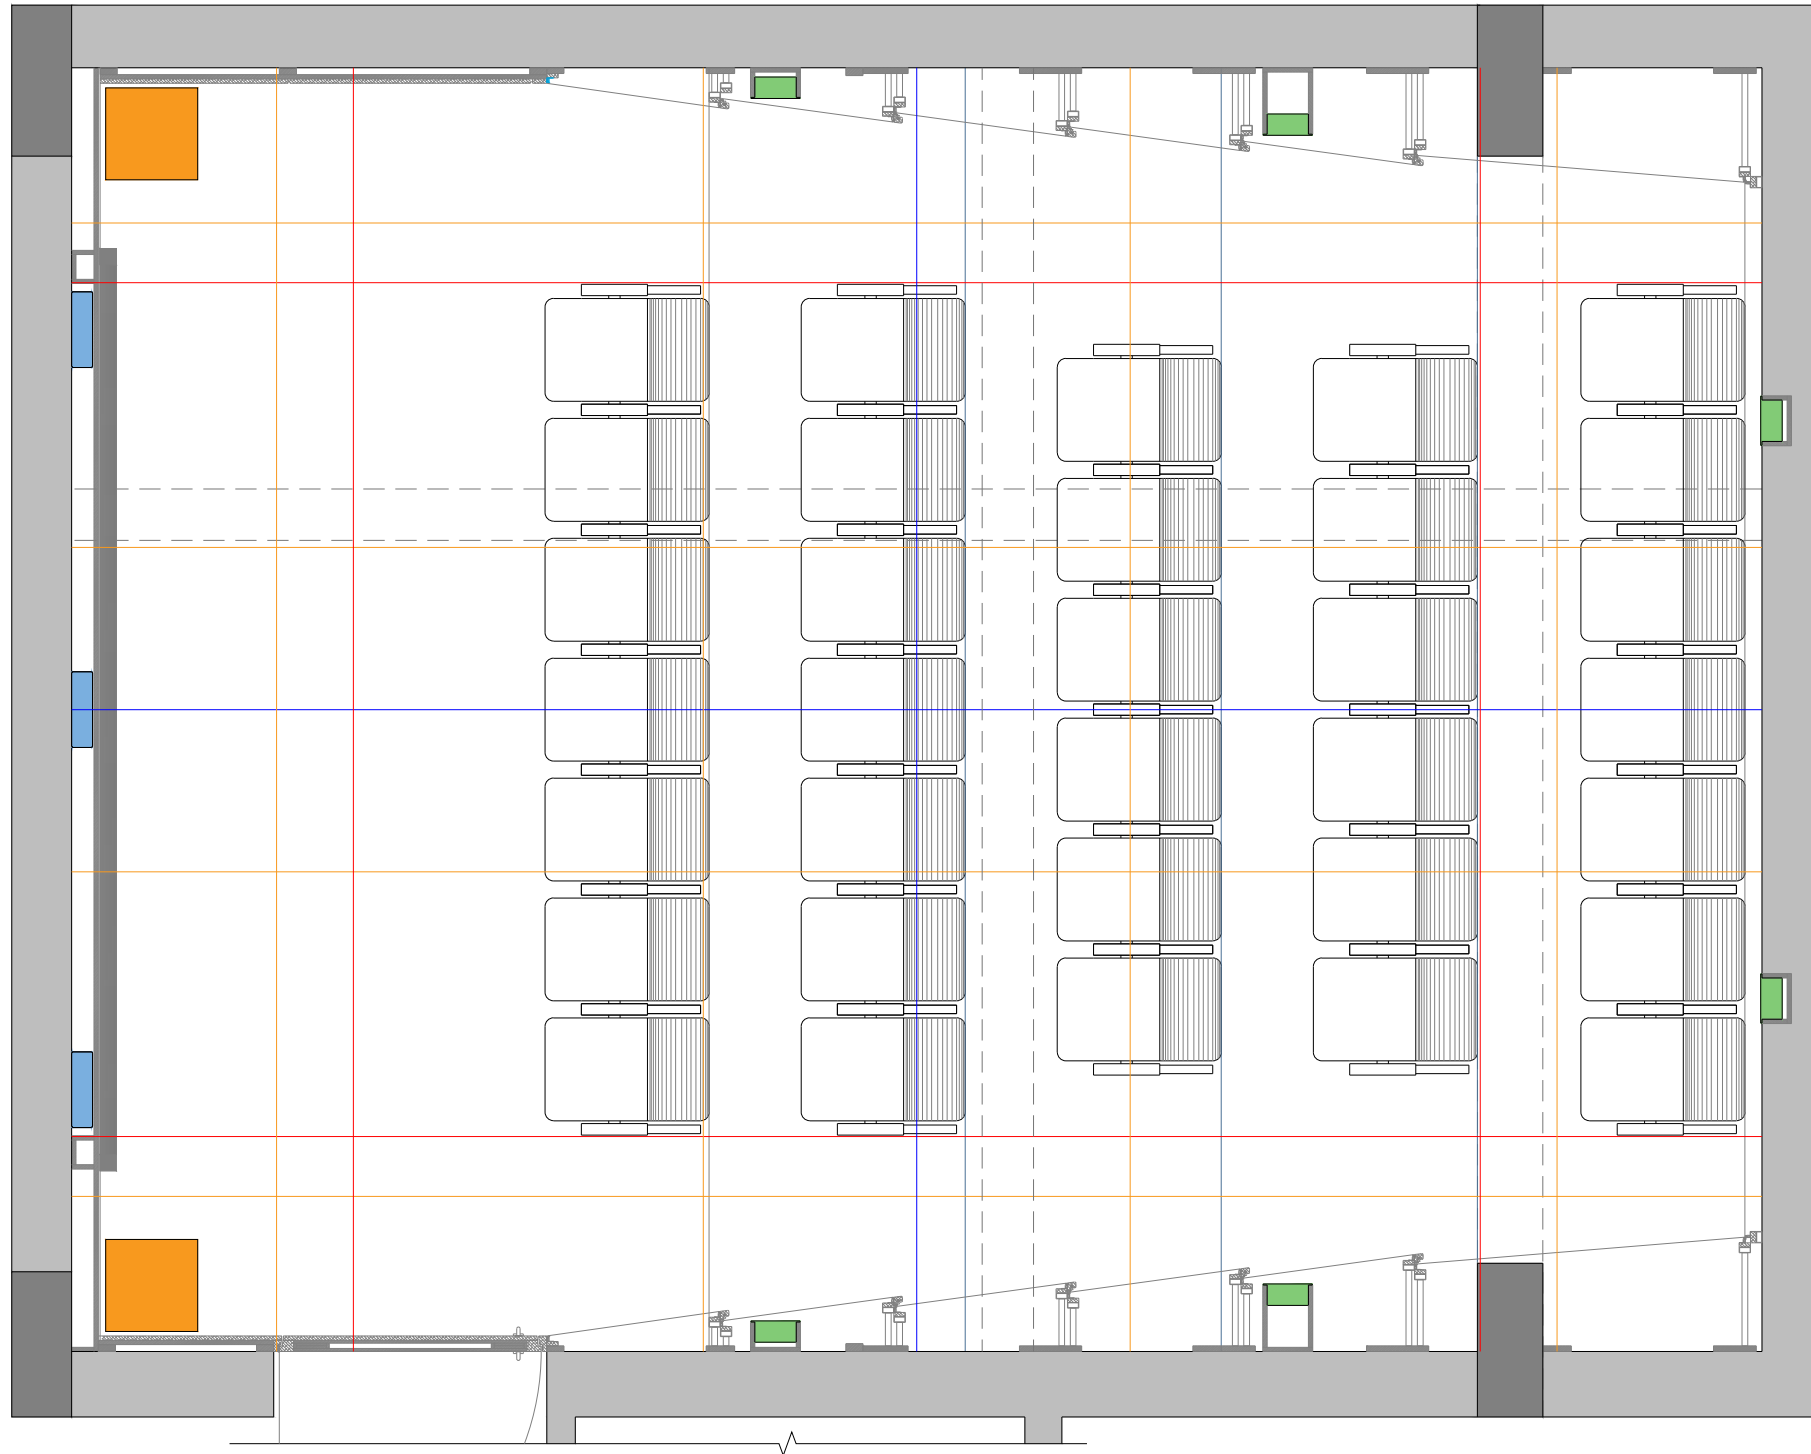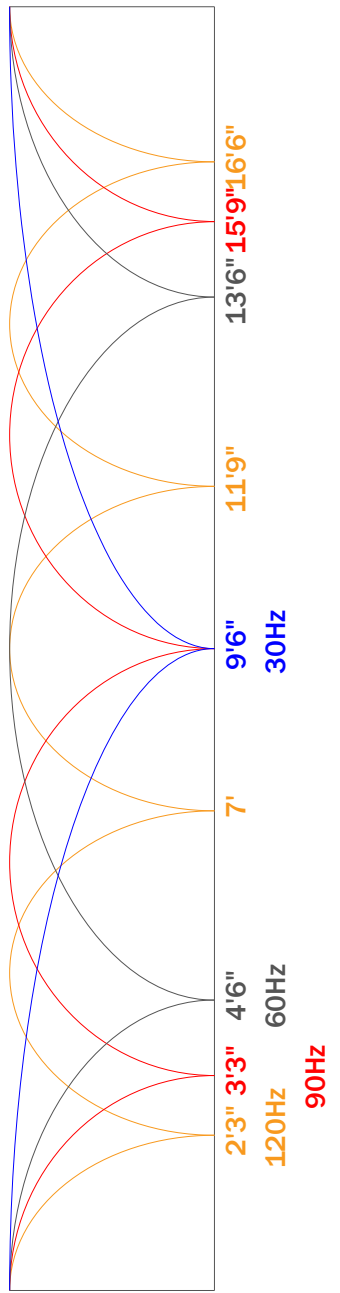

AUDIO VIDEO SYMBOLS		
SYMBOL	NAME	DO=DEVICE OPTIONS
	SPEAKER	LCR-LCR BAR SU-SUBWOOFER ST-STEREO
	VIDEO PROJECTOR	LCD-LIQUID CRYSTAL DISPLAY DLP-DIGITAL LIGHT PROCESSOR SXRD-SILICON X-TEL REF. DISP.
	PROJECTON SCREEN	F-FIXED M-MOTORISED

COMMUNICATIONS SYMBOLS		
SYMBOL	NAME	DO=DEVICE OPTIONS
	PHONE AND DATA PORT	D-DATA F-FIBRE OPTIC P-PHONE
	INCOMING SERVICES	CTV-CABLE TV P-PHONE S-SATELLITE
	RF REPEATER ACCESS POINT	CR-CELLULAR PR-PHONE WAP-WIRELESSACCESS POINT

FURNISHINGS SYMBOLS		
SYMBOL	NAME	DO=DEVICE OPTIONS
	RACK OR HEAD END	AV-AUDIO/VIDEO C-CONTROL D-DATA SEC-SECURITY
	LIFT/MOUNT	A-ARTICULATED M-MOTORISED UB-UNDER BED

EXAMPLES: SYMBOL + MOUNTING OPTION		
SYMBOL	NAME	MOUNT TYPE
	SPEAKER	CEILING MOUNTED
	SPEAKER	WALL MOUNTED
	SPEAKER	FLOOR MOUNTED
	PRE-WIRE SPEAKER	CEILING MOUNTED PRE-WIRE ONLY NO CUTOUT

CABLING OPTIONS			
	SPKR	2CX2.5 mm²	SPEAKER CABLE
	COXL	COAXIAL	SUBWOOFER CABLE
	CAT6	CAT6	DATA CABLE
	HDMI	HDMI	VIDEO CABLE

Client : CLINICAL RETREAT

Location : ANAND

Created 13-06-2017
 Modified Not yet
 Printed Not yet

Drawing Name :
ROOM MODES


Drawing Type :
ROOM MODES

Drawing Scale : SCALE TO FIT

Designed by Ruchi

Checked by Ankur Bhatt

HC-052/11

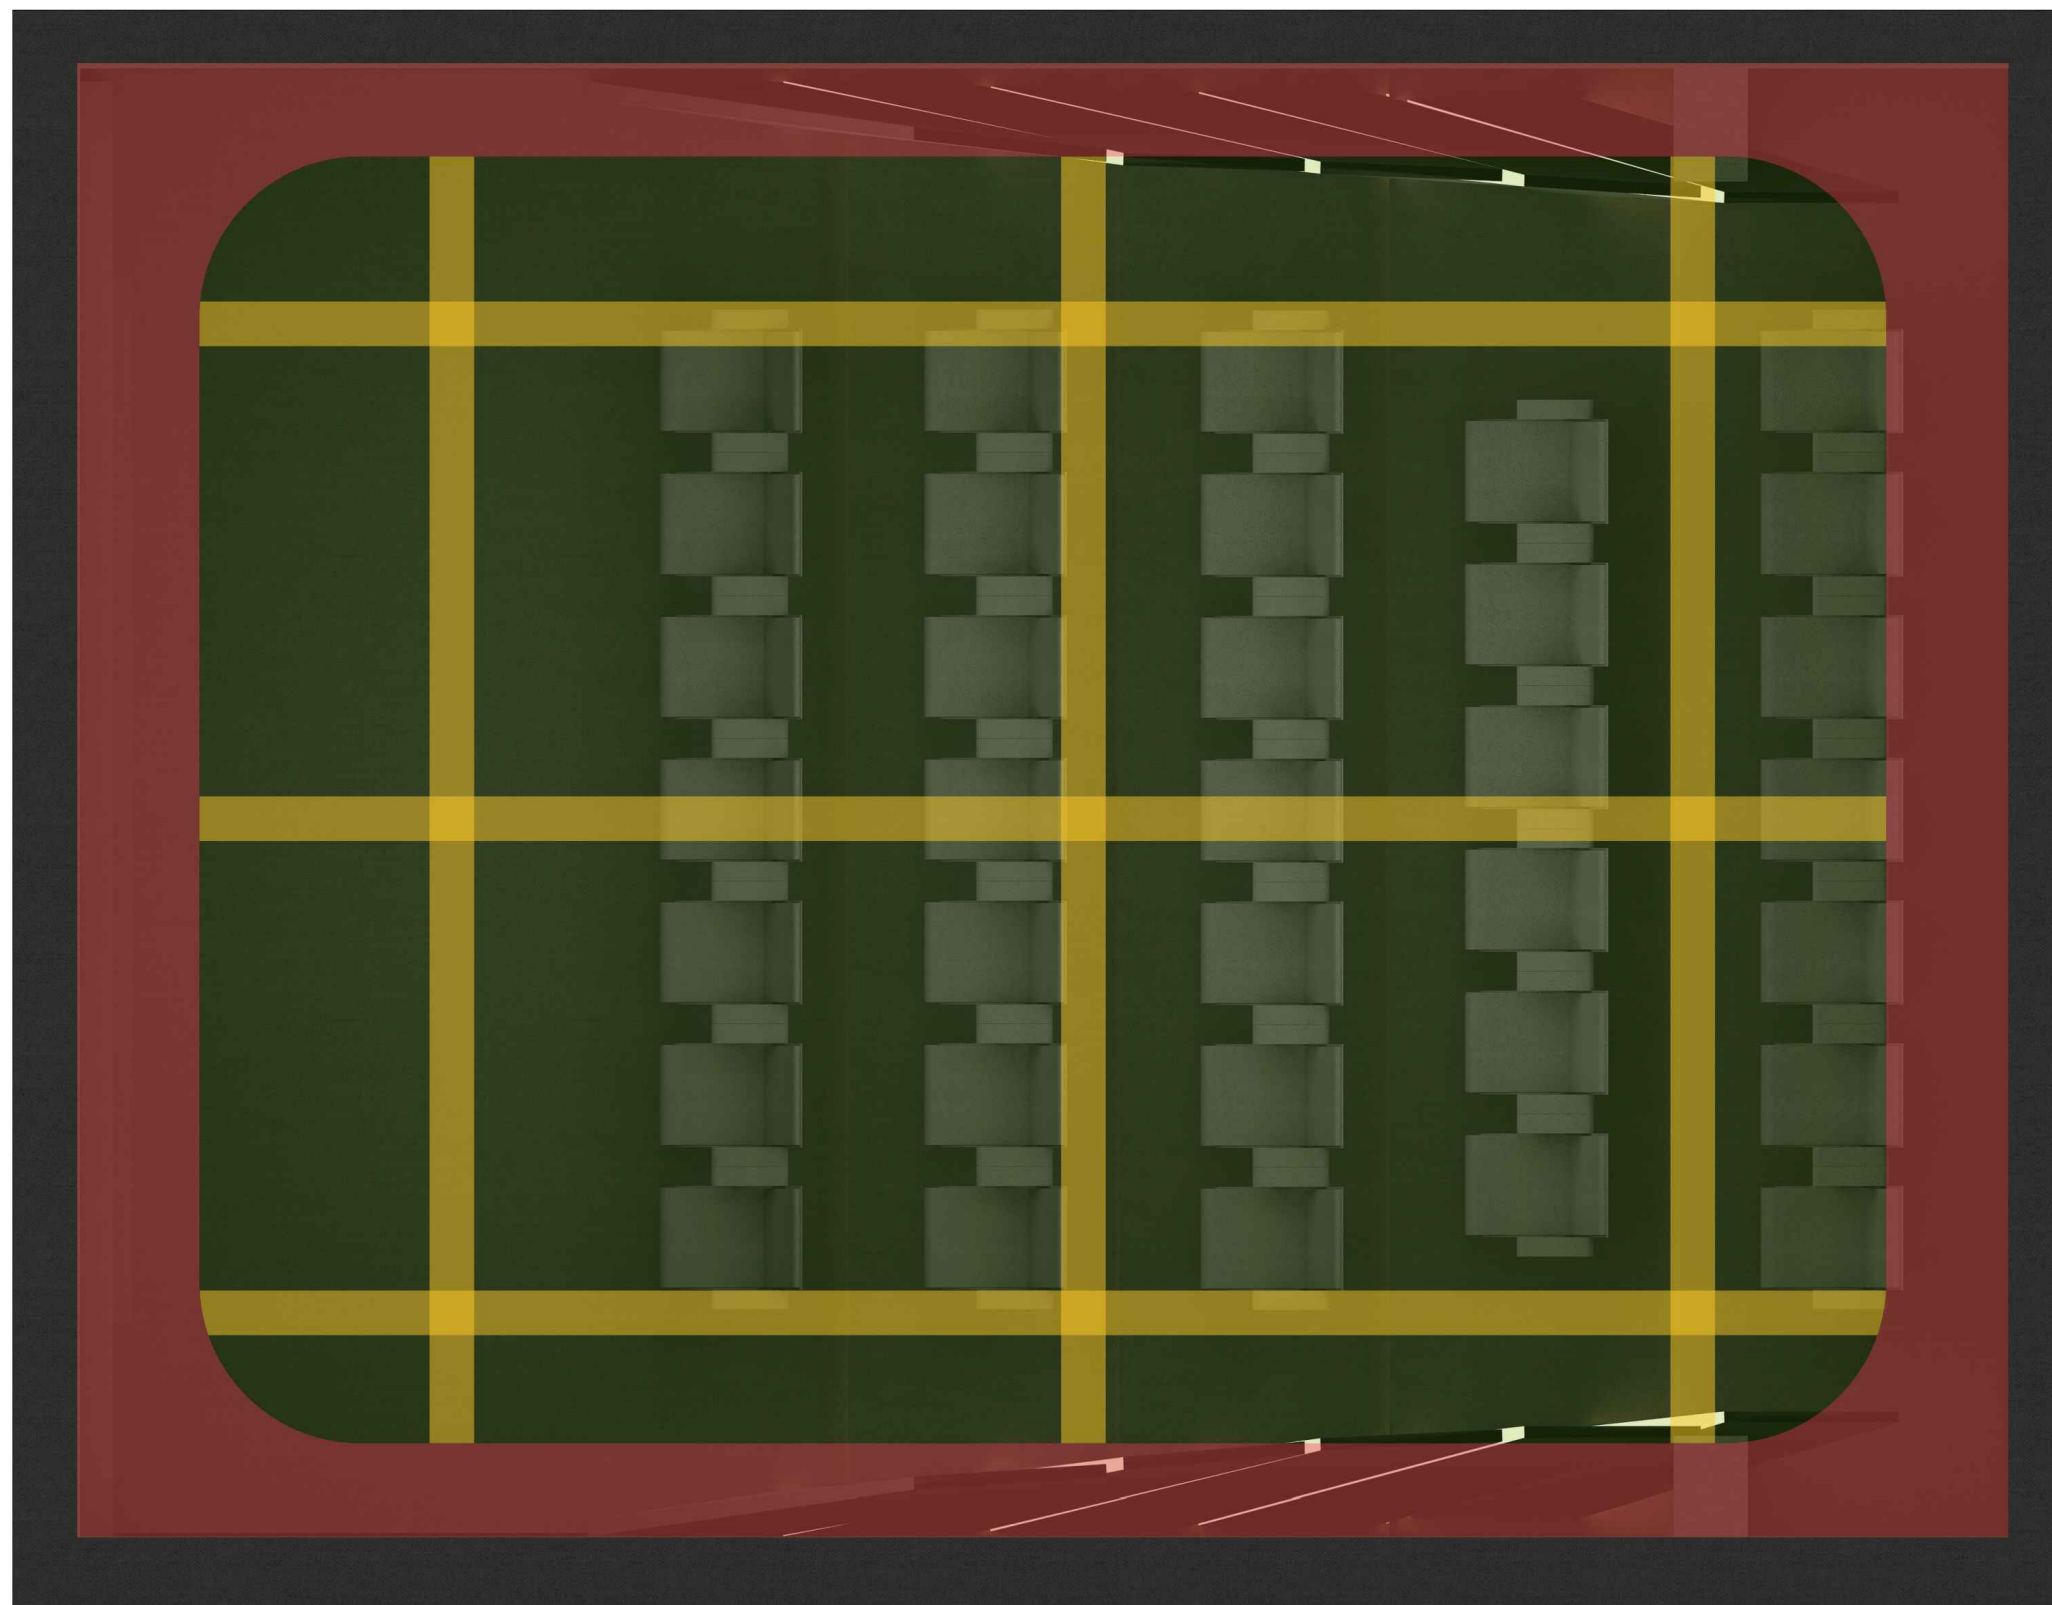

RED ZONE

In the proximity of the walls there are strong modal peaks

YELLOW ZONE

there are two lowest frequency (and typically strongest) modes null and peak

GREEN ZONE

there are moderated peaking and no nulling

AUDIO VIDEO SYMBOLS			
SYMBOL	NAME	DO=DEVICE OPTIONS	
	SPEAKER	LCR-LCR BAR SU-SUBWOOFER ST-STEREO	
	VIDEO PROJECTOR	LCD-LIQUID CRYSTAL DISPLAY DLP-DIGITAL LIGHT PROCESSOR SXRD-SILICON X-TEL REF. DISP.	
	PROJECTOR SCREEN	F-FIXED M-MOTORISED	
COMMUNICATIONS SYMBOLS			
SYMBOL	NAME	DO=DEVICE OPTIONS	
	PHONE AND DATA PORT	D-DATA F-FIBRE OPTIC P-PHONE	
	INCOMING SERVICES	CTV-CABLE TV P-PHONE S-SATELLITE	
	RF REPEATER ACCESS POINT	CR-CELLULAR PR-PHONE WAP-WIRELESSACCESS POINT	
FURNISHINGS SYMBOLS			
SYMBOL	NAME	DO=DEVICE OPTIONS	
	RACK OR HEAD END	AV-AUDIO/VIDEO C-CONTROL D-DATA SEC-SECURITY	
	LIFT/MOUNT	A-ARTICULATED M-MOTORISED UB-UNDER BED	
EXAMPLES: SYMBOL + MOUNTING OPTION			
SYMBOL	NAME	MOUNT TYPE	
	SPEAKER	CEILING MOUNTED	
	SPEAKER	WALL MOUNTED	
	SPEAKER	FLOOR MOUNTED	
	PRE-WIRE SPEAKER	CEILING MOUNTED PRE-WIRE ONLY NO CUTOUT	
CABLING OPTIONS			
	SPKR	2CX2.5 mm ²	SPEAKER CABLE
	COXL	COAXIAL	SUBWOOFER CABLE
	CAT6	CAT6	DATA CABLE
	HDMI	HDMI	VIDEO CABLE

Client : CLINICAL RETREAT

Location : ANAND

Created 13-06-2017
Modified Not yet
Printed Not yet

Drawing Name :
3D VISUALIZATION


Drawing Type :
ROOM MODES

Drawing Scale : SCALE TO FIT

Designed by Chirantan

Checked by Ankur Bhatt

HC-052/11.1

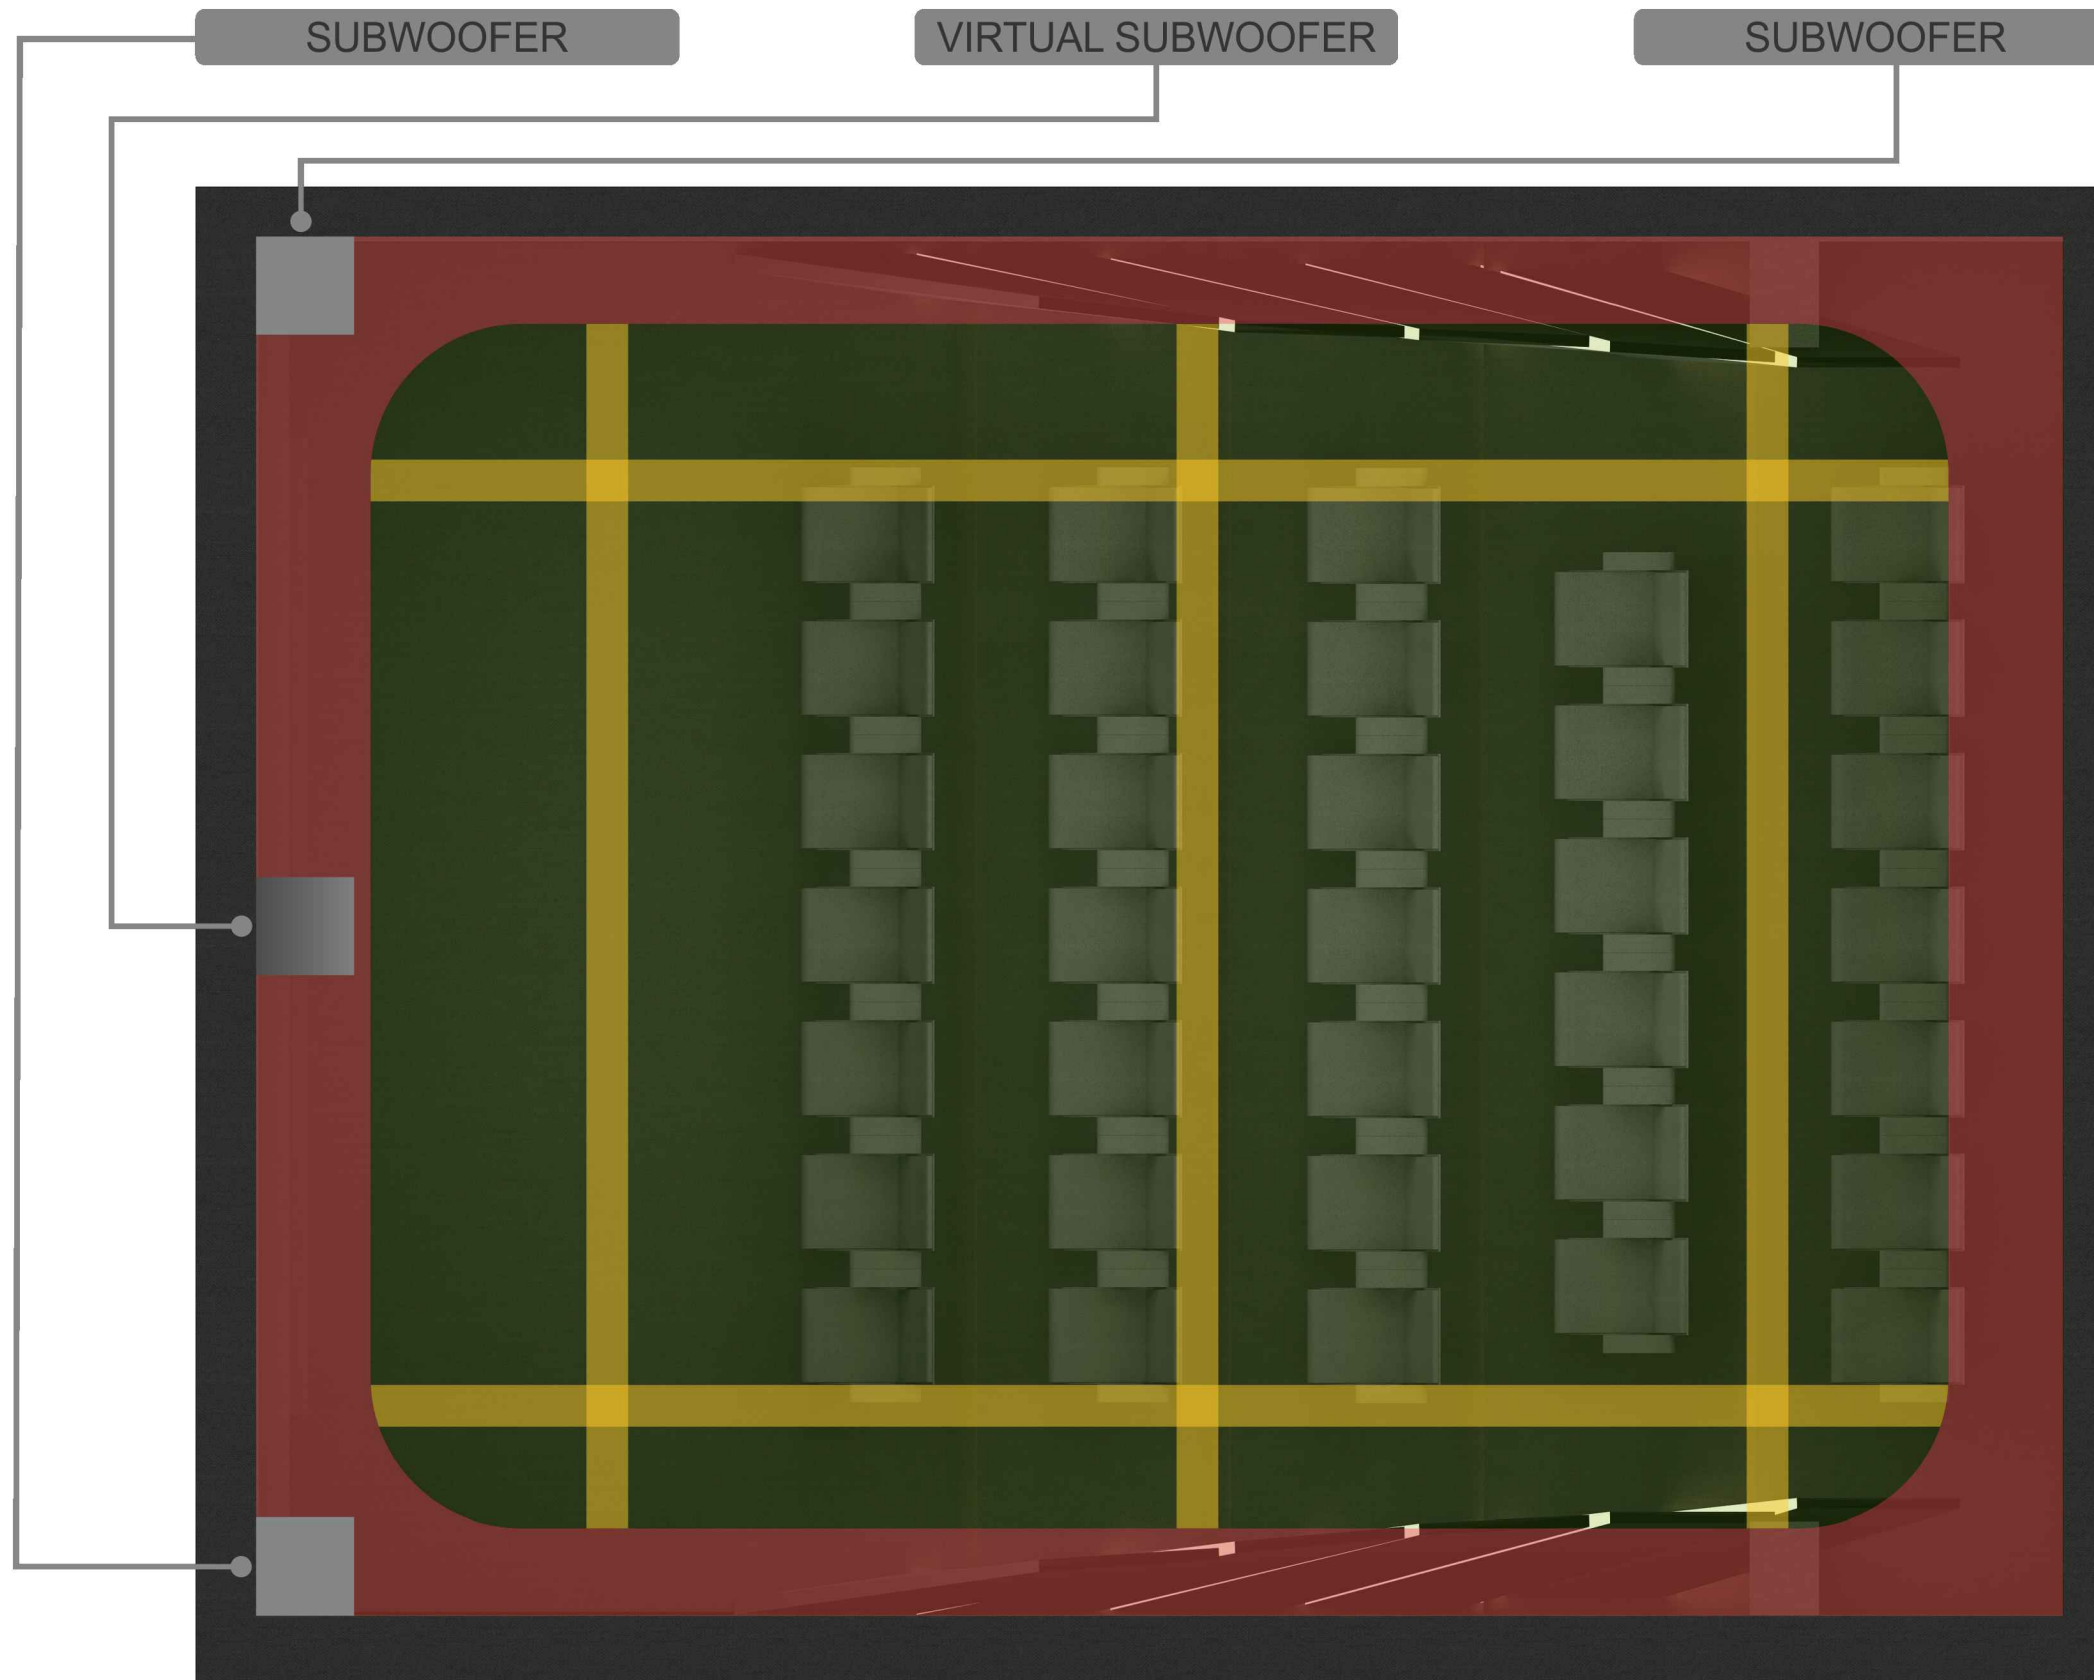

RED ZONE

In the proximity of the walls there are strong modal peaks

YELLOW ZONE

there are two lowest frequency (and typically strongest) modes null and peak

GREEN ZONE

there are moderated peaking and no nulling

AUDIO VIDEO SYMBOLS			
SYMBOL	NAME	DO=DEVICE OPTIONS	
	SPEAKER	LCR-LCR BAR SU-SUBWOOFER ST-STEREO	
	VIDEO PROJECTOR	LCD-LIQUID CRYSTAL DISPLAY DLP-DIGITAL LIGHT PROCESSOR SXRD-SILICON X-TEL REF. DISP.	
	PROJECTOR SCREEN	F-FIXED M-MOTORISED	
COMMUNICATIONS SYMBOLS			
SYMBOL	NAME	DO=DEVICE OPTIONS	
	PHONE AND DATA PORT	D-DATA F-FIBRE OPTIC P-PHONE	
	INCOMING SERVICES	CTV-CABLE TV P-PHONE S-SATELLITE	
	RF REPEATER ACCESS POINT	CR-CELLULAR PR-PHONE WAP-WIRELESSACCESS POINT	
FURNISHINGS SYMBOLS			
SYMBOL	NAME	DO=DEVICE OPTIONS	
	RACK OR HEAD END	AV-AUDIO/VIDEO C-CONTROL D-DATA SEC-SECURITY	
	LIFT/MOUNT	A-ARTICULATED M-MOTORISED UB-UNDER BED	
EXAMPLES: SYMBOL + MOUNTING OPTION			
SYMBOL	NAME	MOUNT TYPE	
	SPEAKER	CEILING MOUNTED	
	SPEAKER	WALL MOUNTED	
	SPEAKER	FLOOR MOUNTED	
	PRE-WIRE SPEAKER	CEILING MOUNTED PRE-WIRE ONLY NO CUTOUT	
CABLING OPTIONS			
	SPKR	2CX2.5 mm ²	SPEAKER CABLE
	COXL	COAXIAL	SUBWOOFER CABLE
	CAT6	CAT6	DATA CABLE
	HDMI	HDMI	VIDEO CABLE

Client : CLINICAL RETREAT

Location : ANAND

Created 13-06-2017
Modified Not yet
Printed Not yet

Drawing Name :
3D VISUALIZATION


Drawing Type :
ROOM MODES

Drawing Scale : SCALE TO FIT

Designed by Chirantan

Checked by Ankur Bhatt

HC-052/11.2

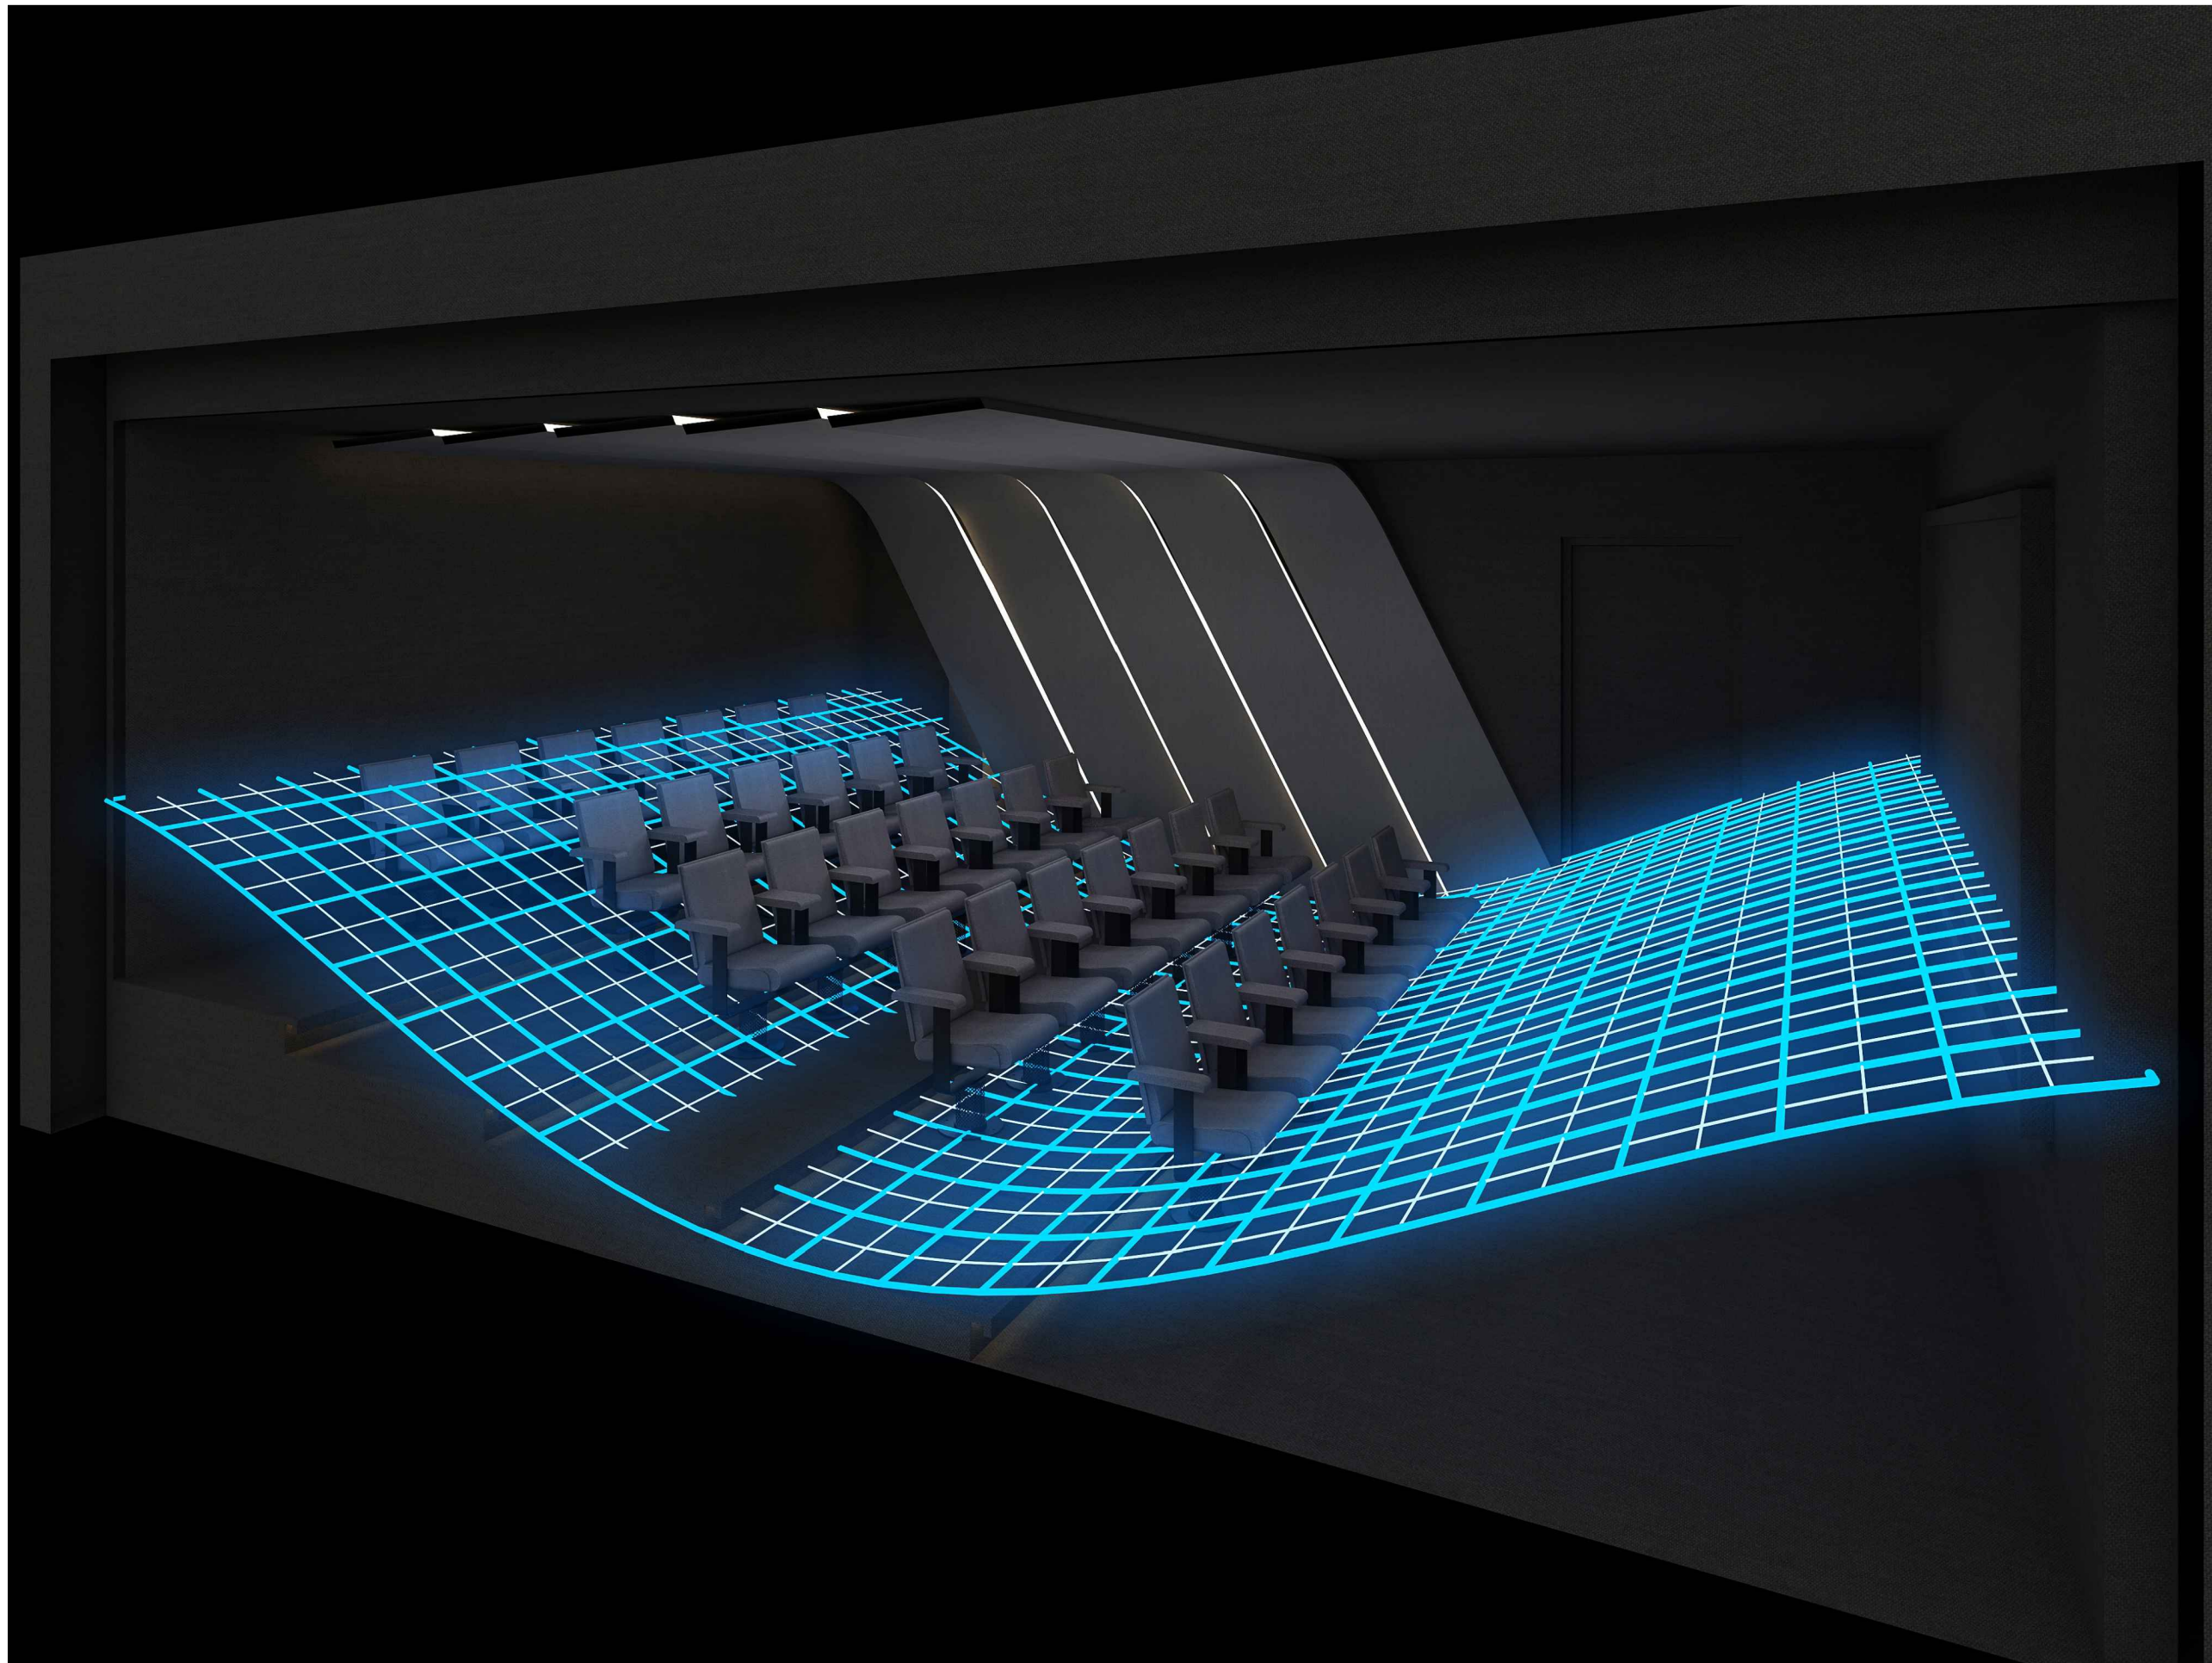

AUDIO VIDEO SYMBOLS		
SYMBOL	NAME	DO=DEVICE OPTIONS
	SPEAKER	LCR-LCR BAR SU-SUBWOOFER ST-STEREO
	VIDEO PROJECTOR	LCD-LIQUID CRYSTAL DISPLAY DLP-DIGITAL LIGHT PROCESSOR SXRD-SILICON X-TEL REF. DISP.
	PROJECTON SCREEN	F-FIXED M-MOTORISED

COMMUNICATIONS SYMBOLS		
SYMBOL	NAME	DO=DEVICE OPTIONS
	PHONE AND DATA PORT	D-DATA F-FIBRE OPTIC P-PHONE
	INCOMING SERVICES	CTV-CABLE TV P-PHONE S-SATELLITE
	RF REPEATER ACCESS POINT	CR-CELLUAR PR-PHONE WAP-WIRELESSACCESS POINT

FURNISHINGS SYMBOLS		
SYMBOL	NAME	DO=DEVICE OPTIONS
	RACK OR HEAD END	AV-AUDIO/VIDEO C-CONTROL D-DATA SEC-SECURITY
	LIFT/MOUNT	A-ARTICULATED M-MOTORISED UB-UNDER BED

EXAMPLES: SYMBOL + MOUNTING OPTION		
SYMBOL	NAME	MOUNT TYPE
	SPEAKER	CEILING MOUNTED
	SPEAKER	WALL MOUNTED
	SPEAKER	FLOOR MOUNTED
	PRE-WIRE SPEAKER	CEILING MOUNTED PRE-WIRE ONLY NO CUTOUT

CABLING OPTIONS			
	SPKR	2CX2.5 mm²	SPEAKER CABLE
	COXL	COAXIAL	SUBWOOFER CABLE
	CAT6	CAT6	DATA CABLE
	HDMI	HDMI	VIDEO CABLE

Client : CLINICAL RETREAT

Location : ANAND

Created 13-06-2017
Modified Not yet
Printed Not yet

Drawing Name :
3D VISUALIZATION


Drawing Type :
ROOM MODES

Drawing Scale : SCALE TO FIT

Designed by Chirantan

Checked by Ankur Bhatt

HC-052/11.3

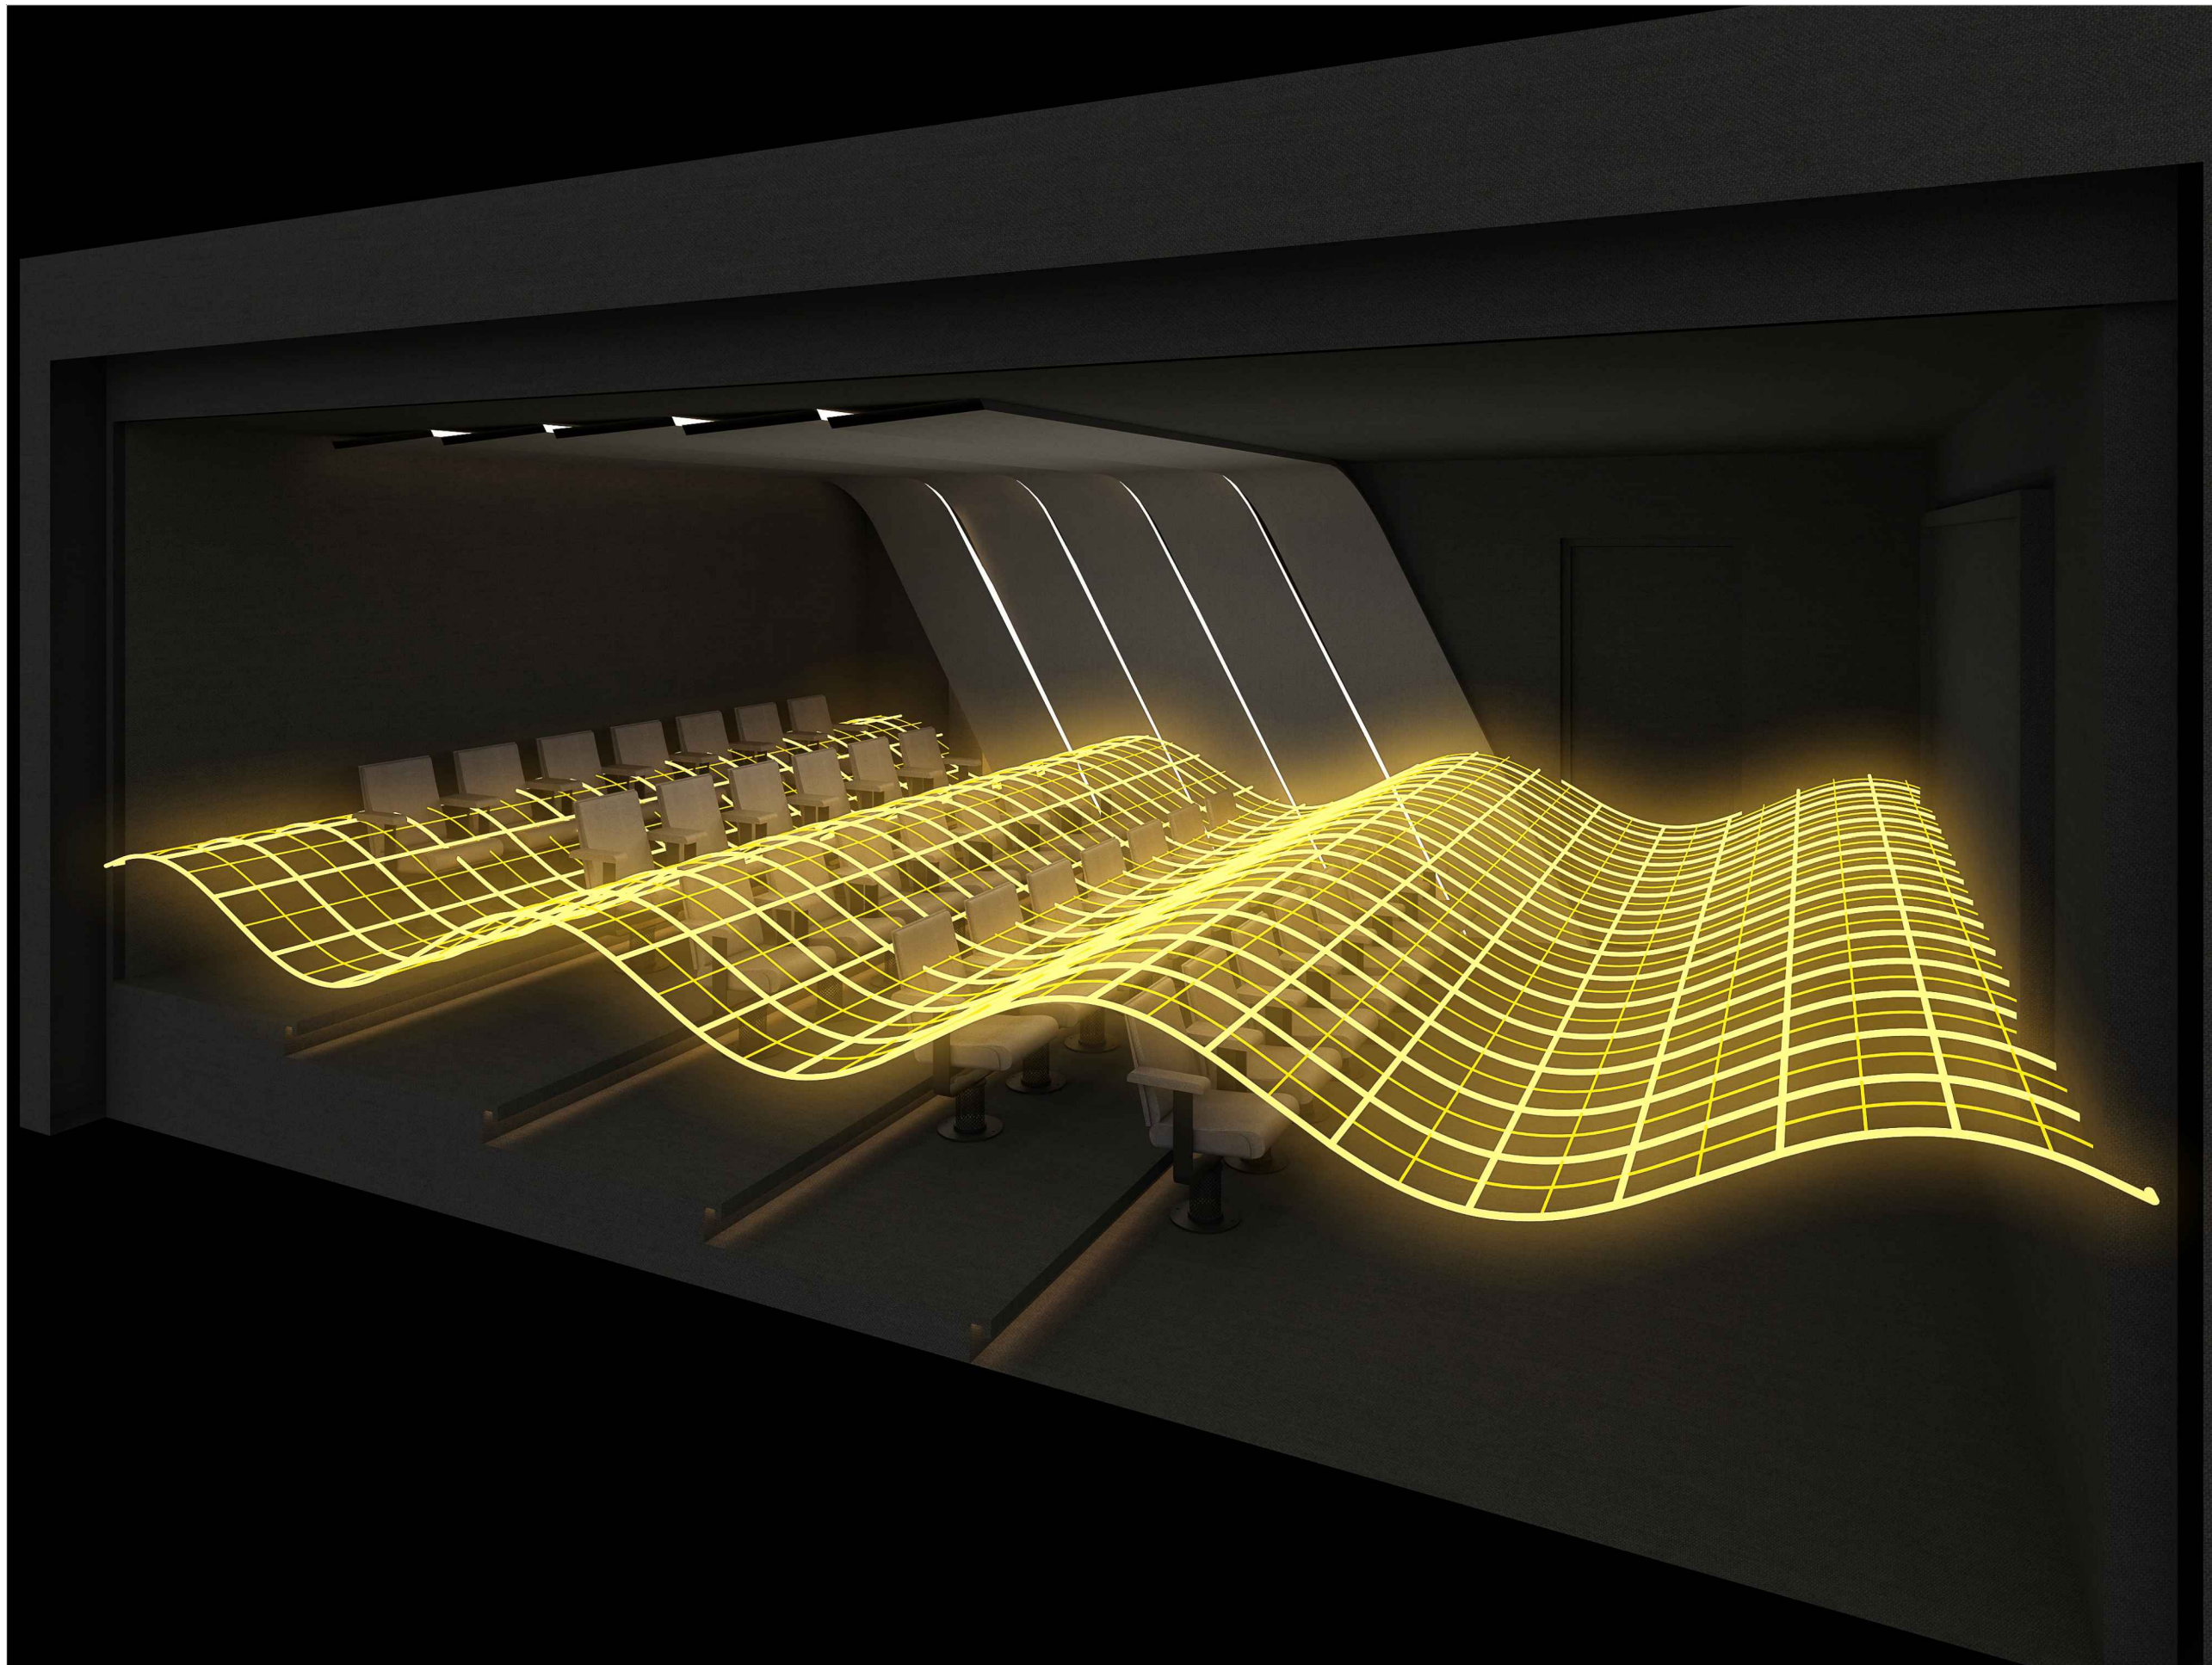

AUDIO VIDEO SYMBOLS		
SYMBOL	NAME	DO=DEVICE OPTIONS
	SPEAKER	LCR-LCR BAR SU-SUBWOOFER ST-STEREO
	VIDEO PROJECTOR	LCD-LIQUID CRYSTAL DISPLAY DLP-DIGITAL LIGHT PROCESSOR SXRD-SILICON X-TEL REF. DISP.
	PROJECTON SCREEN	F-FIXED M-MOTORISED

COMMUNICATIONS SYMBOLS		
SYMBOL	NAME	DO=DEVICE OPTIONS
	PHONE AND DATA PORT	D-DATA F-FIBRE OPTIC P-PHONE
	INCOMING SERVICES	CTV-CABLE TV P-PHONE S-SATELLITE
	RF REPEATER ACCESS POINT	CR-CELLUAR PR-PHONE WAP-WIRELESSACCESS POINT

FURNISHINGS SYMBOLS		
SYMBOL	NAME	DO=DEVICE OPTIONS
	RACK OR HEAD END	AV-AUDIO/VIDEO C-CONTROL D-DATA SEC-SECURITY
	LIFT/MOUNT	A-ARTICULATED M-MOTORISED UB-UNDER BED

EXAMPLES: SYMBOL + MOUNTING OPTION		
SYMBOL	NAME	MOUNT TYPE
	SPEAKER	CEILING MOUNTED
	SPEAKER	WALL MOUNTED
	SPEAKER	FLOOR MOUNTED
	PRE-WIRE SPEAKER	CEILING MOUNTED PRE-WIRE ONLY NO CUTOUT

CABLING OPTIONS			
	SPKR	2CX2.5 mm²	SPEAKER CABLE
	COXL	COAXIAL	SUBWOOFER CABLE
	CAT6	CAT6	DATA CABLE
	HDMI	HDMI	VIDEO CABLE

Client : CLINICAL RETREAT

Location : ANAND

Created 13-06-2017
 Modified Not yet
 Printed Not yet

Drawing Name :
 3D VISUALIZATION


Drawing Type :
 ROOM MODES

Drawing Scale : SCALE TO FIT

Designed by Chirantan

Checked by Ankur Bhatt

HC-052/11.4

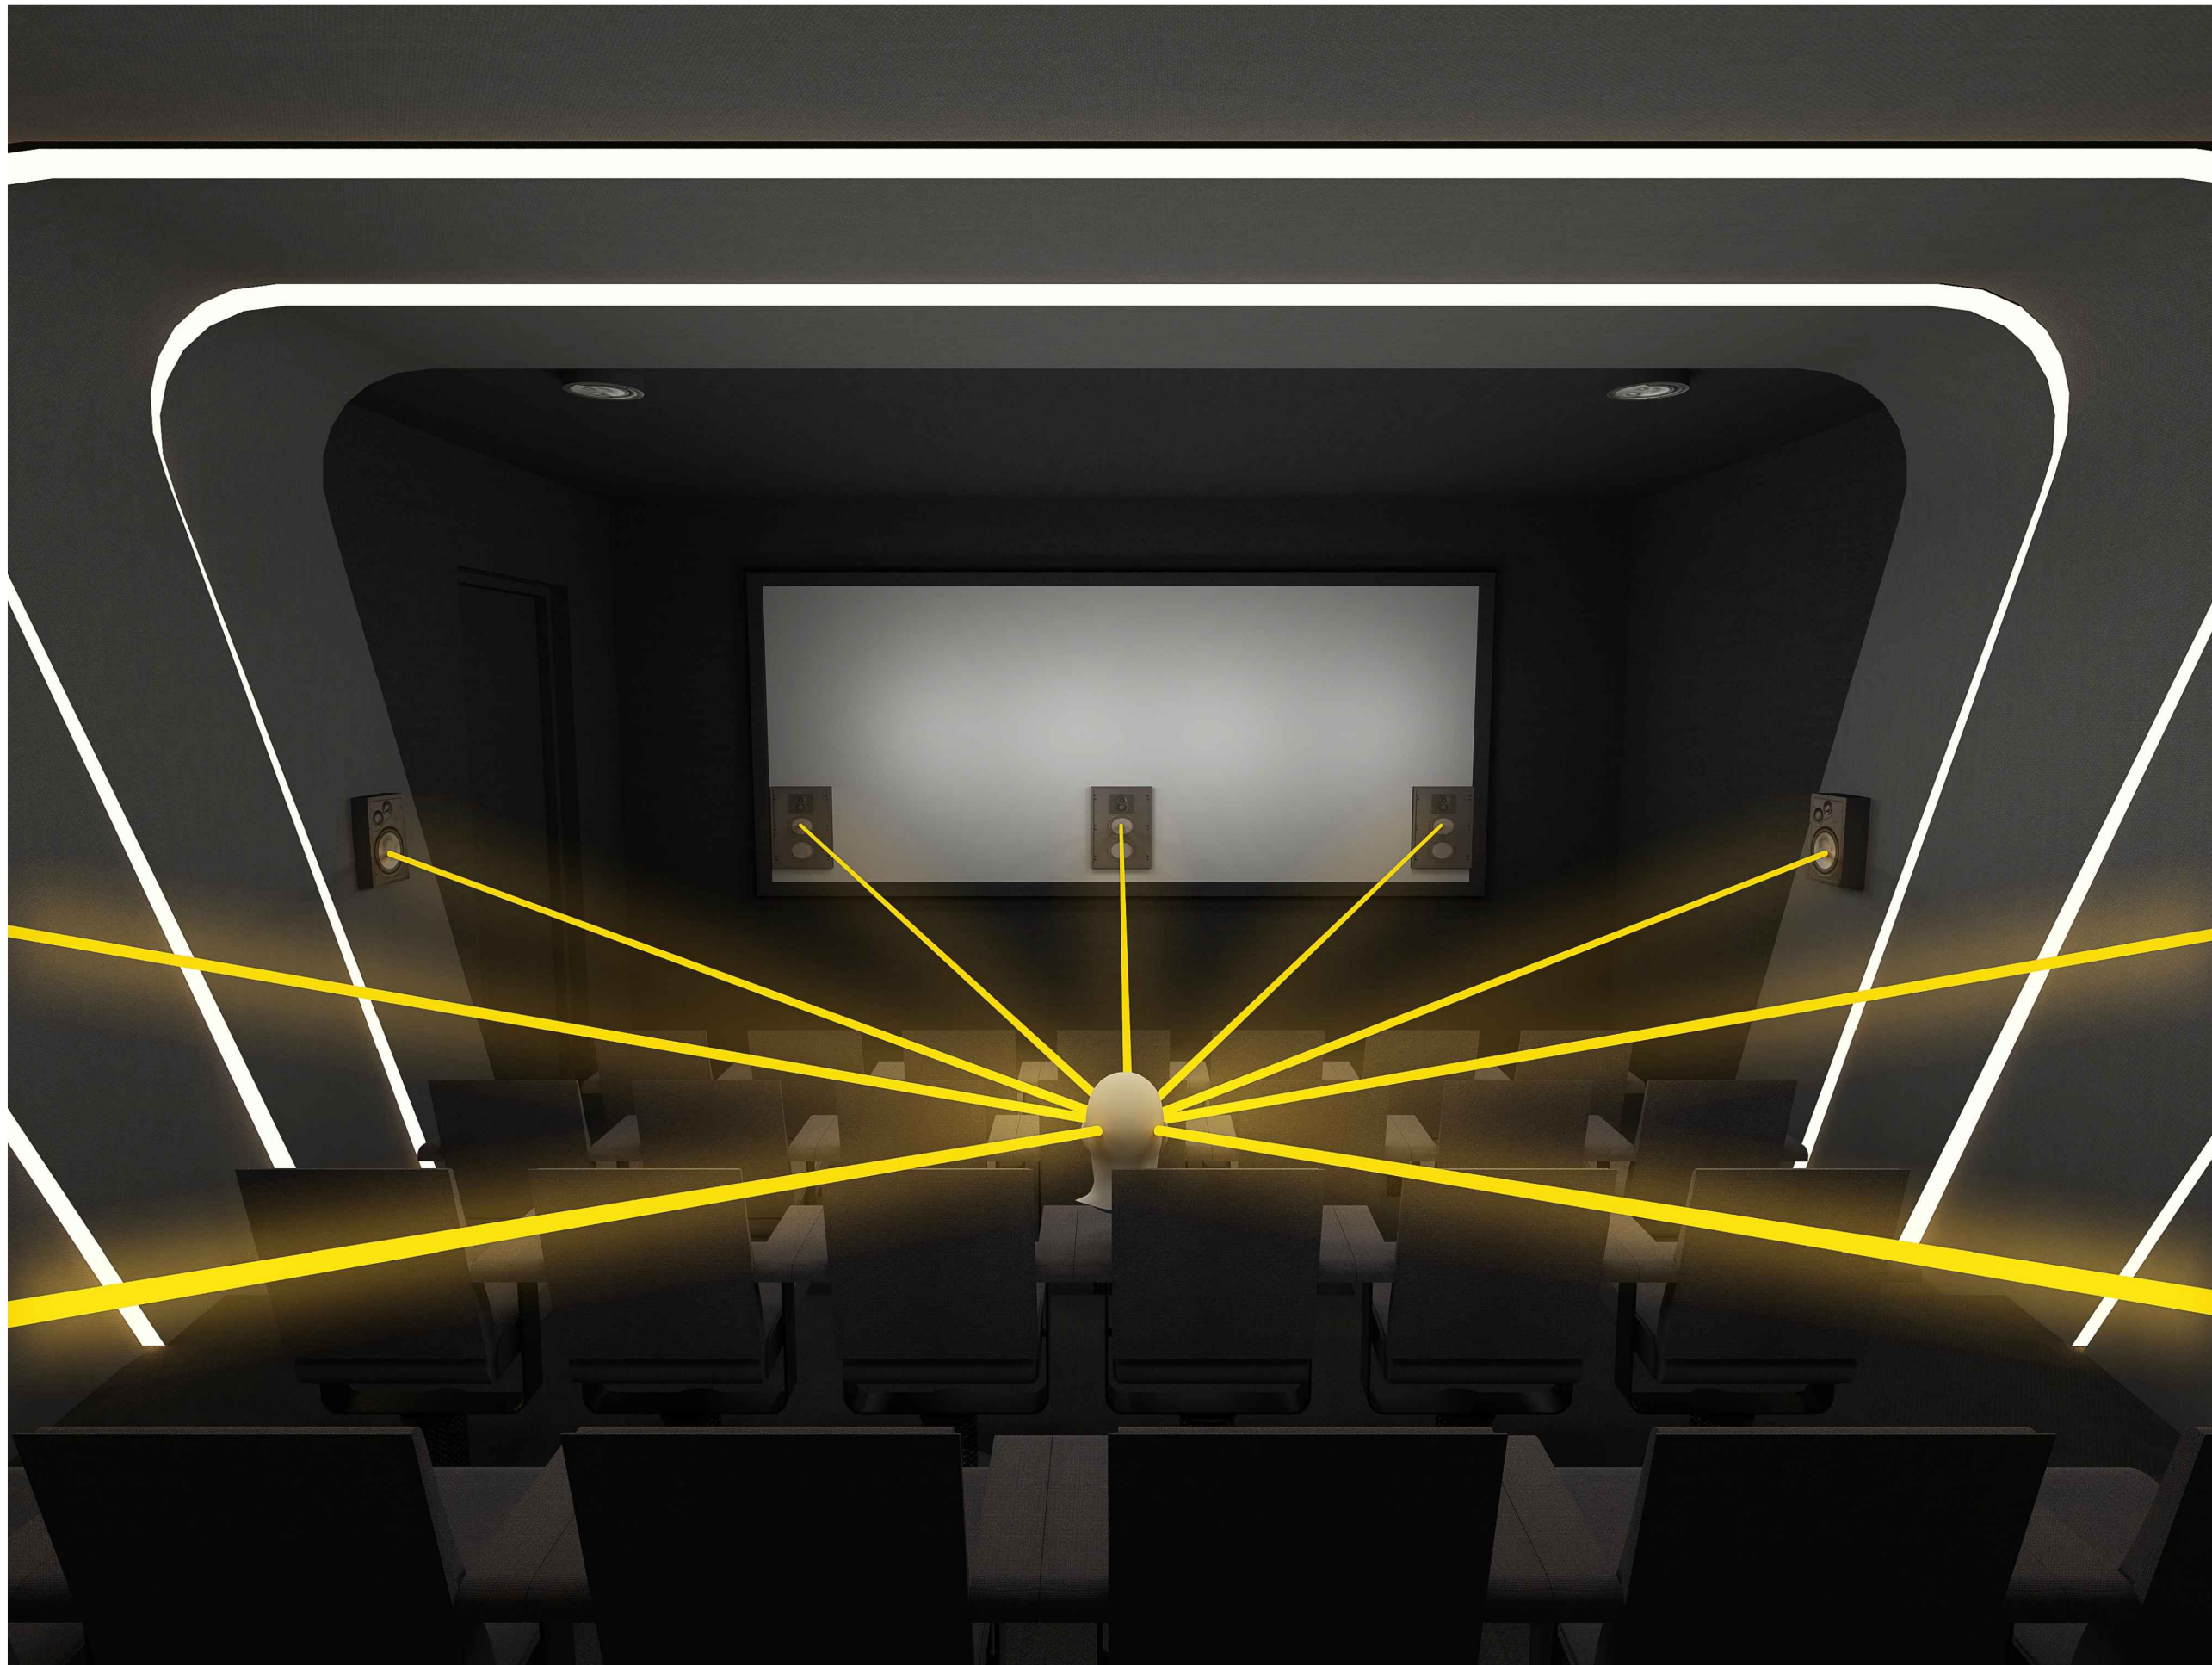

AUDIO VIDEO SYMBOLS		
SYMBOL	NAME	DO=DEVICE OPTIONS
	SPEAKER	LCR-LCR BAR SU-SUBWOOFER ST-STEREO
	VIDEO PROJECTOR	LCD-LIQUID CRYSTAL DISPLAY DLP-DIGITAL LIGHT PROCESSOR SXRD-SILICON X-TEL REF. DISP.
	PROJECTON SCREEN	F-FIXED M-MOTORISED

COMMUNICATIONS SYMBOLS		
SYMBOL	NAME	DO=DEVICE OPTIONS
	PHONE AND DATA PORT	D-DATA F-FIBRE OPTIC P-PHONE
	INCOMING SERVICES	CTV-CABLE TV P-PHONE S-SATELLITE
	RF REPEATER ACCESS POINT	CR-CELLUAR PR-PHONE WAP-WIRELESSACCESS POINT

FURNISHINGS SYMBOLS		
SYMBOL	NAME	DO=DEVICE OPTIONS
	RACK OR HEAD END	AV-AUDIO/VIDEO C-CONTROL D-DATA SEC-SECURITY
	LIFT/MOUNT	A-ARTICULATED M-MOTORISED UB-UNDER BED

EXAMPLES: SYMBOL + MOUNTING OPTION		
SYMBOL	NAME	MOUNT TYPE
	SPEAKER	CEILING MOUNTED
	SPEAKER	WALL MOUNTED
	SPEAKER	FLOOR MOUNTED
	PRE-WIRE SPEAKER	CEILING MOUNTED PRE-WIRE ONLY NO CUTOUT

CABLING OPTIONS			
	SPKR	2CX2.5 mm ²	SPEAKER CABLE
	COXL	COAXIAL	SUBWOOFER CABLE
	CAT6	CAT6	DATA CABLE
	HDMI	HDMI	VIDEO CABLE

Client : CLINICAL RETREAT

Location : ANAND

Created 13-06-2017
 Modified Not yet
 Printed Not yet

Drawing Name :
 3D VISUALIZATION


Drawing Type :
 ANGLES

Drawing Scale : SCALE TO FIT

Designed by Chirantan

Checked by Ankur Bhatt

HC-052/12

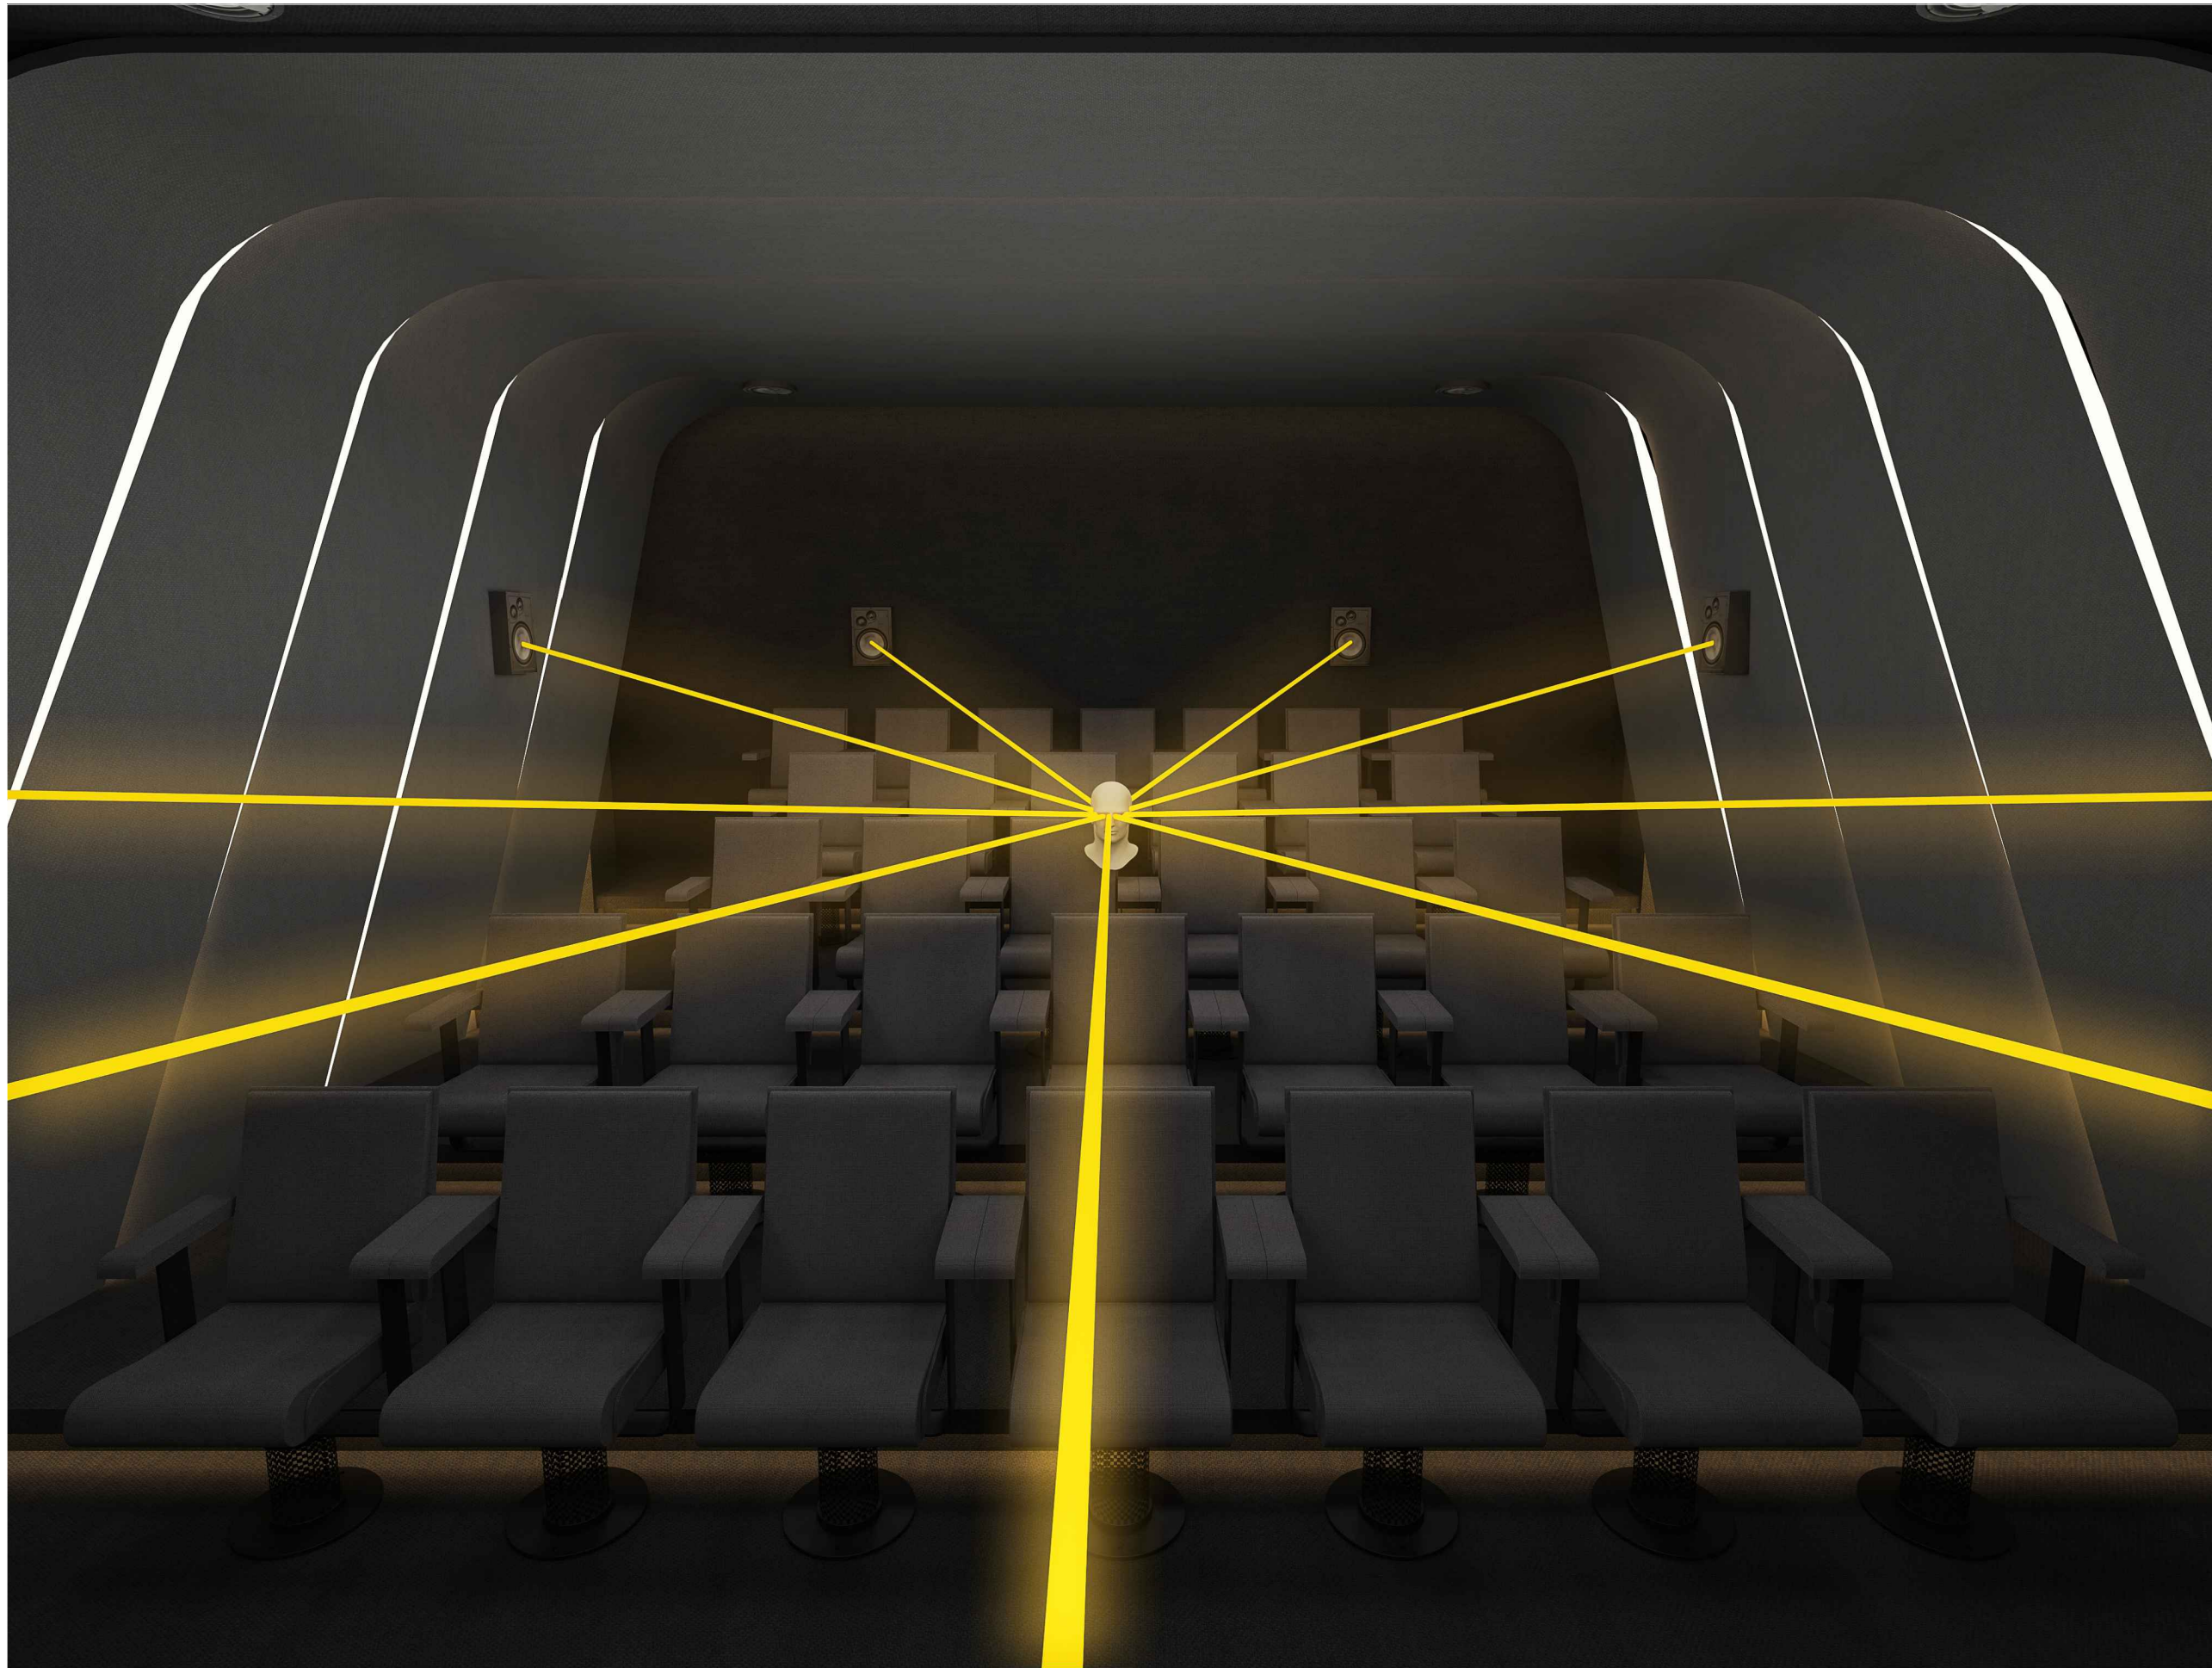

AUDIO VIDEO SYMBOLS		
SYMBOL	NAME	DO=DEVICE OPTIONS
	SPEAKER	LCR-LCR BAR SU-SUBWOOFER ST-STEREO
	VIDEO PROJECTOR	LCD-LIQUID CRYSTAL DISPLAY DLP-DIGITAL LIGHT PROCESSOR SXRD-SILICON X-TEL REF. DISP.
	PROJECTON SCREEN	F-FIXED M-MOTORISED

COMMUNICATIONS SYMBOLS		
SYMBOL	NAME	DO=DEVICE OPTIONS
	PHONE AND DATA PORT	D-DATA F-FIBRE OPTIC P-PHONE
	INCOMING SERVICES	CTV-CABLE TV P-PHONE S-SATELLITE
	RF REPEATER ACCESS POINT	CR-CELLUAR PR-PHONE WAP-WIRELESSACCESS POINT

FURNISHINGS SYMBOLS		
SYMBOL	NAME	DO=DEVICE OPTIONS
	RACK OR HEAD END	AV-AUDIO/VIDEO C-CONTROL D-DATA SEC-SECURITY
	LIFT/MOUNT	A-ARTICULATED M-MOTORISED UB-UNDER BED

EXAMPLES: SYMBOL + MOUNTING OPTION		
SYMBOL	NAME	MOUNT TYPE
	SPEAKER	CEILING MOUNTED
	SPEAKER	WALL MOUNTED
	SPEAKER	FLOOR MOUNTED
	PRE-WIRE SPEAKER	CEILING MOUNTED PRE-WIRE ONLY NO CUTOUT

CABLING OPTIONS			
	SPKR	2CX2.5 mm²	SPEAKER CABLE
	COXL	COAXIAL	SUBWOOFER CABLE
	CAT6	CAT6	DATA CABLE
	HDMI	HDMI	VIDEO CABLE

Client : CLINICAL RETREAT

Location : ANAND

Created 13-06-2017
 Modified Not yet
 Printed Not yet

Drawing Name :
 3D VISUALIZATION

Drawing Type :
 ANGLES

Drawing Scale : SCALE TO FIT


Designed by Chirantan

Checked by Ankur Bhatt

HC-052/12.1

12 3D VISULIZATION-ANGLES

SCALE: TO FIT

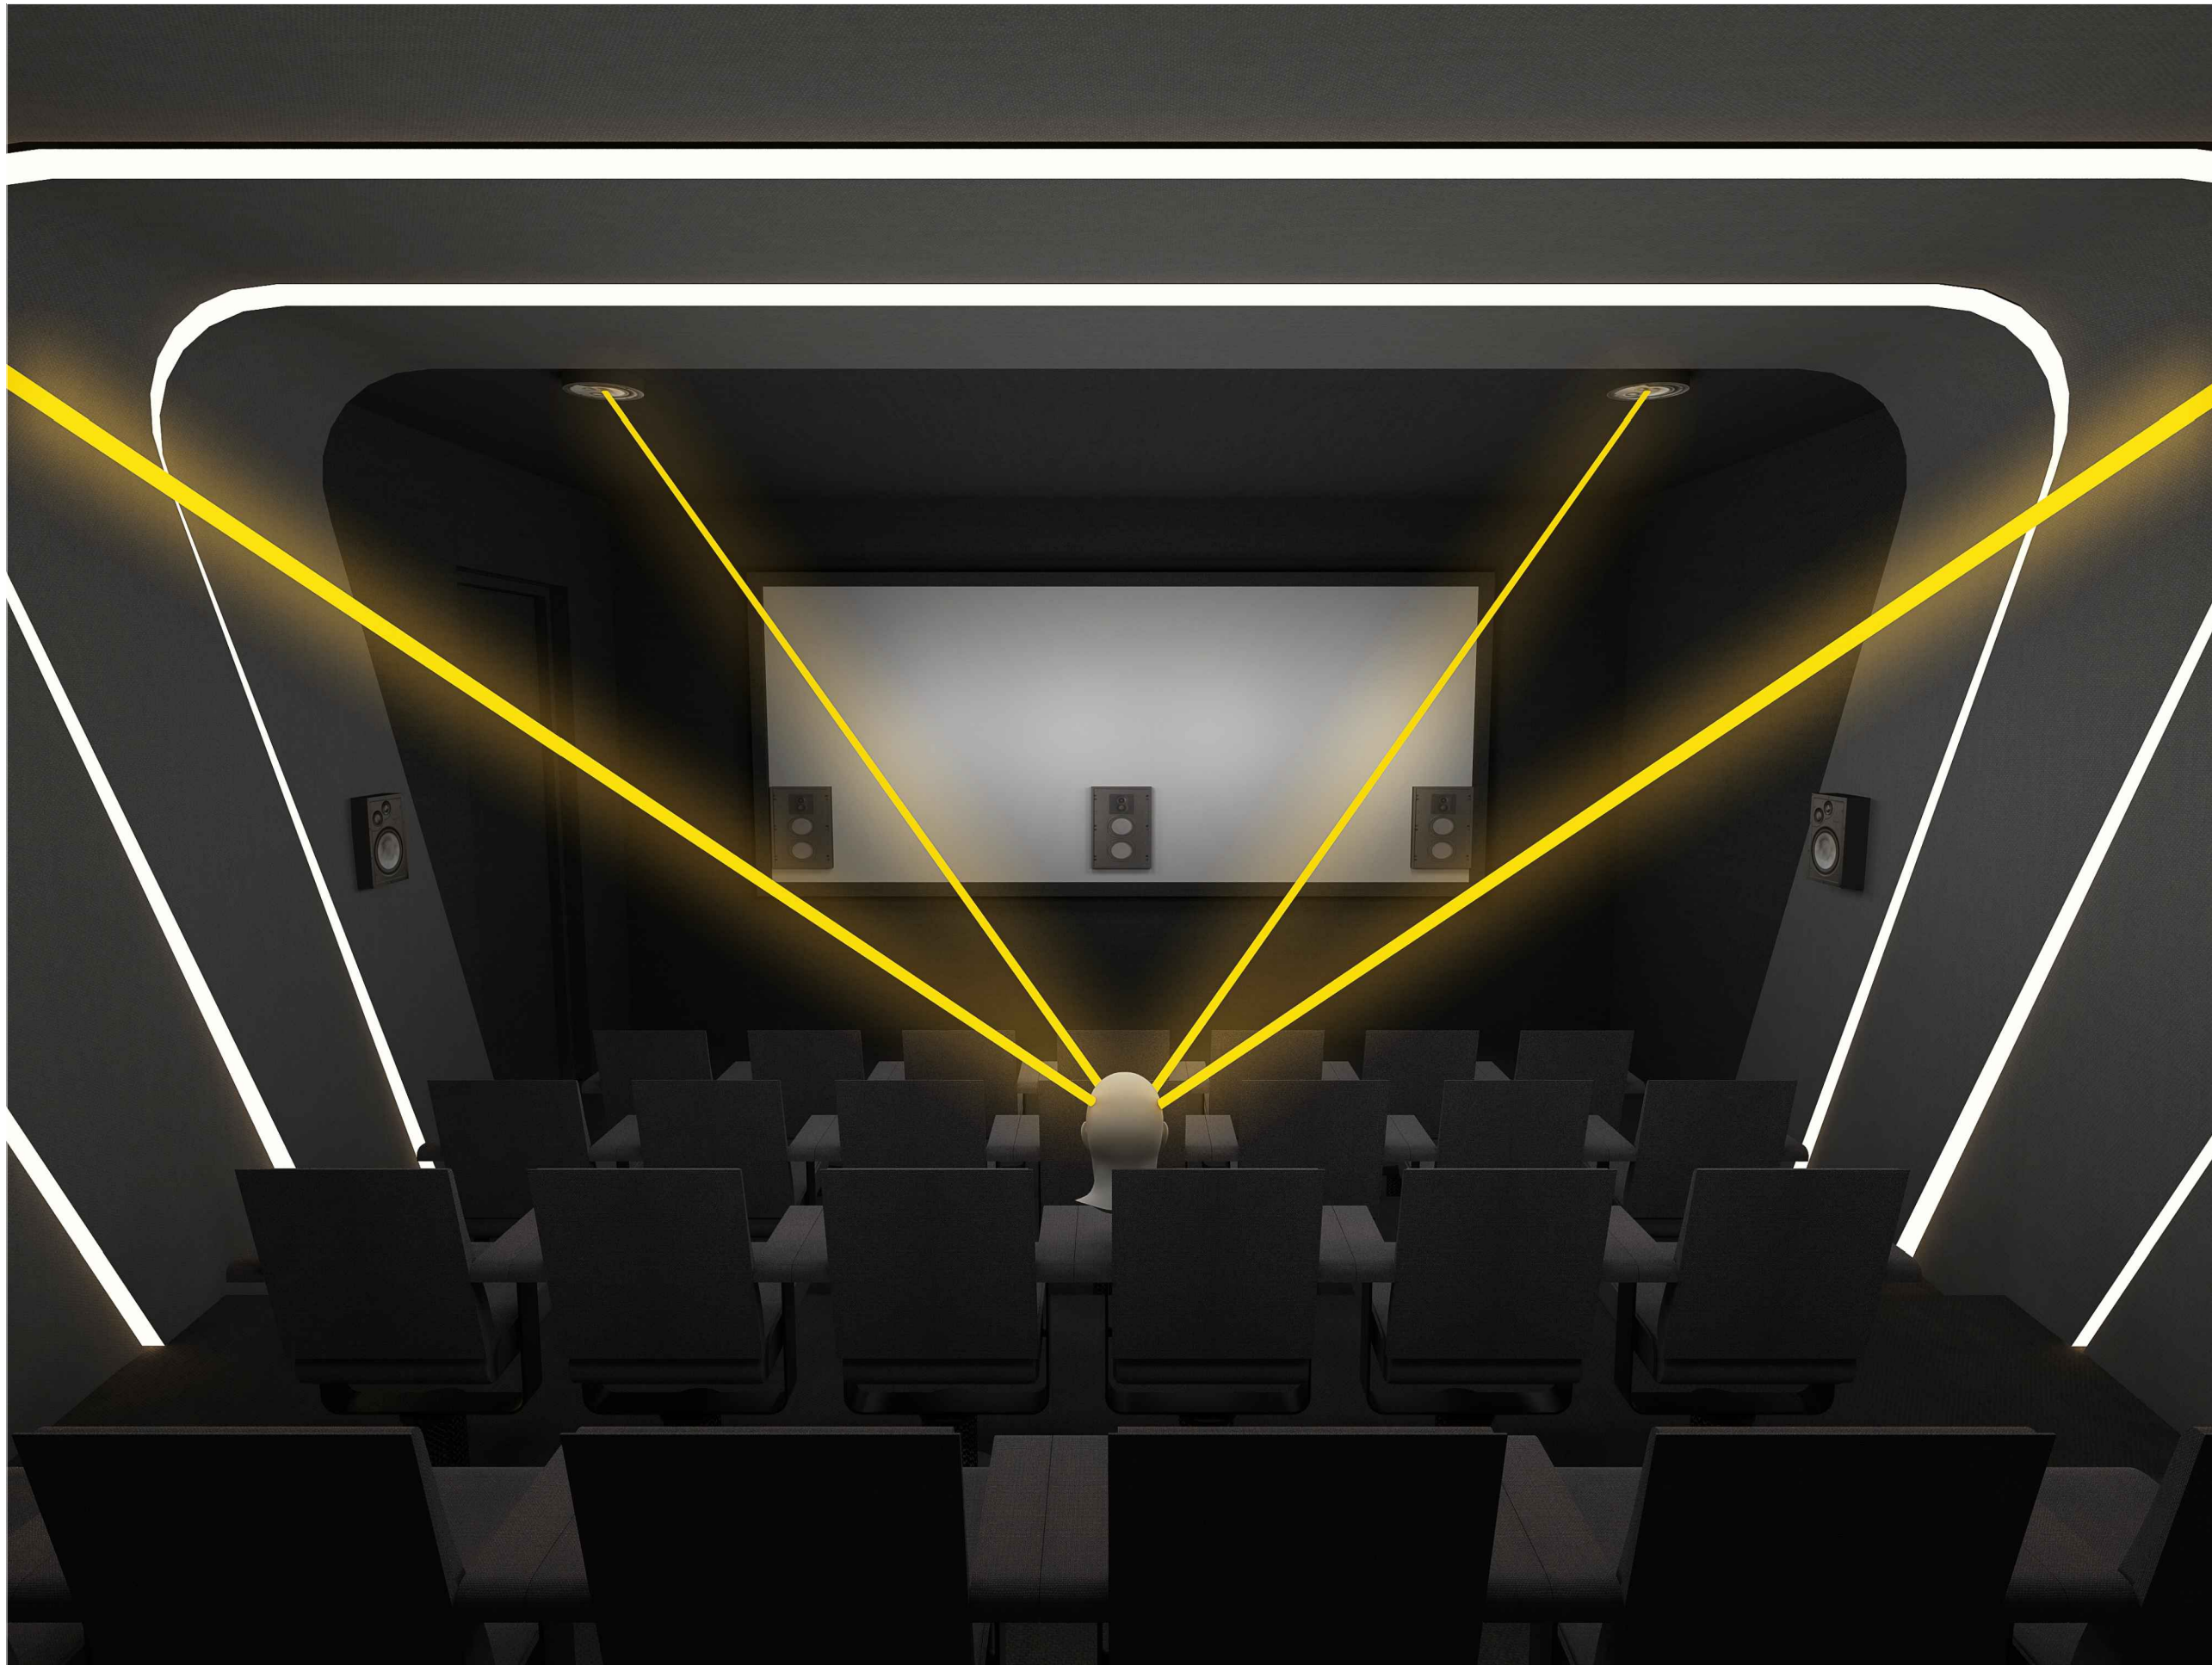

AUDIO VIDEO SYMBOLS		
SYMBOL	NAME	DO=DEVICE OPTIONS
	SPEAKER	LCR-LCR BAR SU-SUBWOOFER ST-STEREO
	VIDEO PROJECTOR	LCD-LIQUID CRYSTAL DISPLAY DLP-DIGITAL LIGHT PROCESSOR SXRD-SILICON X-TEL REF. DISP.
	PROJECTOR SCREEN	F-FIXED M-MOTORISED

COMMUNICATIONS SYMBOLS		
SYMBOL	NAME	DO=DEVICE OPTIONS
	PHONE AND DATA PORT	D-DATA F-FIBRE OPTIC P-PHONE
	INCOMING SERVICES	CTV-CABLE TV P-PHONE S-SATELLITE
	RF REPEATER ACCESS POINT	CR-CELLUAR PR-PHONE WAP-WIRELESSACCESS POINT

FURNISHINGS SYMBOLS		
SYMBOL	NAME	DO=DEVICE OPTIONS
	RACK OR HEAD END	AV-AUDIO/VIDEO C-CONTROL D-DATA SEC-SECURITY
	LIFT/MOUNT	A-ARTICULATED M-MOTORISED UB-UNDER BED

EXAMPLES: SYMBOL + MOUNTING OPTION		
SYMBOL	NAME	MOUNT TYPE
	SPEAKER	CEILING MOUNTED
	SPEAKER	WALL MOUNTED
	SPEAKER	FLOOR MOUNTED
	PRE-WIRE SPEAKER	CEILING MOUNTED PRE-WIRE ONLY NO CUTOUT

CABLING OPTIONS			
	SPKR	2CX2.5 mm²	SPEAKER CABLE
	COXL	COAXIAL	SUBWOOFER CABLE
	CAT6	CAT6	DATA CABLE
	HDMI	HDMI	VIDEO CABLE

Client : CLINICAL RETREAT

Location : ANAND

Created 13-06-2017
 Modified Not yet
 Printed Not yet

Drawing Name :
 3D VISUALIZATION


Drawing Type :
 ANGLES

Drawing Scale : SCALE TO FIT

Designed by Chirantan

Checked by Ankur Bhatt

HC-052/12.3

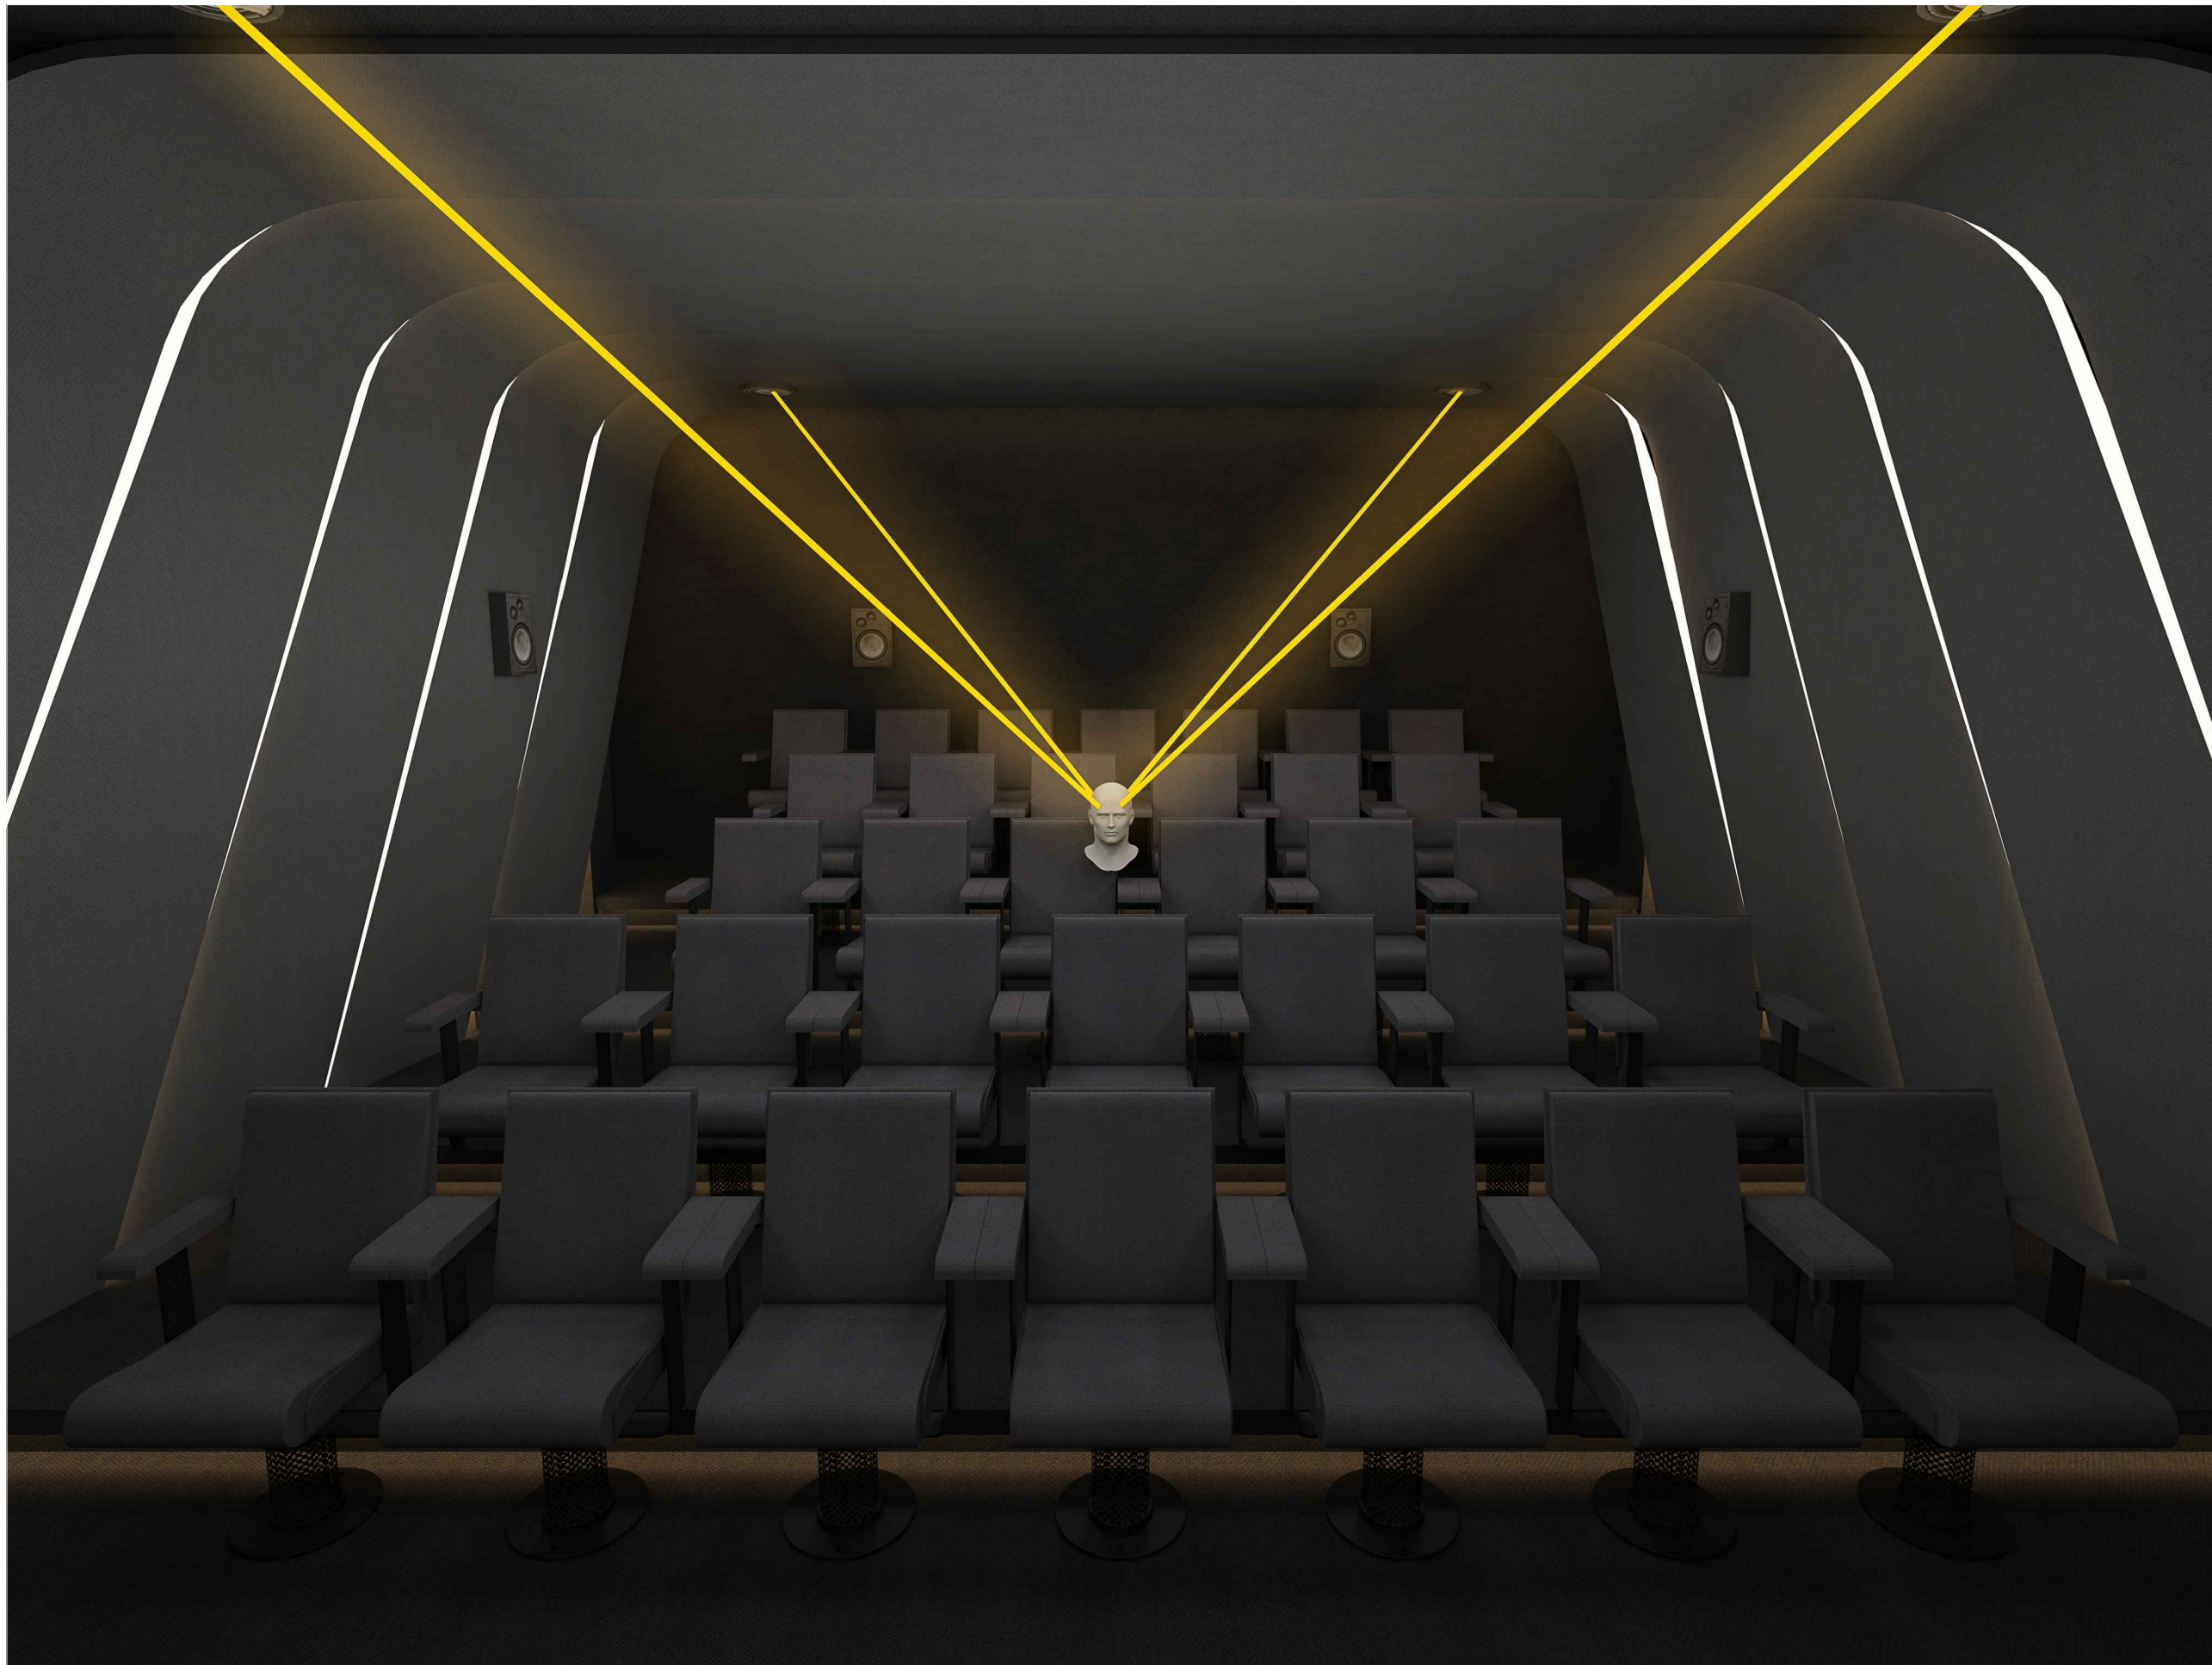

AUDIO VIDEO SYMBOLS		
SYMBOL	NAME	DO=DEVICE OPTIONS
	SPEAKER	LCR-LCR BAR SU-SUBWOOFER ST-STEREO
	VIDEO PROJECTOR	LCD-LIQUID CRYSTAL DISPLAY DLP-DIGITAL LIGHT PROCESSOR SXRD-SILICON X-TEL REF. DISP.
	PROJECTON SCREEN	F-FIXED M-MOTORISED

COMMUNICATIONS SYMBOLS		
SYMBOL	NAME	DO=DEVICE OPTIONS
	PHONE AND DATA PORT	D-DATA F-FIBRE OPTIC P-PHONE
	INCOMING SERVICES	CTV-CABLE TV P-PHONE S-SATELLITE
	RF REPEATER ACCESS POINT	CR-CELLUAR PR-PHONE WAP-WIRELESSACCESS POINT

FURNISHINGS SYMBOLS		
SYMBOL	NAME	DO=DEVICE OPTIONS
	RACK OR HEAD END	AV-AUDIO/VIDEO C-CONTROL D-DATA SEC-SECURITY
	LIFT/MOUNT	A-ARTICULATED M-MOTORISED UB-UNDER BED

EXAMPLES: SYMBOL + MOUNTING OPTION		
SYMBOL	NAME	MOUNT TYPE
	SPEAKER	CEILING MOUNTED
	SPEAKER	WALL MOUNTED
	SPEAKER	FLOOR MOUNTED
	PRE-WIRE SPEAKER	CEILING MOUNTED PRE-WIRE ONLY NO CUTOUT

CABLING OPTIONS			
	SPKR	2CX2.5 mm²	SPEAKER CABLE
	COXL	COAXIAL	SUBWOOFER CABLE
	CAT6	CAT6	DATA CABLE
	HDMI	HDMI	VIDEO CABLE

Client : CLINICAL RETREAT

Location : ANAND

Created 13-06-2017
 Modified Not yet
 Printed Not yet

Drawing Name :
 3D VISUALIZATION


Drawing Type :
 ANGLES

Drawing Scale : SCALE TO FIT


Designed by Chirantan

Checked by Ankur Bhatt

HC-052/12.4

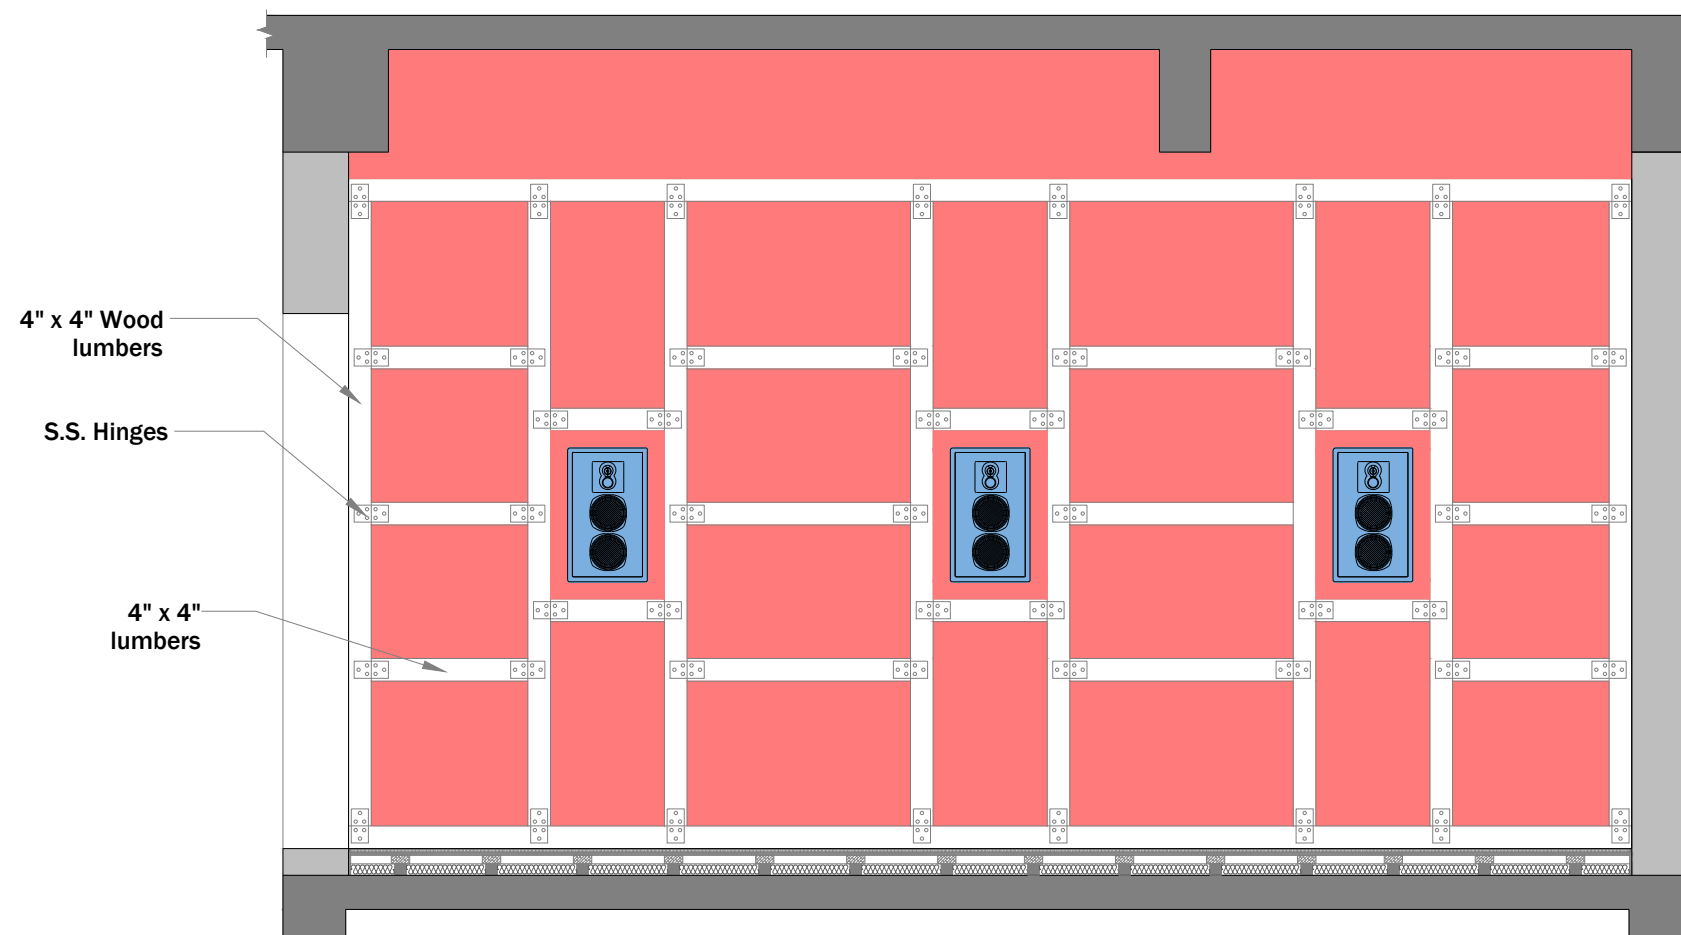

Front Side View

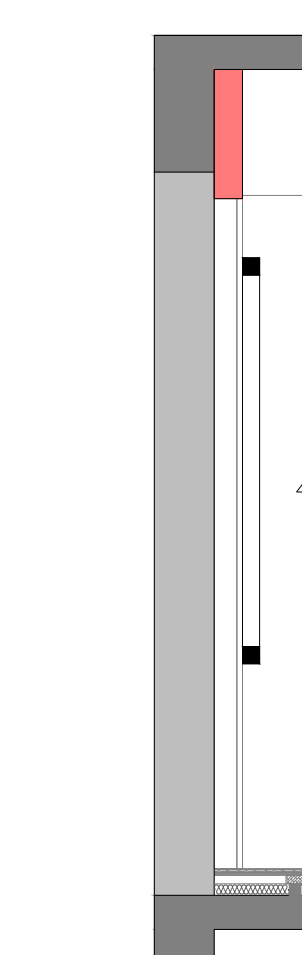

Right Side View

AUDIO VIDEO SYMBOLS		
SYMBOL	NAME	DO=DEVICE OPTIONS
	SPEAKER	LCR-LCR BAR SU-SUBWOOFER ST-STEREO
	VIDEO PROJECTOR	LCD-LIQUID CRYSTAL DISPLAY DLP-DIGITAL LIGHT PROCESSOR SXRD-SILICON X-TEL REF. DISP.
	PROJECTOR SCREEN	F-FIXED M-MOTORISED

COMMUNICATIONS SYMBOLS		
SYMBOL	NAME	DO=DEVICE OPTIONS
	PHONE AND DATA PORT	D-DATA F-FIBRE OPTIC P-PHONE
	INCOMING SERVICES	CTV-CABLE TV P-PHONE S-SATELLITE
	RF REPEATER ACCESS POINT	CR-CELLUAR PR-PHONE WAP-WIRELESSACCESS POINT

FURNISHINGS SYMBOLS		
SYMBOL	NAME	DO=DEVICE OPTIONS
	RACK OR HEAD END	AV-AUDIO/VIDEO C-CONTROL D-DATA SEC-SECURITY
	LIFT/MOUNT	A-ARTICULATED M-MOTORISED UB-UNDER BED

EXAMPLES: SYMBOL + MOUNTING OPTION		
SYMBOL	NAME	MOUNT TYPE
	SPEAKER	CEILING MOUNTED
	SPEAKER	WALL MOUNTED
	SPEAKER	FLOOR MOUNTED
	PRE-WIRE SPEAKER	CEILING MOUNTED PRE-WIRE ONLY NO CUTOUT

CABLING OPTIONS			
	SPKR	2CX2.5 mm ²	SPEAKER CABLE
	COXL	COAXIAL	SUBWOOFER CABLE
	CAT6	CAT6	DATA CABLE
	HDMI	HDMI	VIDEO CABLE

Client : CLINICAL RETREAT

Location : ANAND

Created 13-06-2017
 Modified Not yet
 Printed Not yet

Drawing Name :
 BAFFLE WALL


Drawing Type :
 BAFFLE WALL DETAIL

Drawing Scale : SCALE TO FIT

Designed by Ruchi

Checked by Ankur Bhatt

HC-052/13

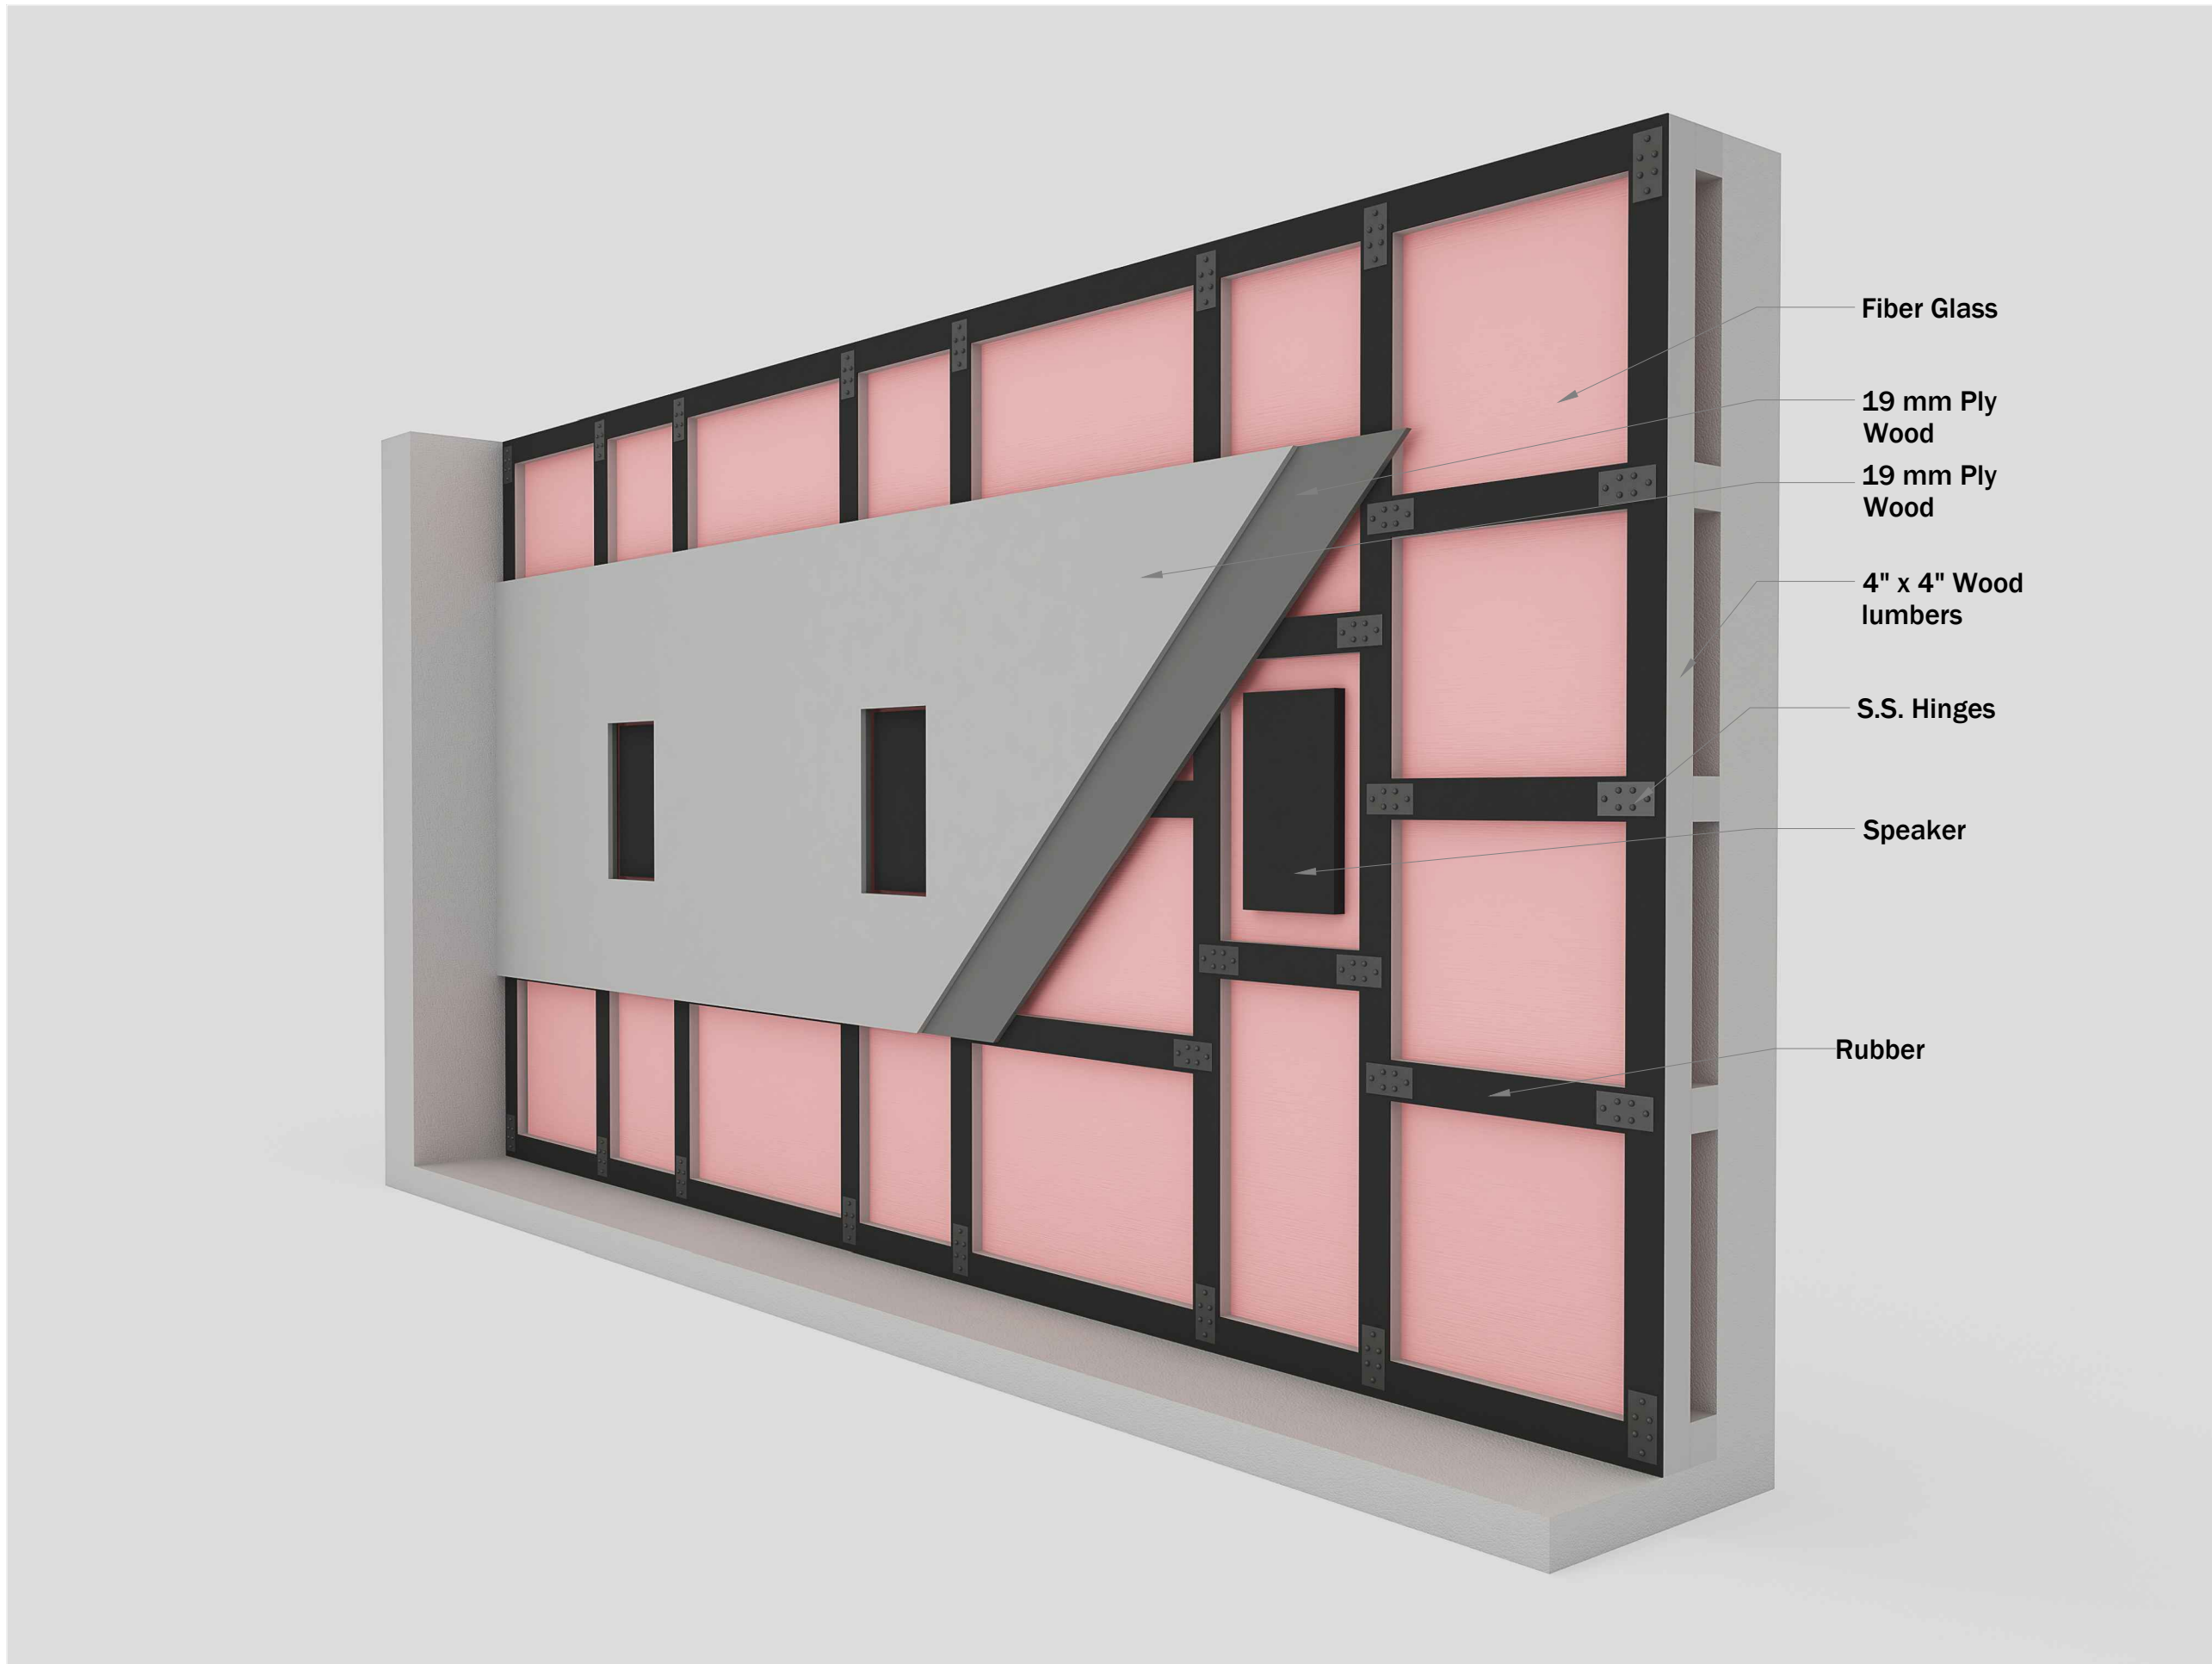

AUDIO VIDEO SYMBOLS		
SYMBOL	NAME	DO=DEVICE OPTIONS
	SPEAKER	LCR-LCR BAR SU-SUBWOOFER ST-STEREO
	VIDEO PROJECTOR	LCD-LIQUID CRYSTAL DISPLAY DLP-DIGITAL LIGHT PROCESSOR SXRD-SILICON X-TEL REF. DISP.
	PROJECTON SCREEN	F-FIXED M-MOTORISED

COMMUNICATIONS SYMBOLS		
SYMBOL	NAME	DO=DEVICE OPTIONS
	PHONE AND DATA PORT	D-DATA F-FIBRE OPTIC P-PHONE
	INCOMING SERVICES	CTV-CABLE TV P-PHONE S-SATELLITE
	RF REPEATER ACCESS POINT	CR-CELLUAR PR-PHONE WAP-WIRELESSACCESS POINT

FURNISHINGS SYMBOLS		
SYMBOL	NAME	DO=DEVICE OPTIONS
	RACK OR HEAD END	AV-AUDIO/VIDEO C-CONTROL D-DATA SEC-SECURITY
	LIFT/MOUNT	A-ARTICULATED M-MOTORISED UB-UNDER BED

EXAMPLES: SYMBOL + MOUNTING OPTION		
SYMBOL	NAME	MOUNT TYPE
	SPEAKER	CEILING MOUNTED
	SPEAKER	WALL MOUNTED
	SPEAKER	FLOOR MOUNTED
	PRE-WIRE SPEAKER	CEILING MOUNTED PRE-WIRE ONLY NO CUTOUT

CABLING OPTIONS			
SYMBOL	NAME	CABLE TYPE	CABLE SIZE
	SPKR	2CX2.5 mm ²	SPEAKER CABLE
	COXL	COAXIAL	SUBWOOFER CABLE
	CAT6	CAT6	DATA CABLE
	HDMI	HDMI	VIDEO CABLE

Client : CLINICAL RETREAT

Location : ANAND

Created 13-06-2017
 Modified Not yet
 Printed Not yet

Drawing Name :
 BAFFLE WALL


Drawing Type :
 3D VISUALIZATION

Drawing Scale : SCALE TO FIT

Designed by Chirantan

Checked by Ankur Bhatt

HC-052/13.1

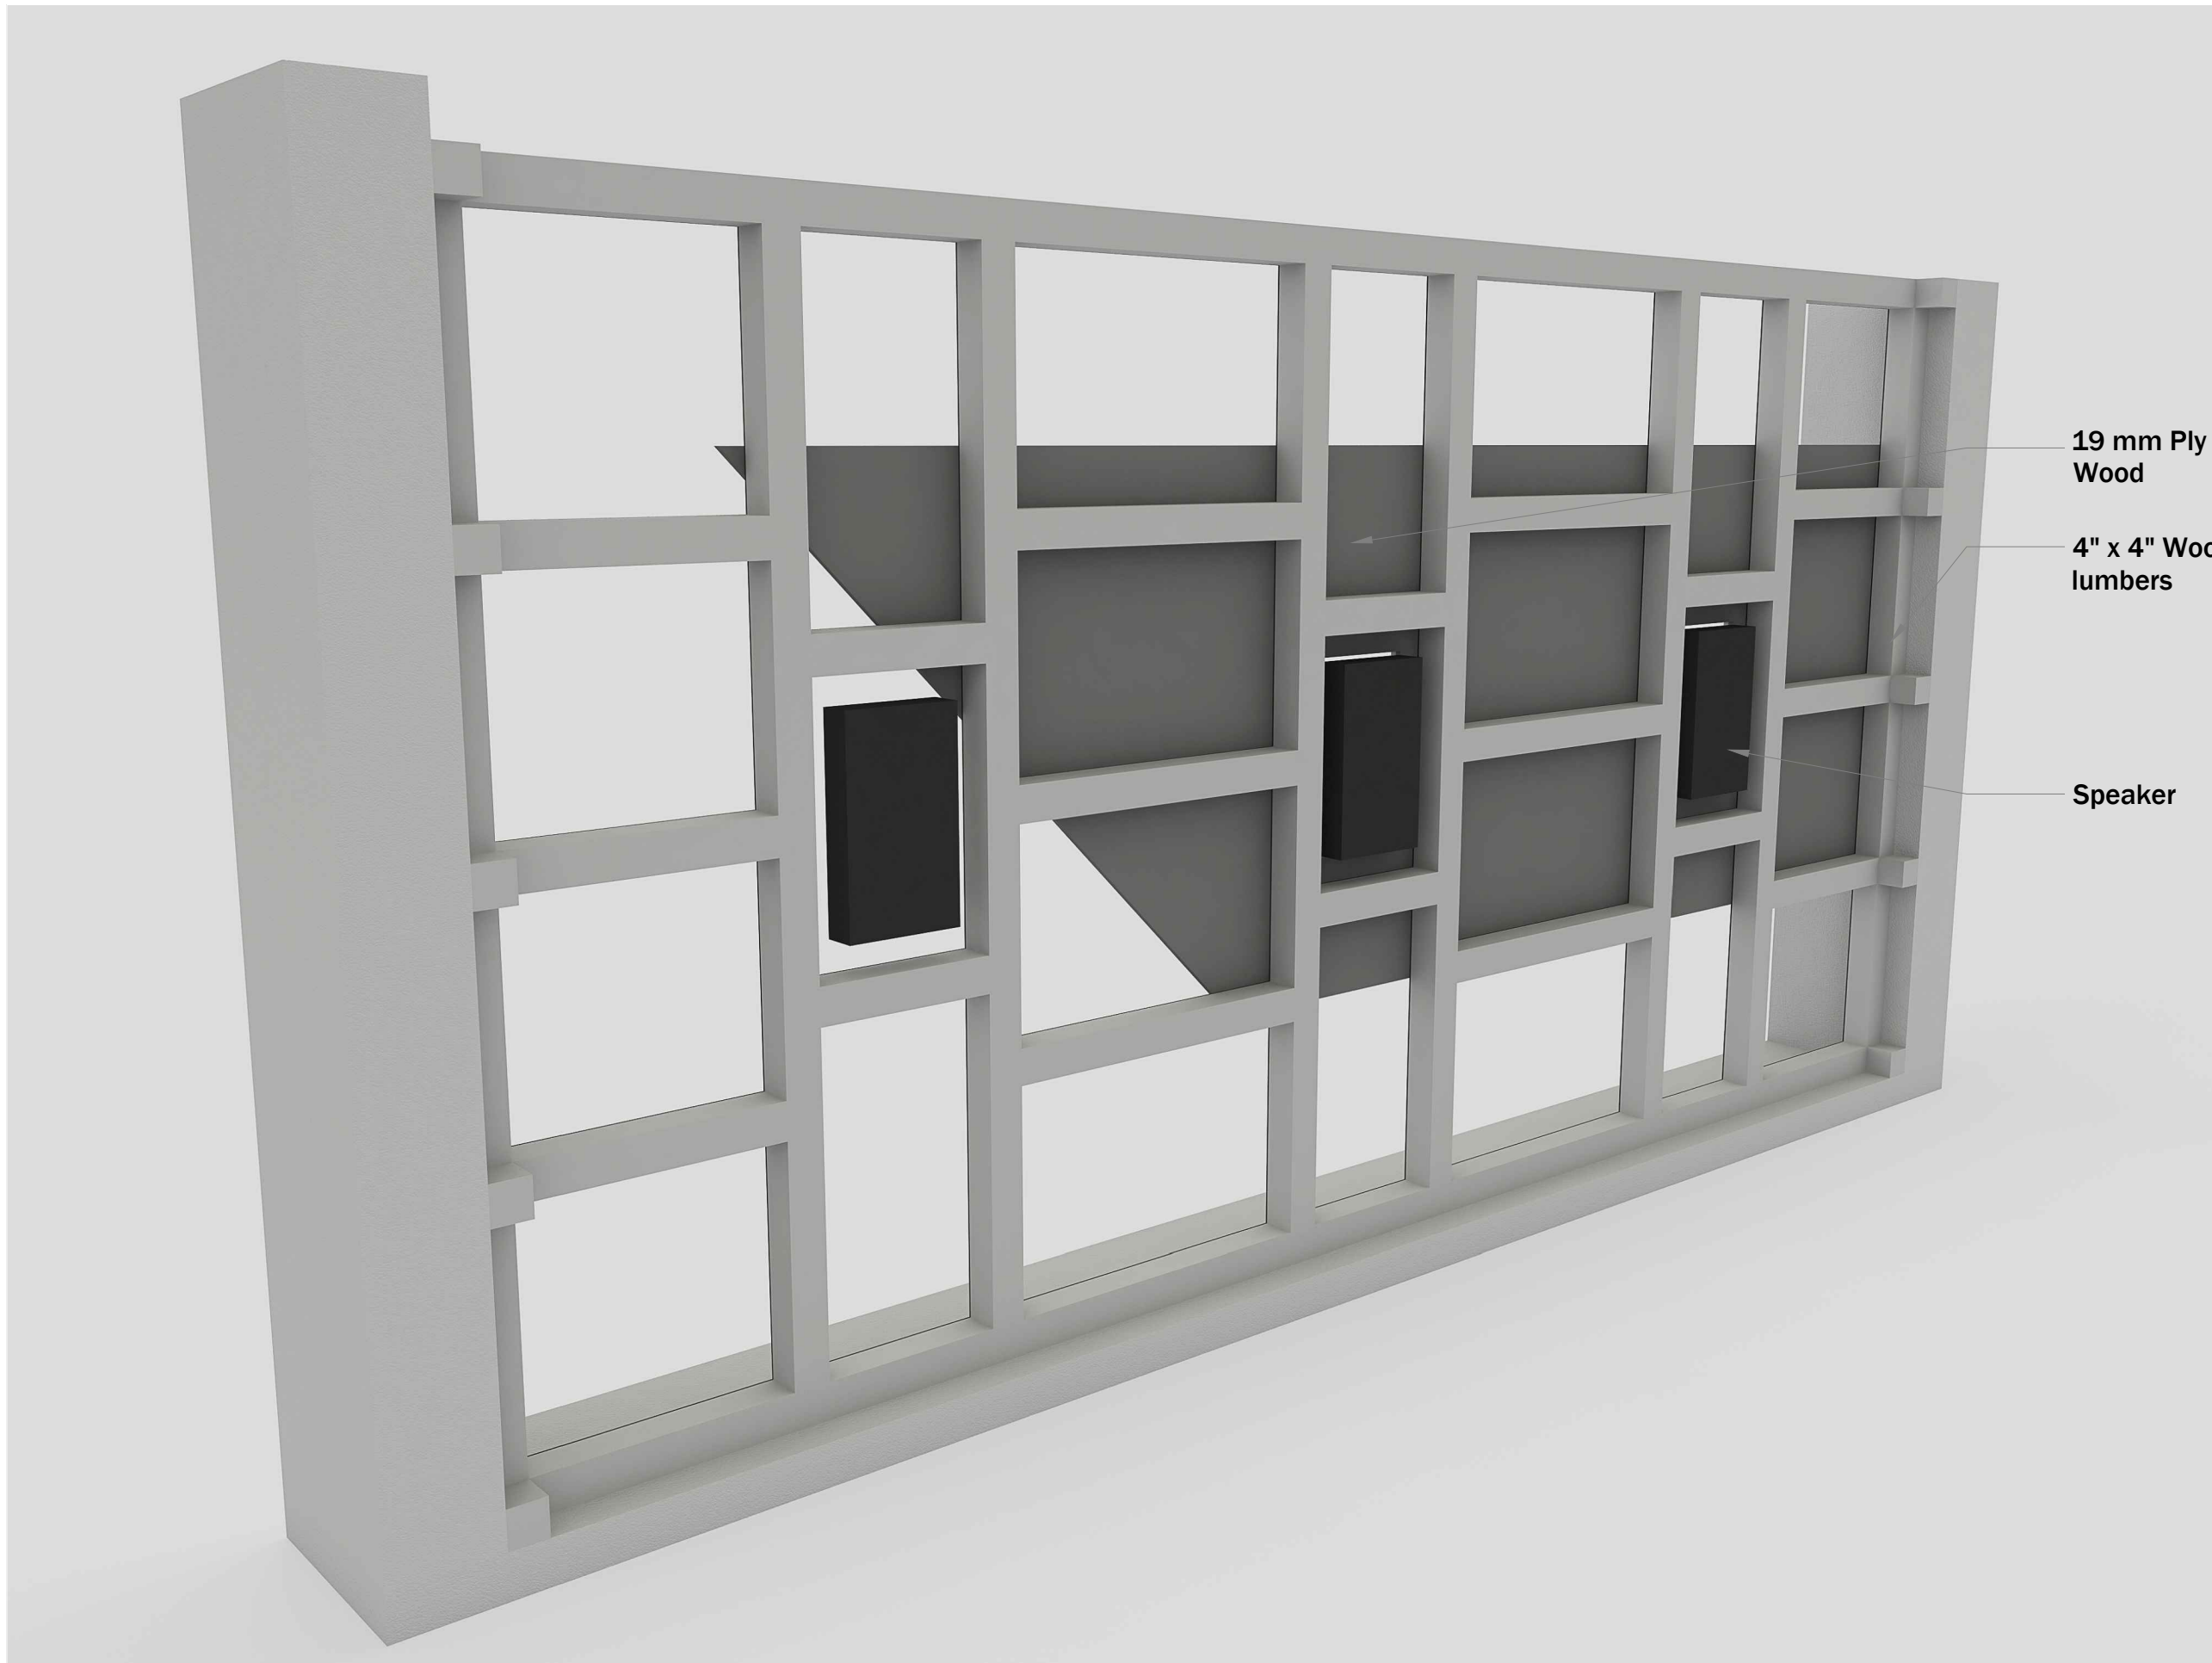

AUDIO VIDEO SYMBOLS		
SYMBOL	NAME	DO=DEVICE OPTIONS
	SPEAKER	LCR-LCR BAR SU-SUBWOOFER ST-STEREO
	VIDEO PROJECTOR	LCD-LIQUID CRYSTAL DISPLAY DLP-DIGITAL LIGHT PROCESSOR SXRD-SILICON X-TEL REF. DISP.
	PROJECTON SCREEN	F-FIXED M-MOTORISED

COMMUNICATIONS SYMBOLS		
SYMBOL	NAME	DO=DEVICE OPTIONS
	PHONE AND DATA PORT	D-DATA F-FIBRE OPTIC P-PHONE
	INCOMING SERVICES	CTV-CABLE TV P-PHONE S-SATELLITE
	RF REPEATER ACCESS POINT	CR-CELLUAR PR-PHONE WAP-WIRELESSACCESS POINT

FURNISHINGS SYMBOLS		
SYMBOL	NAME	DO=DEVICE OPTIONS
	RACK OR HEAD END	AV-AUDIO/VIDEO C-CONTROL D-DATA SEC-SECURITY
	LIFT/MOUNT	A-ARTICULATED M-MOTORISED UB-UNDER BED

EXAMPLES: SYMBOL + MOUNTING OPTION		
SYMBOL	NAME	MOUNT TYPE
	SPEAKER	CEILING MOUNTED
	SPEAKER	WALL MOUNTED
	SPEAKER	FLOOR MOUNTED
	PRE-WIRE SPEAKER	CEILING MOUNTED PRE-WIRE ONLY NO CUTOUT

CABLING OPTIONS			
	SPKR	2CX2.5 mm ²	SPEAKER CABLE
	COXL	COAXIAL	SUBWOOFER CABLE
	CAT6	CAT6	DATA CABLE
	HDMI	HDMI	VIDEO CABLE

Client : CLINICAL RETREAT

Location : ANAND

Created 13-06-2017
 Modified Not yet
 Printed Not yet

Drawing Name :
 BAFFLE WALL


Drawing Type :
 3D VISUALIZATION

Drawing Scale : SCALE TO FIT

Designed by Chirantan

Checked by Ankur Bhatt

HC-052/13.2

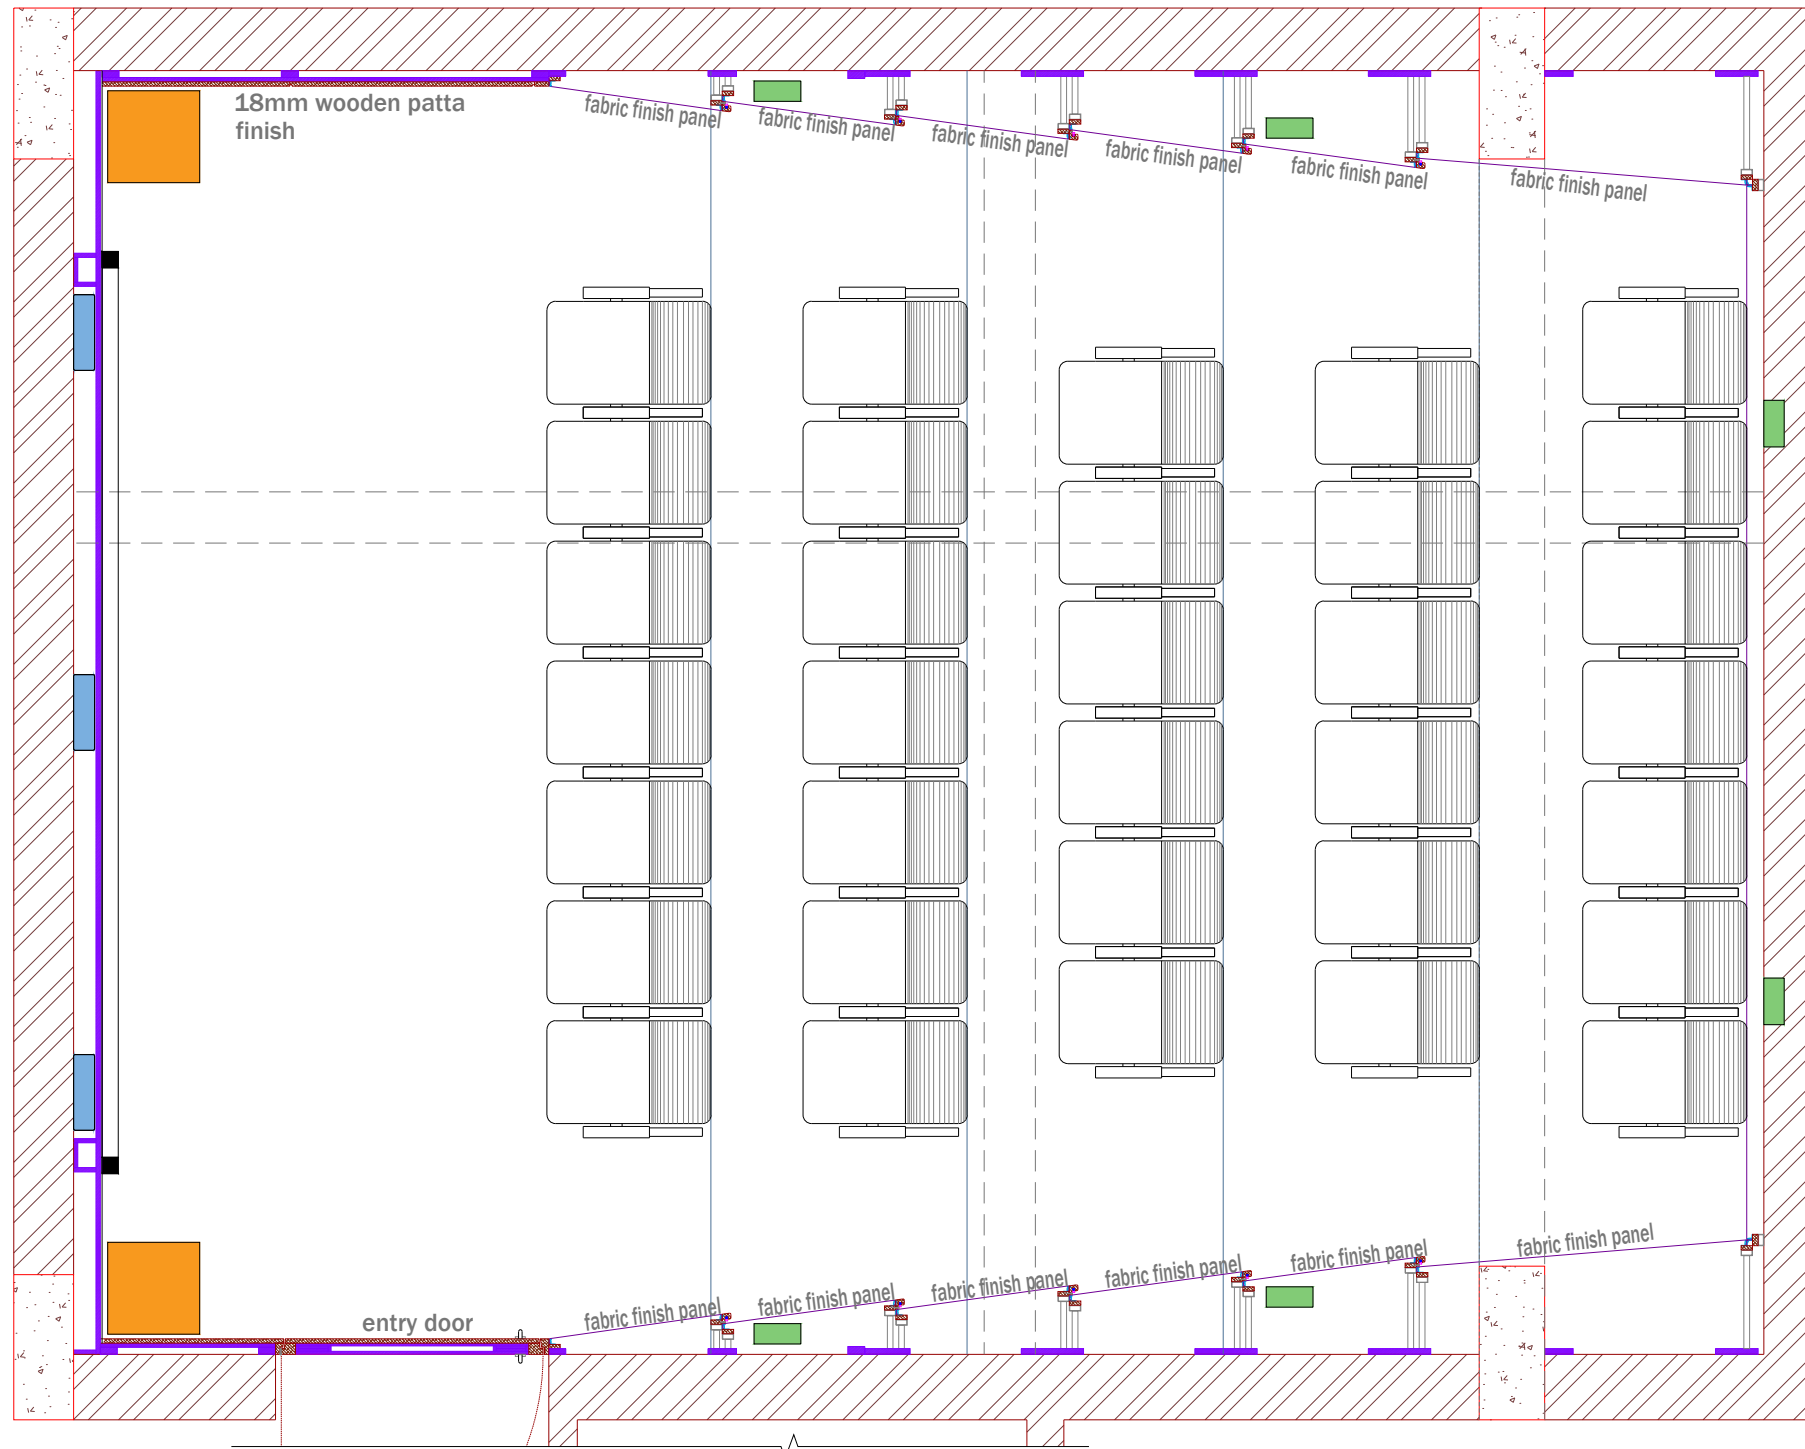

AUDIO VIDEO SYMBOLS			
SYMBOL	NAME	DO=DEVICE OPTIONS	
	SPEAKER	LCR-LCR BAR SU-SUBWOOFER ST-STEREO	
	VIDEO PROJECTOR	LCD-LIQUID CRYSTAL DISPLAY DLP-DIGITAL LIGHT PROCESSOR SXRD-SILICON X-TEL REF. DISP.	
	PROJECTOR SCREEN	F-FIXED M-MOTORISED	
COMMUNICATIONS SYMBOLS			
SYMBOL	NAME	DO=DEVICE OPTIONS	
	PHONE AND DATA PORT	D-DATA F-FIBRE OPTIC P-PHONE	
	INCOMING SERVICES	CTV-CABLE TV P-PHONE S-SATELLITE	
	RF REPEATER ACCESS POINT	CR-CELLULAR PR-PHONE WAP-WIRELESSACCESS POINT	
FURNISHINGS SYMBOLS			
SYMBOL	NAME	DO=DEVICE OPTIONS	
	RACK OR HEAD END	AV-AUDIO/VIDEO C-CONTROL D-DATA SEC-SECURITY	
	LIFT/MOUNT	A-ARTICULATED M-MOTORISED UB-UNDER BED	
EXAMPLES: SYMBOL + MOUNTING OPTION			
SYMBOL	NAME	MOUNT TYPE	
	SPEAKER	CEILING MOUNTED	
	SPEAKER	WALL MOUNTED	
	SPEAKER	FLOOR MOUNTED	
	PRE-WIRE SPEAKER	CEILING MOUNTED PRE-WIRE ONLY NO CUTOUT	
CABLING OPTIONS			
	SPKR	2CX2.5 mm ²	SPEAKER CABLE
	COXL	COAXIAL	SUBWOOFER CABLE
	CAT6	CAT6	DATA CABLE
	HDMI	HDMI	VIDEO CABLE

Client : CLINICAL RETREAT

Location : ANAND

Created 13-06-2017
 Modified Not yet
 Printed Not yet

Drawing Name :
 MATERIAL DETAILS


Drawing Type :
 FLOOR PLAN

Drawing Scale : SCALE TO FIT






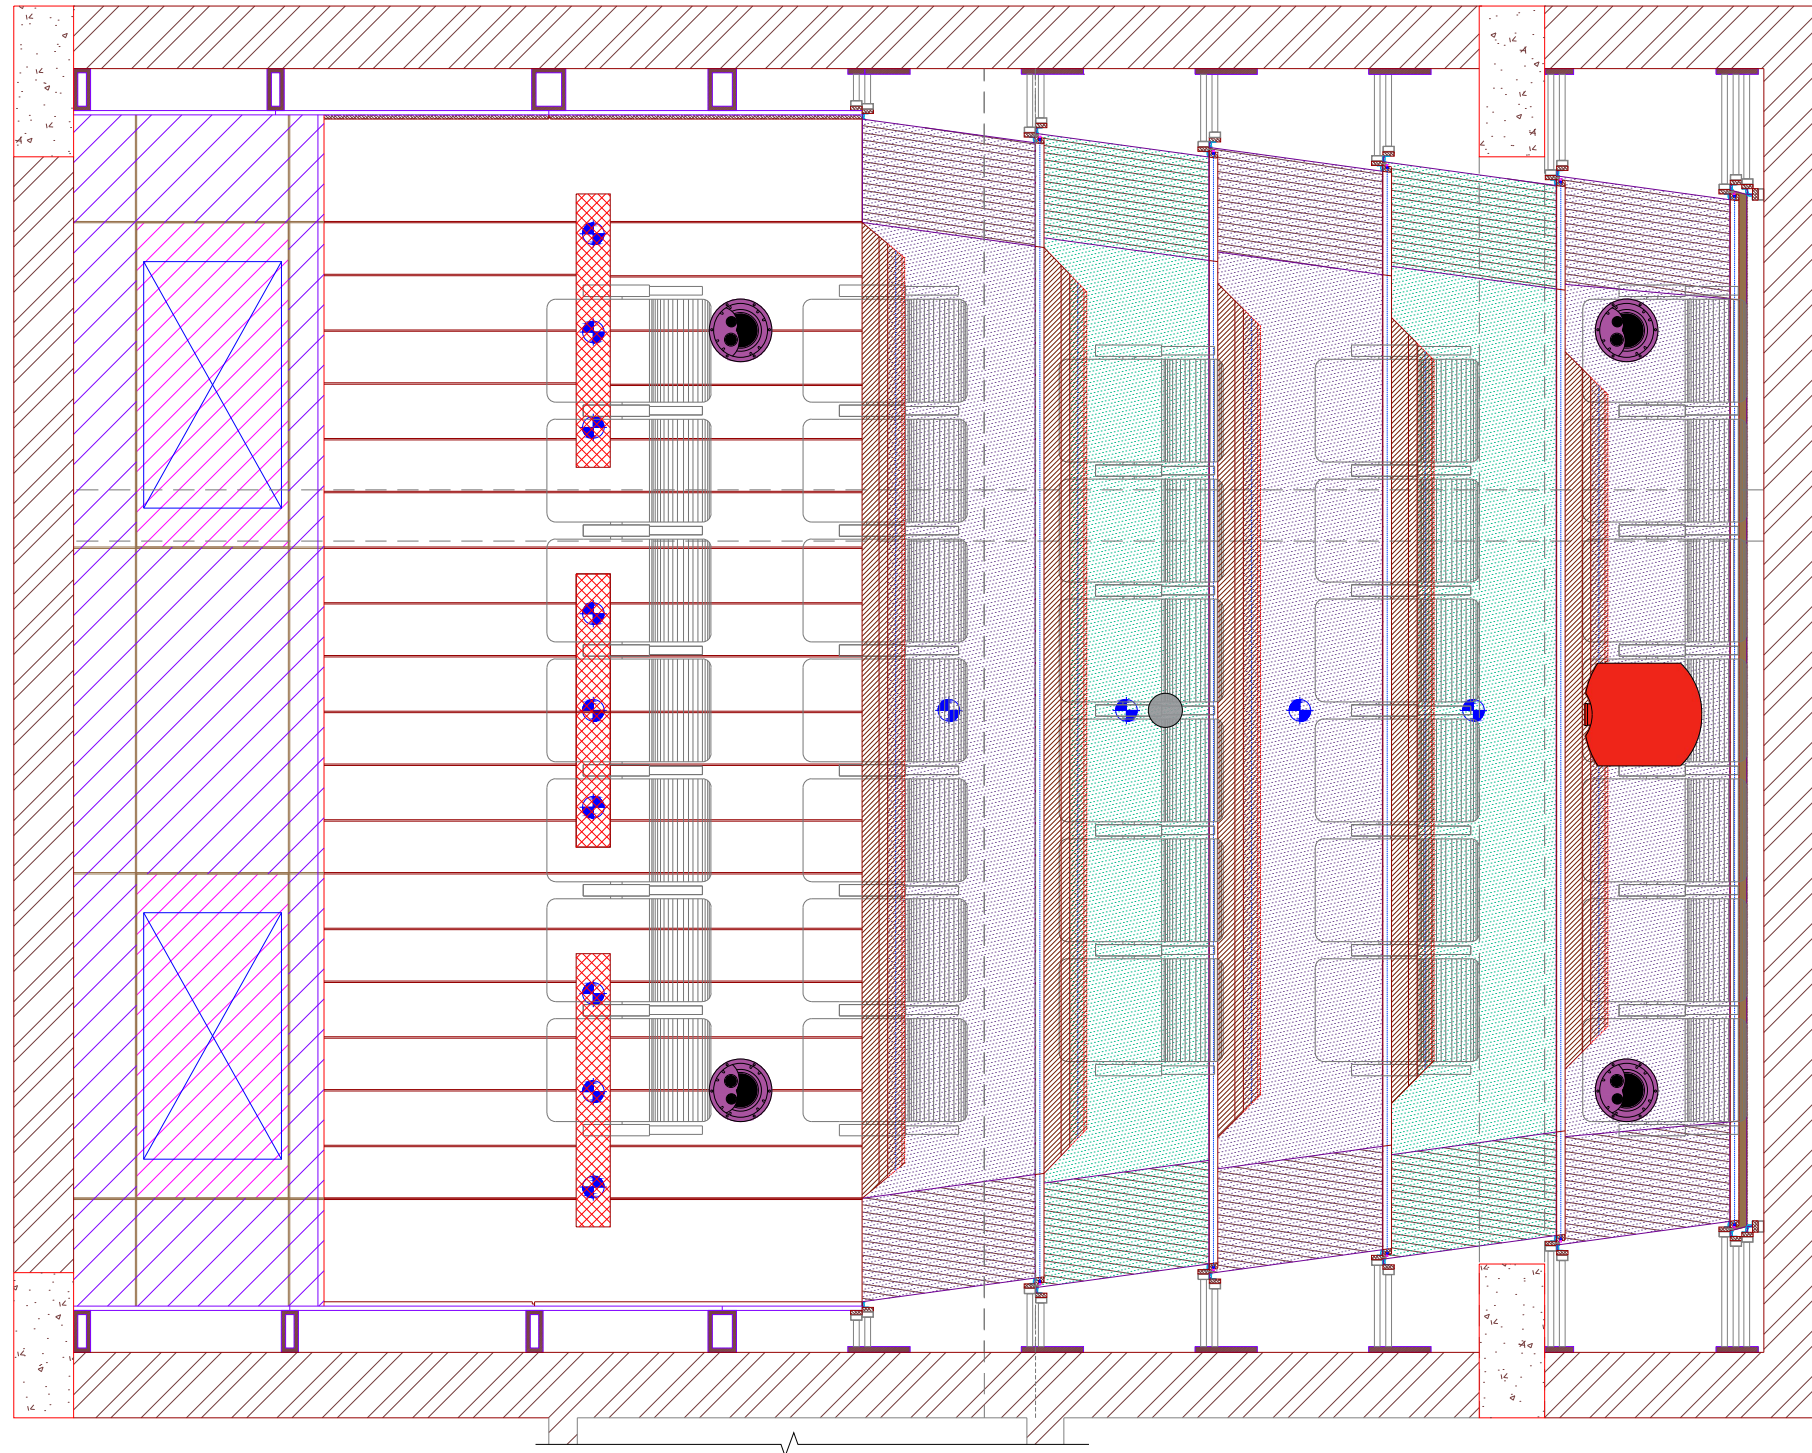


Designed by Ruchi

 


Checked by Ankur Bhatt


 

HC-052/14









NOTE:-





-  FABRIC FINISH FALSE CEILING @ SLAB BOTTOM +1'-9 $\frac{1}{2}$ " TO 1'-9 $\frac{3}{4}$ "
-  FABRIC FINISH FALSE CEILING @ SLAB BOTTOM +1'-9 $\frac{1}{2}$ " TO 1'-11 $\frac{1}{4}$ "
-  FABRIC FINISH FALSE CEILING @ SLAB BOTTOM +1'-9 $\frac{1}{2}$ " TO 1'-11 $\frac{1}{4}$ "
-  18MM PLY+8MM MDF PAINT FINISH FALSE CEILING @ SLAB BOTTOM +2'-5"
-  18MM PLY+8MM MDF PAINT FINISH FALSE SHUTTER @ SLAB BOTTOM +2'-5"
-  18MM THK. WOODEN PATTHA FINISH FALSE CEILING @ SLAB BOTTOM +1'-9 $\frac{1}{2}$ "
-  18MM PLY + 8 MM MDF PAINT FINISH FALSE CEILING @ SLAB BOTTOM +3'-2 $\frac{1}{4}$ "
-  12MM WOOD FINISH FALSE CEILING @ SLAB BOTTOM +1'-6 $\frac{1}{2}$ "

AUDIO VIDEO SYMBOLS		
SYMBOL	NAME	DO=DEVICE OPTIONS
	SPEAKER	LCR-LCR BAR SU-SUBWOOFER ST-STEREO
	VIDEO PROJECTOR	LCD-LIQUID CRYSTAL DISPLAY DLP-DIGITAL LIGHT PROCESSOR SXRD-SILICON X-TEL REF. DISP.
	PROJECTOR SCREEN	F-FIXED M-MOTORISED

COMMUNICATIONS SYMBOLS		
SYMBOL	NAME	DO=DEVICE OPTIONS
	PHONE AND DATA PORT	D-DATA F-FIBRE OPTIC P-PHONE
	INCOMING SERVICES	CTV-CABLE TV P-PHONE S-SATELLITE
	RF REPEATER ACCESS POINT	CR-CELLUAR PR-PHONE WAP-WIRELESSACCESS POINT

FURNISHINGS SYMBOLS		
SYMBOL	NAME	DO=DEVICE OPTIONS
	RACK OR HEAD END	AV-AUDIO/VIDEO C-CONTROL D-DATA SEC-SECURITY
	LIFT/MOUNT	A-ARTICULATED M-MOTORISED UB-UNDER BED

EXAMPLES: SYMBOL + MOUNTING OPTION		
SYMBOL	NAME	MOUNT TYPE
	SPEAKER	CEILING MOUNTED
	SPEAKER	WALL MOUNTED
	SPEAKER	FLOOR MOUNTED
	PRE-WIRE SPEAKER	CEILING MOUNTED PRE-WIRE ONLY NO CUTOUT

CABLING OPTIONS			
SYMBOL	NAME	SIZE	TYPE
	SPKR	2CX2.5 mm ²	SPEAKER CABLE
	COXL	COAXIAL	SUBWOOFER CABLE
	CAT6	CAT6	DATA CABLE
	HDMI	HDMI	VIDEO CABLE

Client : CLINICAL RETREAT

Location : ANAND

Created 13-06-2017
 Modified Not yet
 Printed Not yet

Drawing Name :
 MATERIAL DETAILS


Drawing Type :
 CEILING PLAN

Drawing Scale : SCALE TO FIT

Designed by Ruchi

Checked by Ankur Bhatt

HC-052/14.1

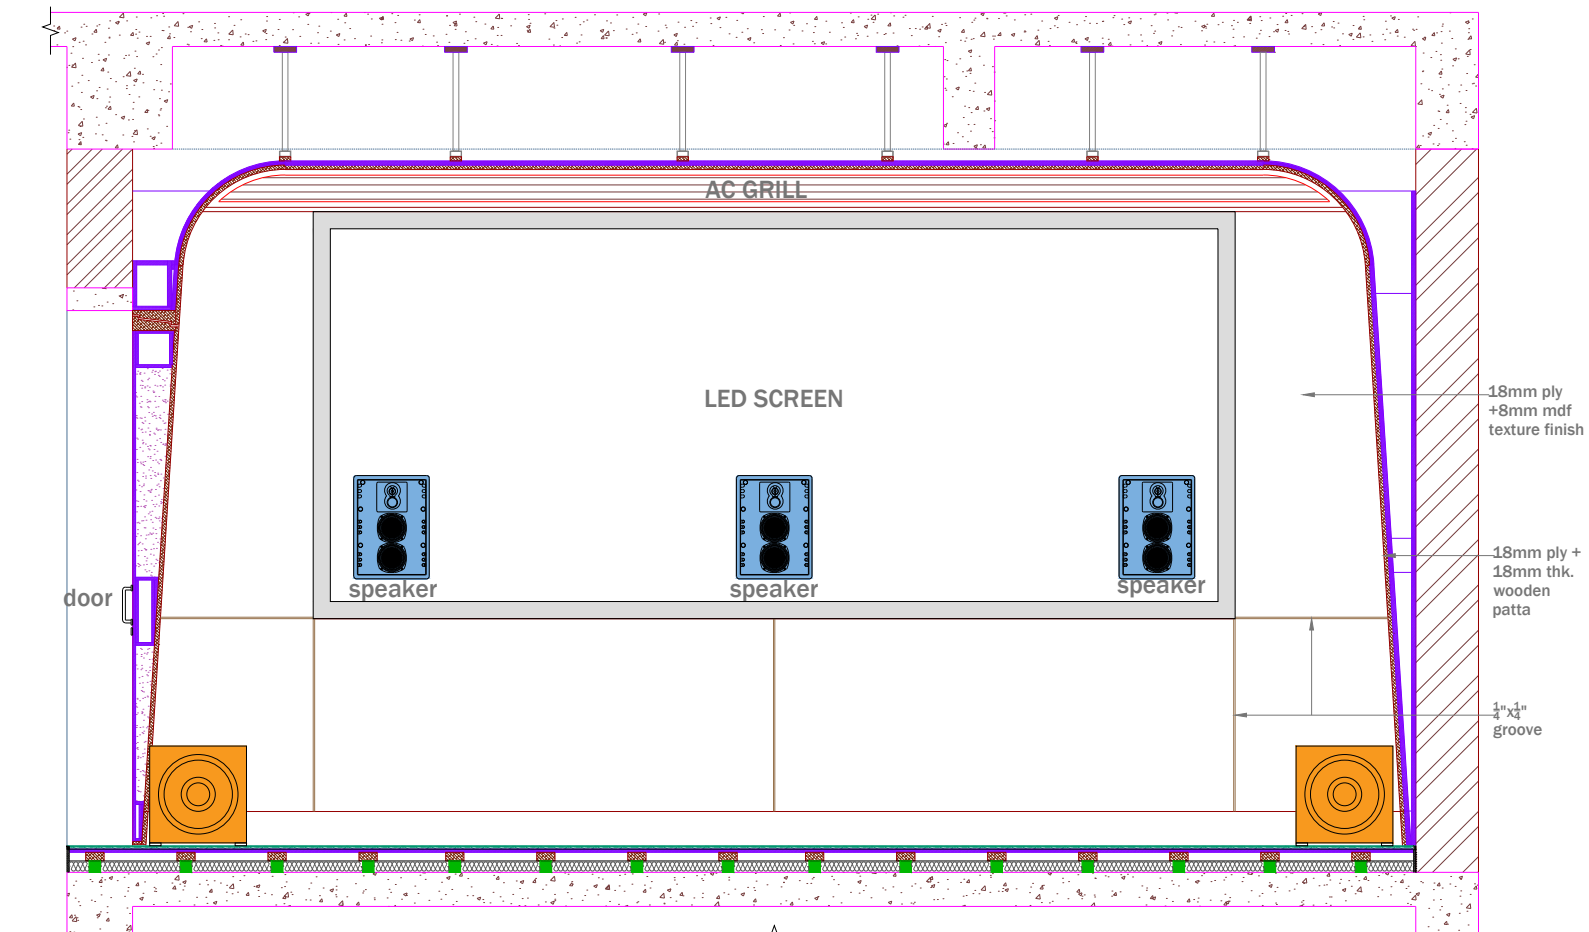

Front Side View

AUDIO VIDEO SYMBOLS		
SYMBOL	NAME	DO=DEVICE OPTIONS
	SPEAKER	LCR-LCR BAR SU-SUBWOOFER ST-STEREO
	VIDEO PROJECTOR	LCD-LIQUID CRYSTAL DISPLAY DLP-DIGITAL LIGHT PROCESSOR SXRD-SILICON X-TEL REF. DISP.
	PROJECTON SCREEN	F-FIXED M-MOTORISED

COMMUNICATIONS SYMBOLS		
SYMBOL	NAME	DO=DEVICE OPTIONS
	PHONE AND DATA PORT	D-DATA F-FIBRE OPTIC P-PHONE
	INCOMING SERVICES	CTV-CABLE TV P-PHONE S-SATELLITE
	RF REPEATER ACCESS POINT	CR-CELLUAR PR-PHONE WAP-WIRELESSACCESS POINT

FURNISHINGS SYMBOLS		
SYMBOL	NAME	DO=DEVICE OPTIONS
	RACK OR HEAD END	AV-AUDIO/VIDEO C-CONTROL D-DATA SEC-SECURITY
	LIFT/MOUNT	A-ARTICULATED M-MOTORISED UB-UNDER BED

EXAMPLES: SYMBOL + MOUNTING OPTION		
SYMBOL	NAME	MOUNT TYPE
	SPEAKER	CEILING MOUNTED
	SPEAKER	WALL MOUNTED
	SPEAKER	FLOOR MOUNTED
	PRE-WIRE SPEAKER	CEILING MOUNTED PRE-WIRE ONLY NO CUTOUT

CABLING OPTIONS			
SYMBOL	NAME	TYPE	DESCRIPTION
	SPKR	2CX2.5 mm ²	SPEAKER CABLE
	COXL	COAXIAL	SUBWOOFER CABLE
	CAT6	CAT6	DATA CABLE
	HDMI	HDMI	VIDEO CABLE

Client : CLINICAL RETREAT

Location : ANAND

Created 13-06-2017
 Modified Not yet
 Printed Not yet

Drawing Name :
 MATERIAL DETAILS


Drawing Type :
 ELEVATION

Drawing Scale : SCALE TO FIT

Designed by Ruchi

Checked by Ankur Bhatt

HC-052/14.2

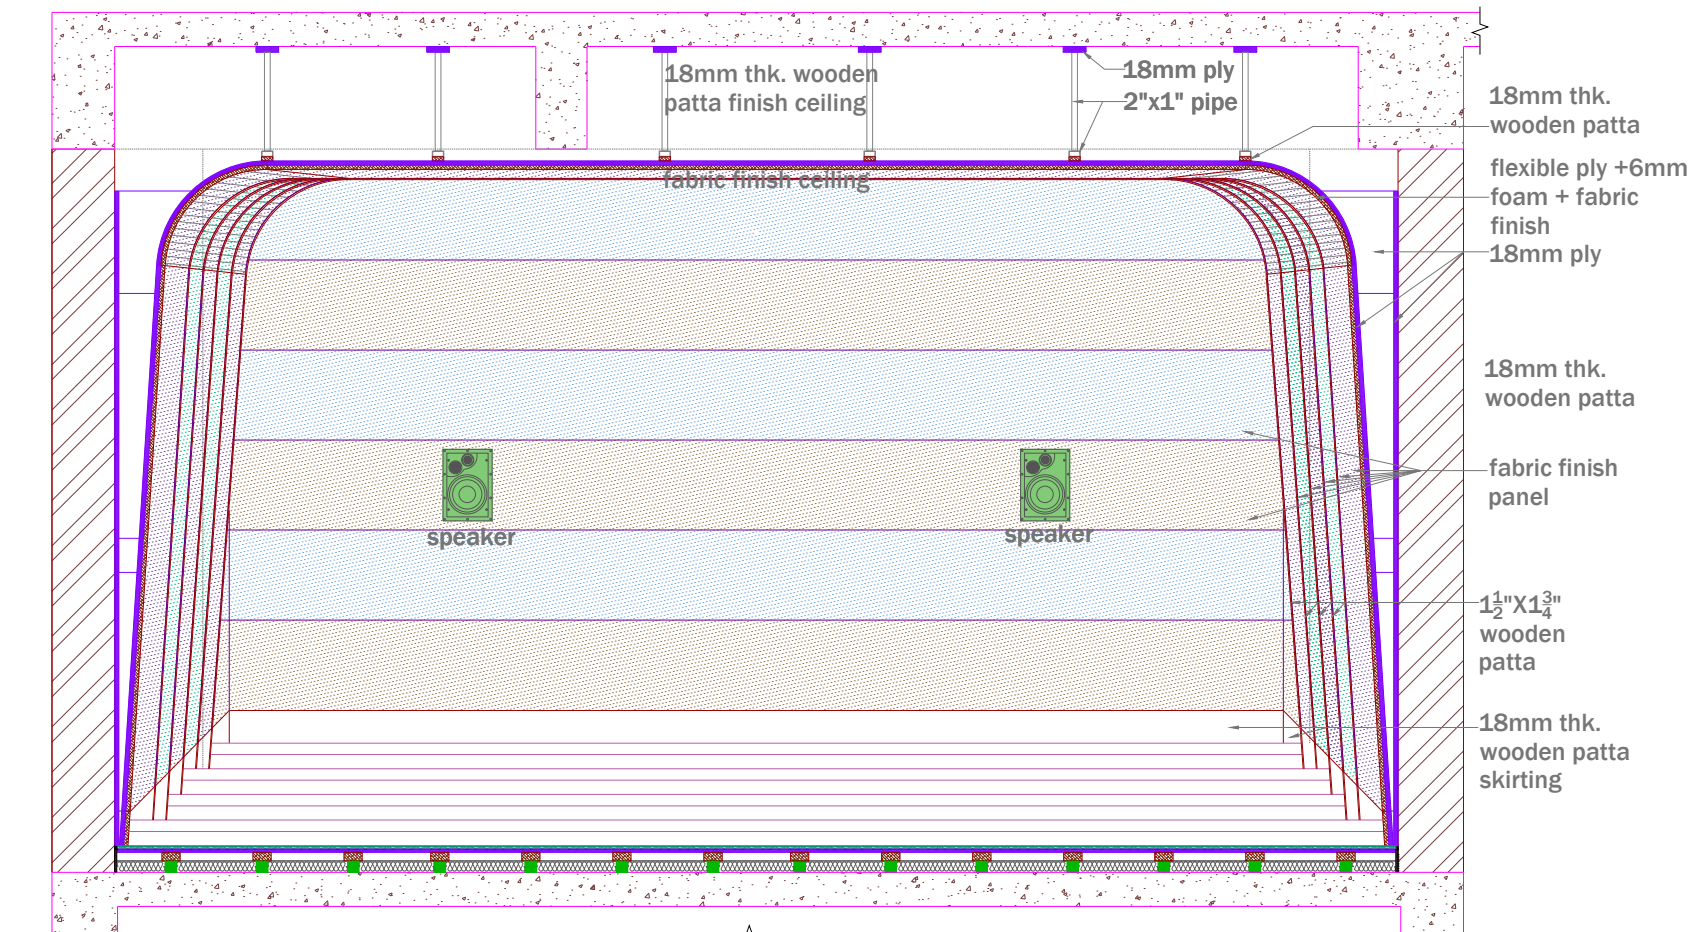

Rear Side View

AUDIO VIDEO SYMBOLS		
SYMBOL	NAME	DO=DEVICE OPTIONS
	SPEAKER	LCR-LCR BAR SU-SUBWOOFER ST-STEREO
	VIDEO PROJECTOR	LCD-LIQUID CRYSTAL DISPLAY DLP-DIGITAL LIGHT PROCESSOR SXRD-SILICON X-TEL REF. DISP.
	PROJECTOR SCREEN	F-FIXED M-MOTORISED

COMMUNICATIONS SYMBOLS		
SYMBOL	NAME	DO=DEVICE OPTIONS
	PHONE AND DATA PORT	D-DATA F-FIBRE OPTIC P-PHONE
	INCOMING SERVICES	CTV-CABLE TV P-PHONE S-SATELLITE
	RF REPEATER ACCESS POINT	CR-CELLUAR PR-PHONE WAP-WIRELESSACCESS POINT

FURNISHINGS SYMBOLS		
SYMBOL	NAME	DO=DEVICE OPTIONS
	RACK OR HEAD END	AV-AUDIO/VIDEO C-CONTROL D-DATA SEC-SECURITY
	LIFT/MOUNT	A-ARTICULATED M-MOTORISED UB-UNDER BED

EXAMPLES: SYMBOL + MOUNTING OPTION		
SYMBOL	NAME	MOUNT TYPE
	SPEAKER	CEILING MOUNTED
	SPEAKER	WALL MOUNTED
	SPEAKER	FLOOR MOUNTED
	PRE-WIRE SPEAKER	CEILING MOUNTED PRE-WIRE ONLY NO CUTOUT

CABLING OPTIONS			
	SPKR	2CX2.5 mm ²	SPEAKER CABLE
	COXL	COAXIAL	SUBWOOFER CABLE
	CAT6	CAT6	DATA CABLE
	HDMI	HDMI	VIDEO CABLE

Client : CLINICAL RETREAT

Location : ANAND

Created 13-06-2017
 Modified Not yet
 Printed Not yet

Drawing Name :
 MATERIAL DETAILS

Drawing Type :
 ELEVATION

Drawing Scale : SCALE TO FIT

Designed by Ruchi

Checked by Ankur Bhatt

HC-052/14.3


AUDIO VIDEO SYMBOLS		
SYMBOL	NAME	DO=DEVICE OPTIONS
	SPEAKER	LCR-LCR BAR SU-SUBWOOFER ST-STEREO
	VIDEO PROJECTOR	LCD-LIQUID CRYSTAL DISPLAY DLP-DIGITAL LIGHT PROCESSOR SXRD-SILICON X-TEL REF. DISP.
	PROJECTOR SCREEN	F-FIXED M-MOTORISED

COMMUNICATIONS SYMBOLS		
SYMBOL	NAME	DO=DEVICE OPTIONS
	PHONE AND DATA PORT	D-DATA F-FIBRE OPTIC P-PHONE
	INCOMING SERVICES	CTV-CABLE TV P-PHONE S-SATELLITE
	RF REPEATER ACCESS POINT	CR-CELLUAR PR-PHONE WAP-WIRELESSACCESS POINT

FURNISHINGS SYMBOLS		
SYMBOL	NAME	DO=DEVICE OPTIONS
	RACK OR HEAD END	AV-AUDIO/VIDEO C-CONTROL D-DATA SEC-SECURITY
	LIFT/MOUNT	A-ARTICULATED M-MOTORISED UB-UNDER BED

EXAMPLES: SYMBOL + MOUNTING OPTION		
SYMBOL	NAME	MOUNT TYPE
	SPEAKER	CEILING MOUNTED
	SPEAKER	WALL MOUNTED
	SPEAKER	FLOOR MOUNTED
	PRE-WIRE SPEAKER	CEILING MOUNTED PRE-WIRE ONLY NO CUTOUT

CABLING OPTIONS			
SYMBOL	NAME	TYPE	DESCRIPTION
	SPKR	2CX2.5 mm²	SPEAKER CABLE
	COXL	COAXIAL	SUBWOOFER CABLE
	CAT6	CAT6	DATA CABLE
	HDMI	HDMI	VIDEO CABLE

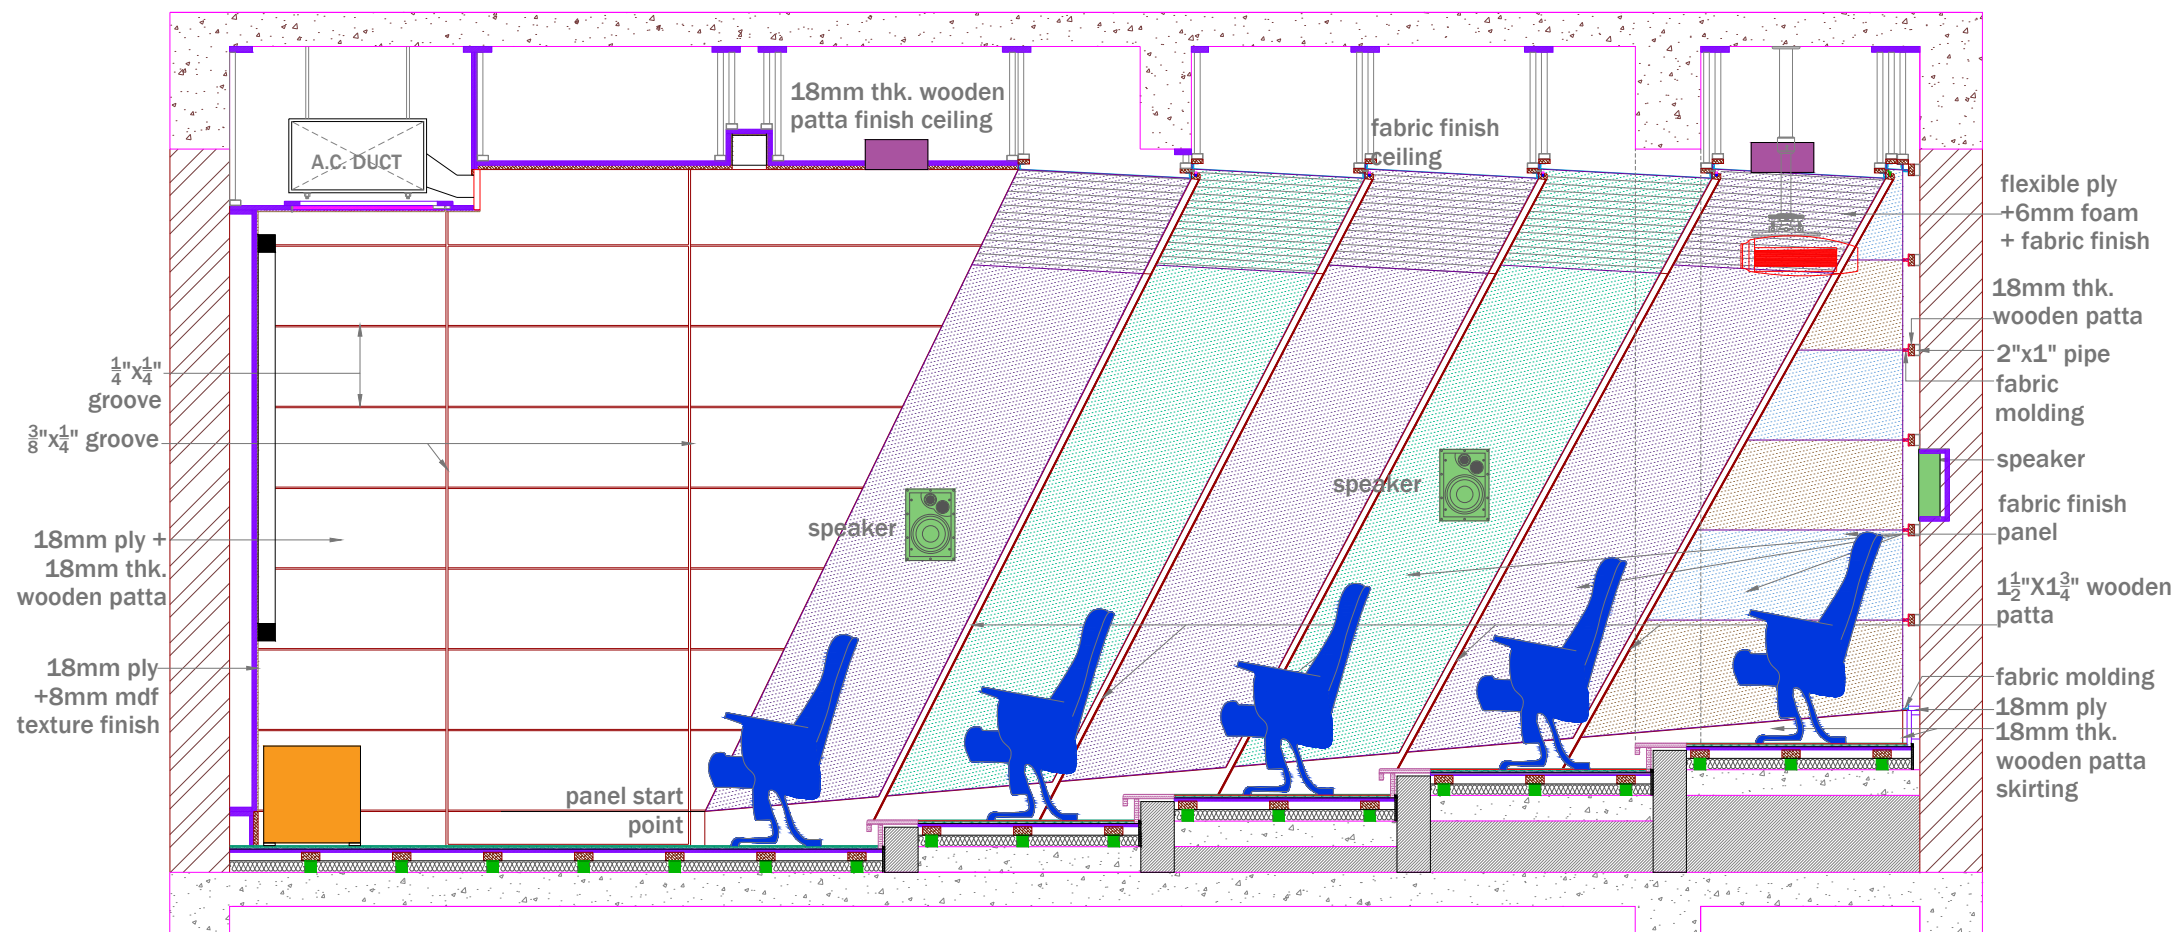

Right Side View

Client : CLINICAL RETREAT

Location : ANAND

Created 13-06-2017
 Modified Not yet
 Printed Not yet

Drawing Name :
 MATERIAL DETAILS


Drawing Type :
 ELEVATION

Drawing Scale : SCALE TO FIT

Designed by Ruchi

Checked by Ankur Bhatt

HC-052/14.4

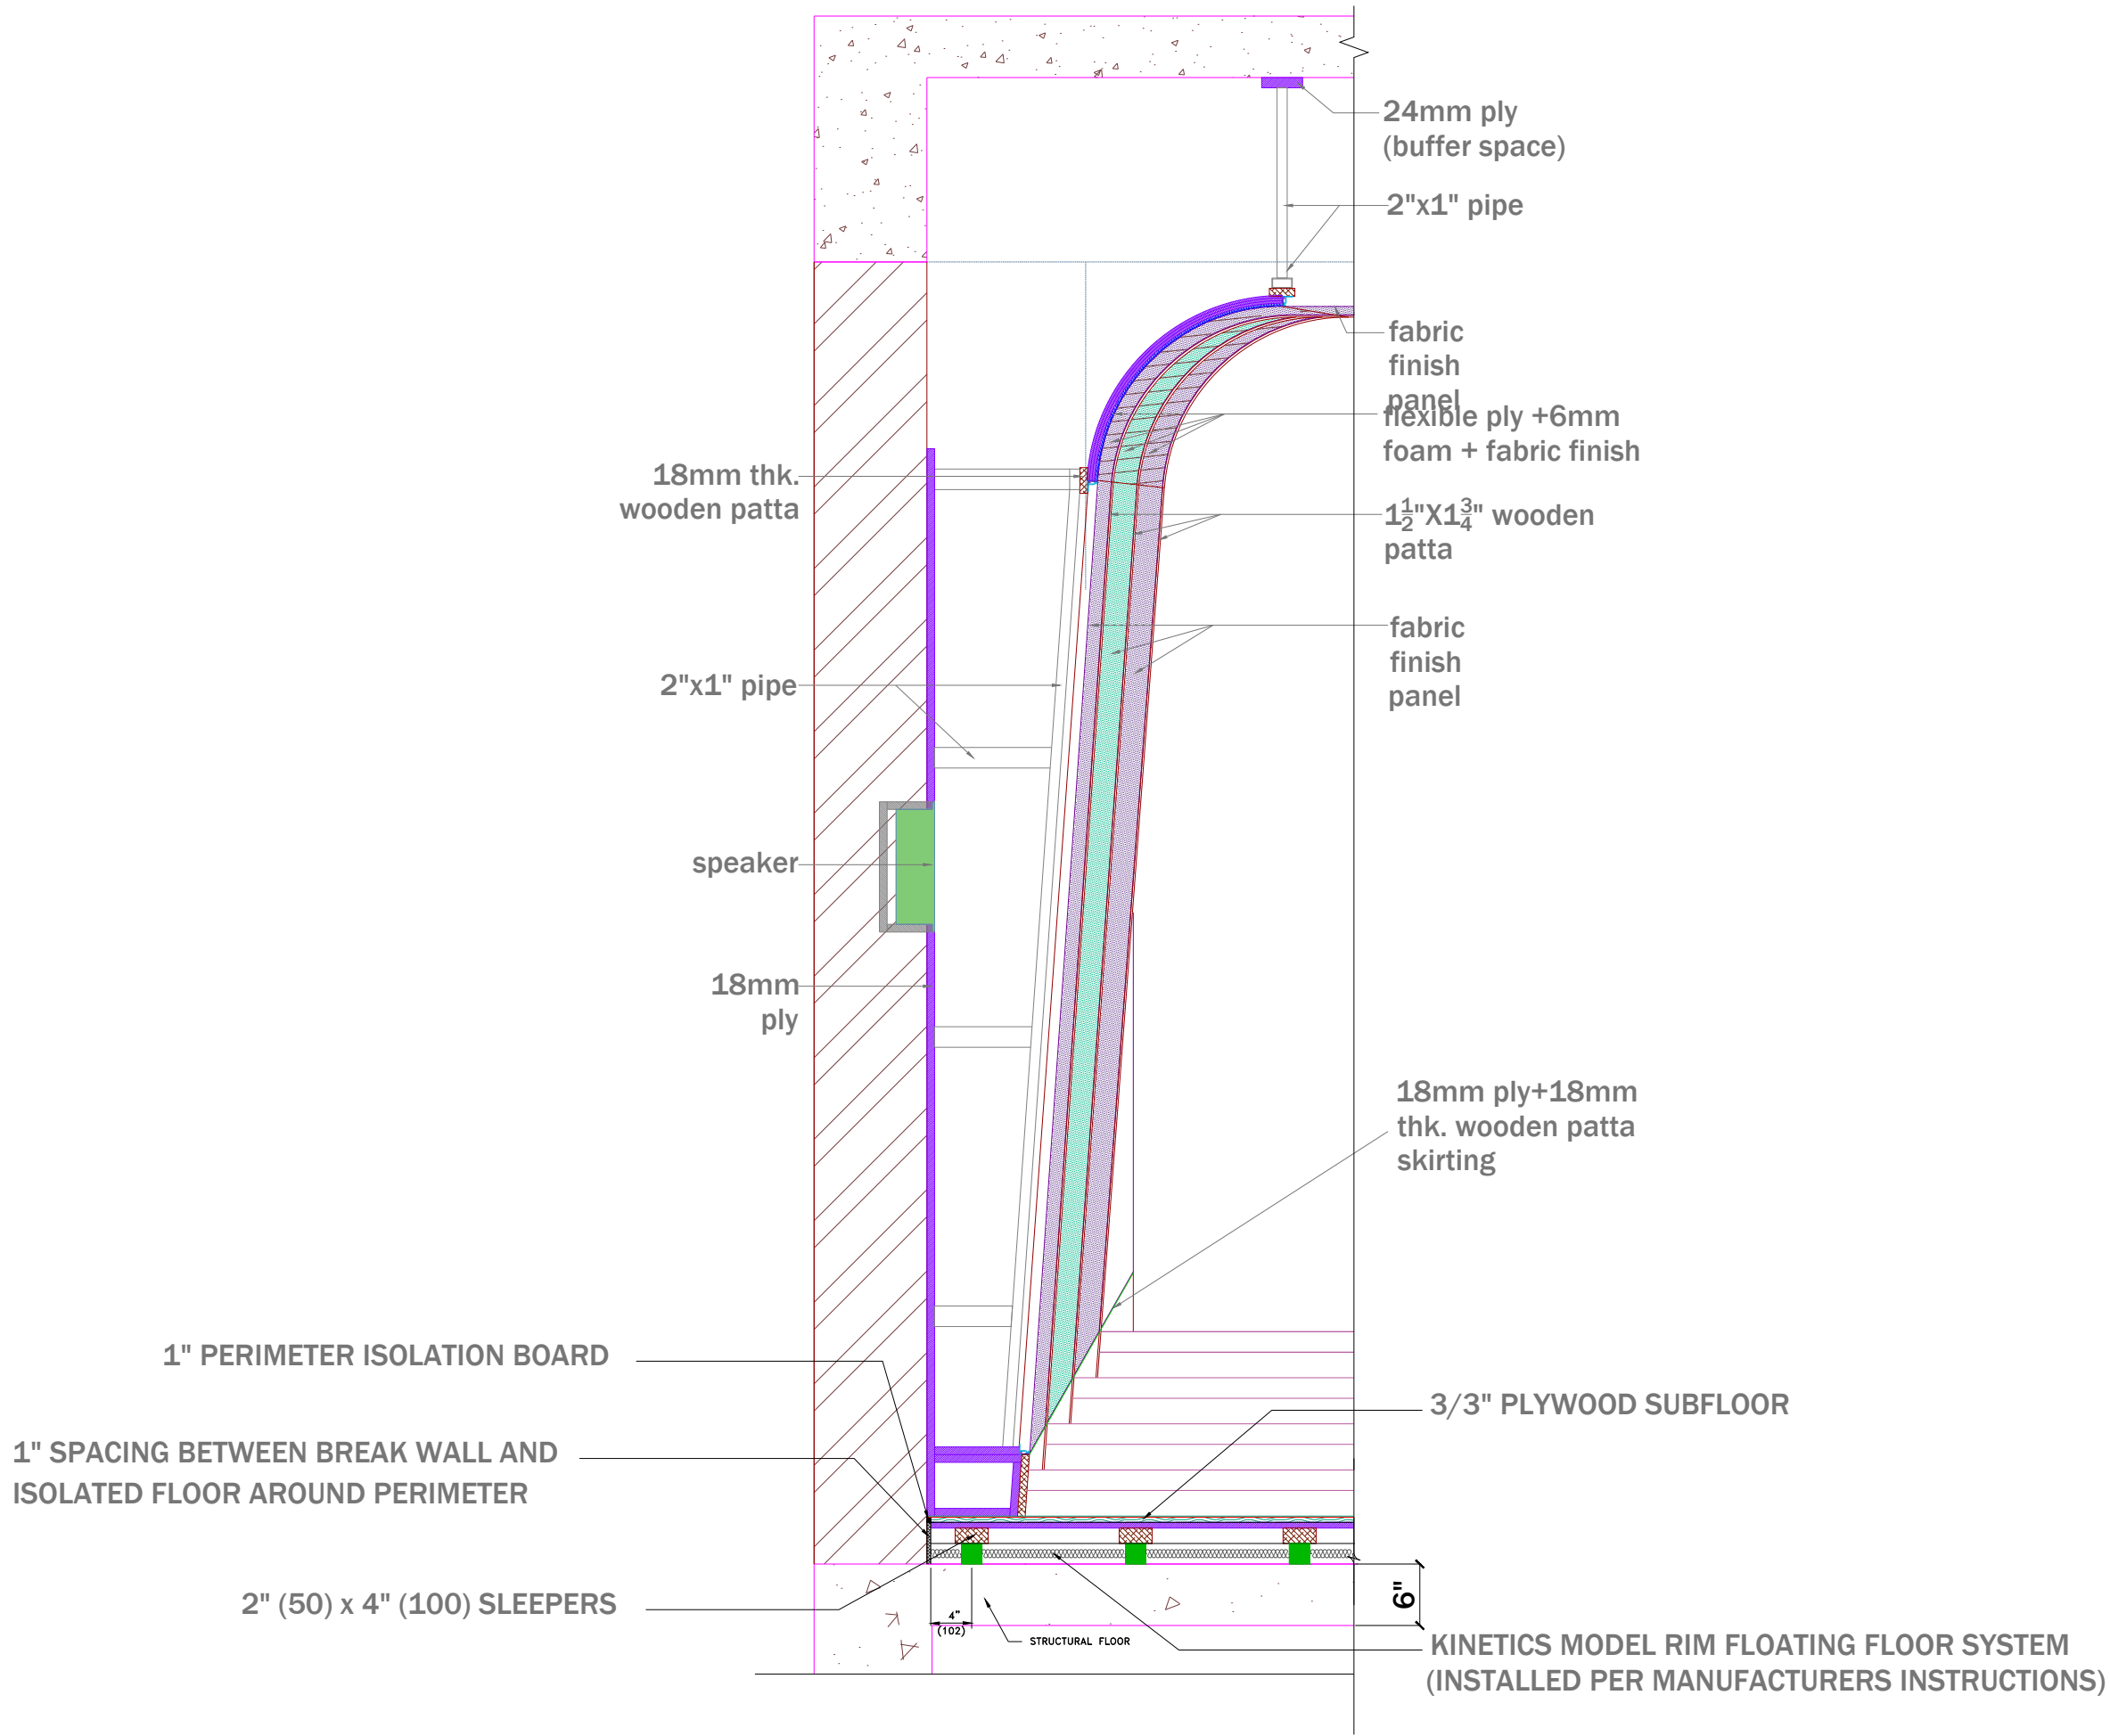

AUDIO VIDEO SYMBOLS		
SYMBOL	NAME	DO=DEVICE OPTIONS
	SPEAKER	LCR-LCR BAR SU-SUBWOOFER ST-STEREO
	VIDEO PROJECTOR	LCD-LIQUID CRYSTAL DISPLAY DLP-DIGITAL LIGHT PROCESSOR SXRD-SILICON X-TEL REF. DISP.
	PROJECTOR SCREEN	F-FIXED M-MOTORISED

COMMUNICATIONS SYMBOLS		
SYMBOL	NAME	DO=DEVICE OPTIONS
	PHONE AND DATA PORT	D-DATA F-FIBRE OPTIC P-PHONE
	INCOMING SERVICES	CTV-CABLE TV P-PHONE S-SATELLITE
	RF REPEATER ACCESS POINT	CR-CELLUAR PR-PHONE WAP-WIRELESSACCESS POINT

FURNISHINGS SYMBOLS		
SYMBOL	NAME	DO=DEVICE OPTIONS
	RACK OR HEAD END	AV-AUDIO/VIDEO C-CONTROL D-DATA SEC-SECURITY
	LIFT/MOUNT	A-ARTICULATED M-MOTORISED UB-UNDER BED

EXAMPLES: SYMBOL + MOUNTING OPTION		
SYMBOL	NAME	MOUNT TYPE
	SPEAKER	CEILING MOUNTED
	SPEAKER	WALL MOUNTED
	SPEAKER	FLOOR MOUNTED
	PRE-WIRE SPEAKER	CEILING MOUNTED PRE-WIRE ONLY NO CUTOUT

CABLING OPTIONS			
	SPKR	2CX2.5 mm ²	SPEAKER CABLE
	COXL	COAXIAL	SUBWOOFER CABLE
	CAT6	CAT6	DATA CABLE
	HDMI	HDMI	VIDEO CABLE

Client : CLINICAL RETREAT

Location : ANAND

Created 13-06-2017
 Modified Not yet
 Printed Not yet

Drawing Name : ISOLATED FLOOR

Drawing Type : ISOLATED FLOOR DETAIL

Drawing Scale : SCALE TO FIT

Designed by Ruchi

Checked by Ankur Bhatt

HC-052/16